


CLR PROJECT 06-22-DR-004


DORCHESTER DRIVE

DRAINAGE

LITTLE ROCK, ARKANSAS

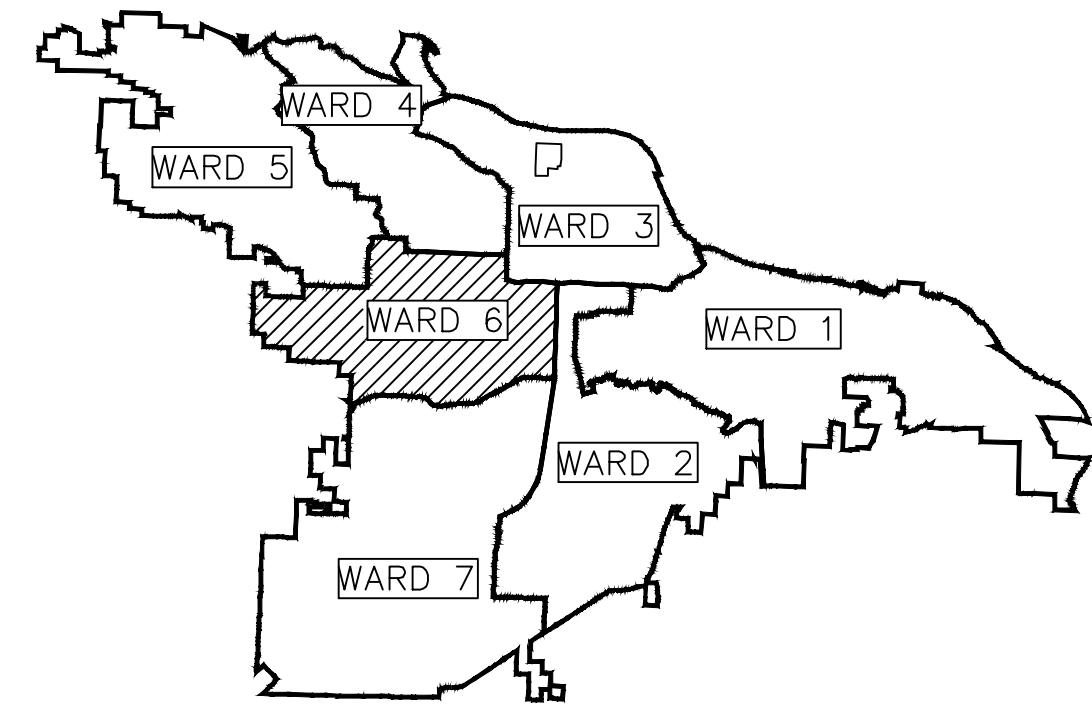

PROJECT LOCATION – WARD 6

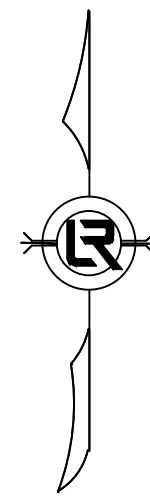


2023-2025
BOND PROGRAM

15% LEVEL
MARCH 2024

DEPARTMENT OF PUBLIC WORKS
CIVIL ENGINEERING
701 WEST MARKHAM STREET
LITTLE ROCK, ARKANSAS 72201

TABLE OF CONTENTS

SHEET NO.	TITLE
C1	COVER SHEET
C2	GENERAL NOTES, LEGEND, AND QUANTITIES
C3	EXISTING LAYOUT & DEMOLITION PLAN
C4	PROPOSED LAYOUT
C5	PLAN AND PROFILE – DORCHESTER DRIVE
C6	EROSION CONTROL PH 1
C7	EROSION CONTROL PH 2
C8	TRAFFIC CONTROL

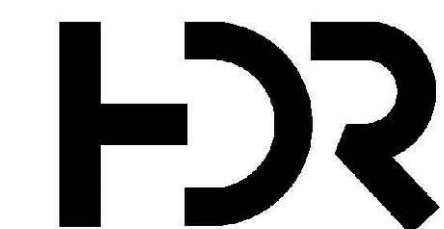


10825 FINANCIAL CENTRE PKWY
SUITE 212
LITTLE ROCK, AR 72211
501-435-3700

REVISIONS	DATE

CITY OF LITTLE ROCK, ARKANSAS
DORCHESTER DRIVE DRAINAGE

COVER SHEET

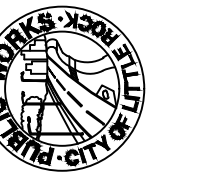

DEPARTMENT OF PUBLIC WORKS
CIVIL ENGINEERING
701 W. MARKHAM
LITTLE ROCK, ARKANSAS 72201



DRAWN BY

JAA

DESIGNED

VSE

CHECKED

JPC

DATE

1/8/24

SCALE

NTS

PROJECT NO.

06-22-DR-004

SHEET NO.


C1


REVISIONS	DATE

ESTIMATED QUANTITIES			
CLR PROJECT 06-22-DR-004			
DORCHESTER DRIVE DRAINAGE			
	15-Mar-24		
ITEM #	ITEM DESCRIPTION	UNIT	QUANTITY
2.01	SITE PREPERATION	LS	1
3.01	UNCLASSIFIED EXCAVATION	CY	322
8.03	CONCRETE CURB AND GUTTER (CLASS 3)	LF	17
10.02	CURB INLET	EA	1
13.42P	STORM DRAIN PIPE 15" RCP	LF	140
9.01	CONCRETE SIDEWALK	SF	62
13	TIE INTO EXISTING PIPE	EA	1
14.01	SOLID SODDING, MATCH EXISTING	SY	176
16.01	MAINTENANCE OF TRAFFIC	LS	1
19.10	FINAL CLEANUP	LS	1
24.11	SILT FENCE - TYPE A (SFA)	LF	280
49.00	TOPSOIL	CY	260
6.01	ASPHALT REPAIRS	SY	70

EXISTING	PROPOSED
IRON ROD	PROPOSED CONTOUR
PK NAIL	PROPOSED SPOT ELEVATION
R.R. SPIKE	PROPOSED SPOT CURB ELEVATION
CONC. MONUMENT	STORM SEWER - PIPE
WATER VALVE	STORM SEWER - METERED END SECTION
WATER METER	STORM SEWER - GRATE INLET
FIRE HYDRANT	STORM SEWER - JUNCTION BOX
GAS METER	STORM SEWER - FLARED END SECTION
GAS VALVE	STORM SEWER - HEADWALL
CLEAN-OUT	STORM SEWER - NO WING
GUARD POST (BOLLARD)	STORM SEWER - SINGLE WING
SIGN POST	STORM SEWER - DOUBLE WING
BENCHMARK	STORM SEWER - AREA INLET
STORM SEWER MANHOLE	GRADE BREAK LINE
SANITARY SEWER MANHOLE	HIGH POINT
TELEPHONE MANHOLE	LOW POINT
ELECTRIC MANHOLE	CUT LINE
TELEPHONE BOX	FILL LINE
ELECTRIC BOX	SANITARY SEWER PIPE
CABLE BOX	SANITARY SEWER MANHOLE
UTILITY POLE	PROPOSED CURB
GUY WIRE	PROPOSED CONCRETE
LIGHT POLE	CONSTRUCTION - ENTRANCE/EXIT
POST OR POLE (TYPE AS NOTED)	CHECK DAM
MAILBOX	DIVERSION BERM
DECIDUOUS TREE	DOWNDRAIN STRUCTURE - TEMPORARY
EVERGREEN/CONIFEROUS TREE	ROCK DAM
BUSH	SEDIMENT BARRIER - SILT FENCE
PROPERTY LINE	SEDIMENT BARRIER - GRAVEL RING
SETBACK LINE	SEDIMENT BARRIER - BLOCK & GRAVEL
EASEMENT LINE	SEDIMENT BARRIER - BLOCK
CURB	TEMPORARY SEDIMENT BASIN
FENCE	SILT FENCE - TYPE A
OVERHEAD ELECTRIC	SILT FENCE - TYPE B
OVERHEAD TELEPHONE	SILT FENCE - TYPE C
OVERHEAD CABLE	STORM DRAIN OUTLET PROTECTION
UNDERGROUND TELEPHONE	SURFACE ROUGHENING
UNDERGROUND ELECTRIC	DISTURBED AREA STABILIZATION -TEMPORARY STABILIZATION
UNDERGROUND CABLE	DISTURBED AREA STABILIZATION -TEMPORARY GRASSING
WATER LINE	DISTURBED AREA STABILIZATION -PERMANENT GRASSING
SEWER LINE	MATting/BLANKETS
GAS LINE	
STORM SEWER/CULVERT	
EDGE OF WOODS	
CONTOUR LINE	

CITY OF LITTLE ROCK, ARKANSAS
DORCHESTER DRIVE DRAINAGE
GENERAL NOTES, LEGEND, AND QUANTITIES


 DEPARTMENT OF PUBLIC WORKS
 CIVIL ENGINEERING
 701 W. MARKHAM
 LITTLE ROCK, ARKANSAS 72201

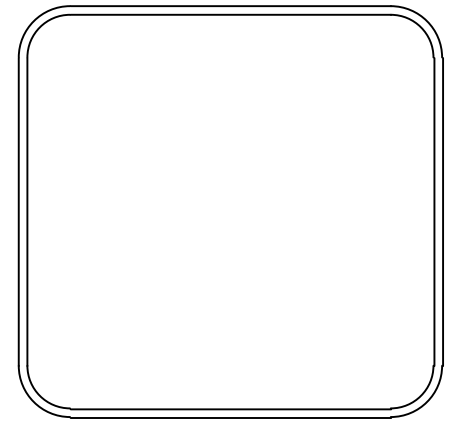


DRAWN BY JAA
DESIGNED VSE
CHECKED JPC
DATE 1/8/24
SCALE NTS
PROJECT NO. 06-22-DR-004
SHEET NO. C2

C:\Users\veggers\OneDrive - HDR, Inc\CLP Projects\CLR Dorchester Drive\DORCHESTER DRIVE.dwg, C2 LEGEND, 3/15/2024 8:24:04 AM, VEGGERS

REVISIONS	DATE


CITY OF LITTLE ROCK, ARKANSAS
DROCHESTER DRIVE DRAINAGE
EXISTING LAYOUT & DEMOLITION PLAN

DEPARTMENT OF PUBLIC WORKS
CIVIL ENGINEERING
701 W. MARKHAM
LITTLE ROCK, ARKANSAS 72201

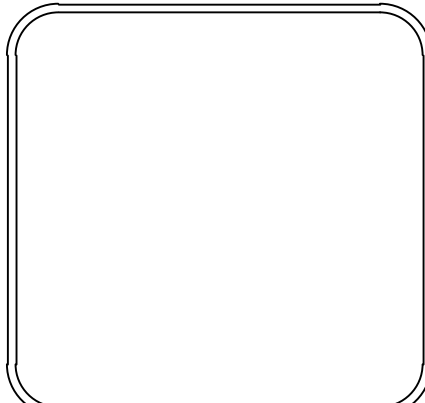

DRAWN BY
JAA
DESIGNED
VSE
CHECKED
JPC
DATE
2/16/24
SCALE
1:15
PROJECT NO.
06-22-DR-004
SHEET NO.
C3

- LEGEND:
- PROPERTY LINE
 - CENTER LINE
 - DEMOLITION LINE
 - STORM SEWER
 - FENCE
 - FIRE HYDRANT
 - WATER VALVE
 - LIGHT POST

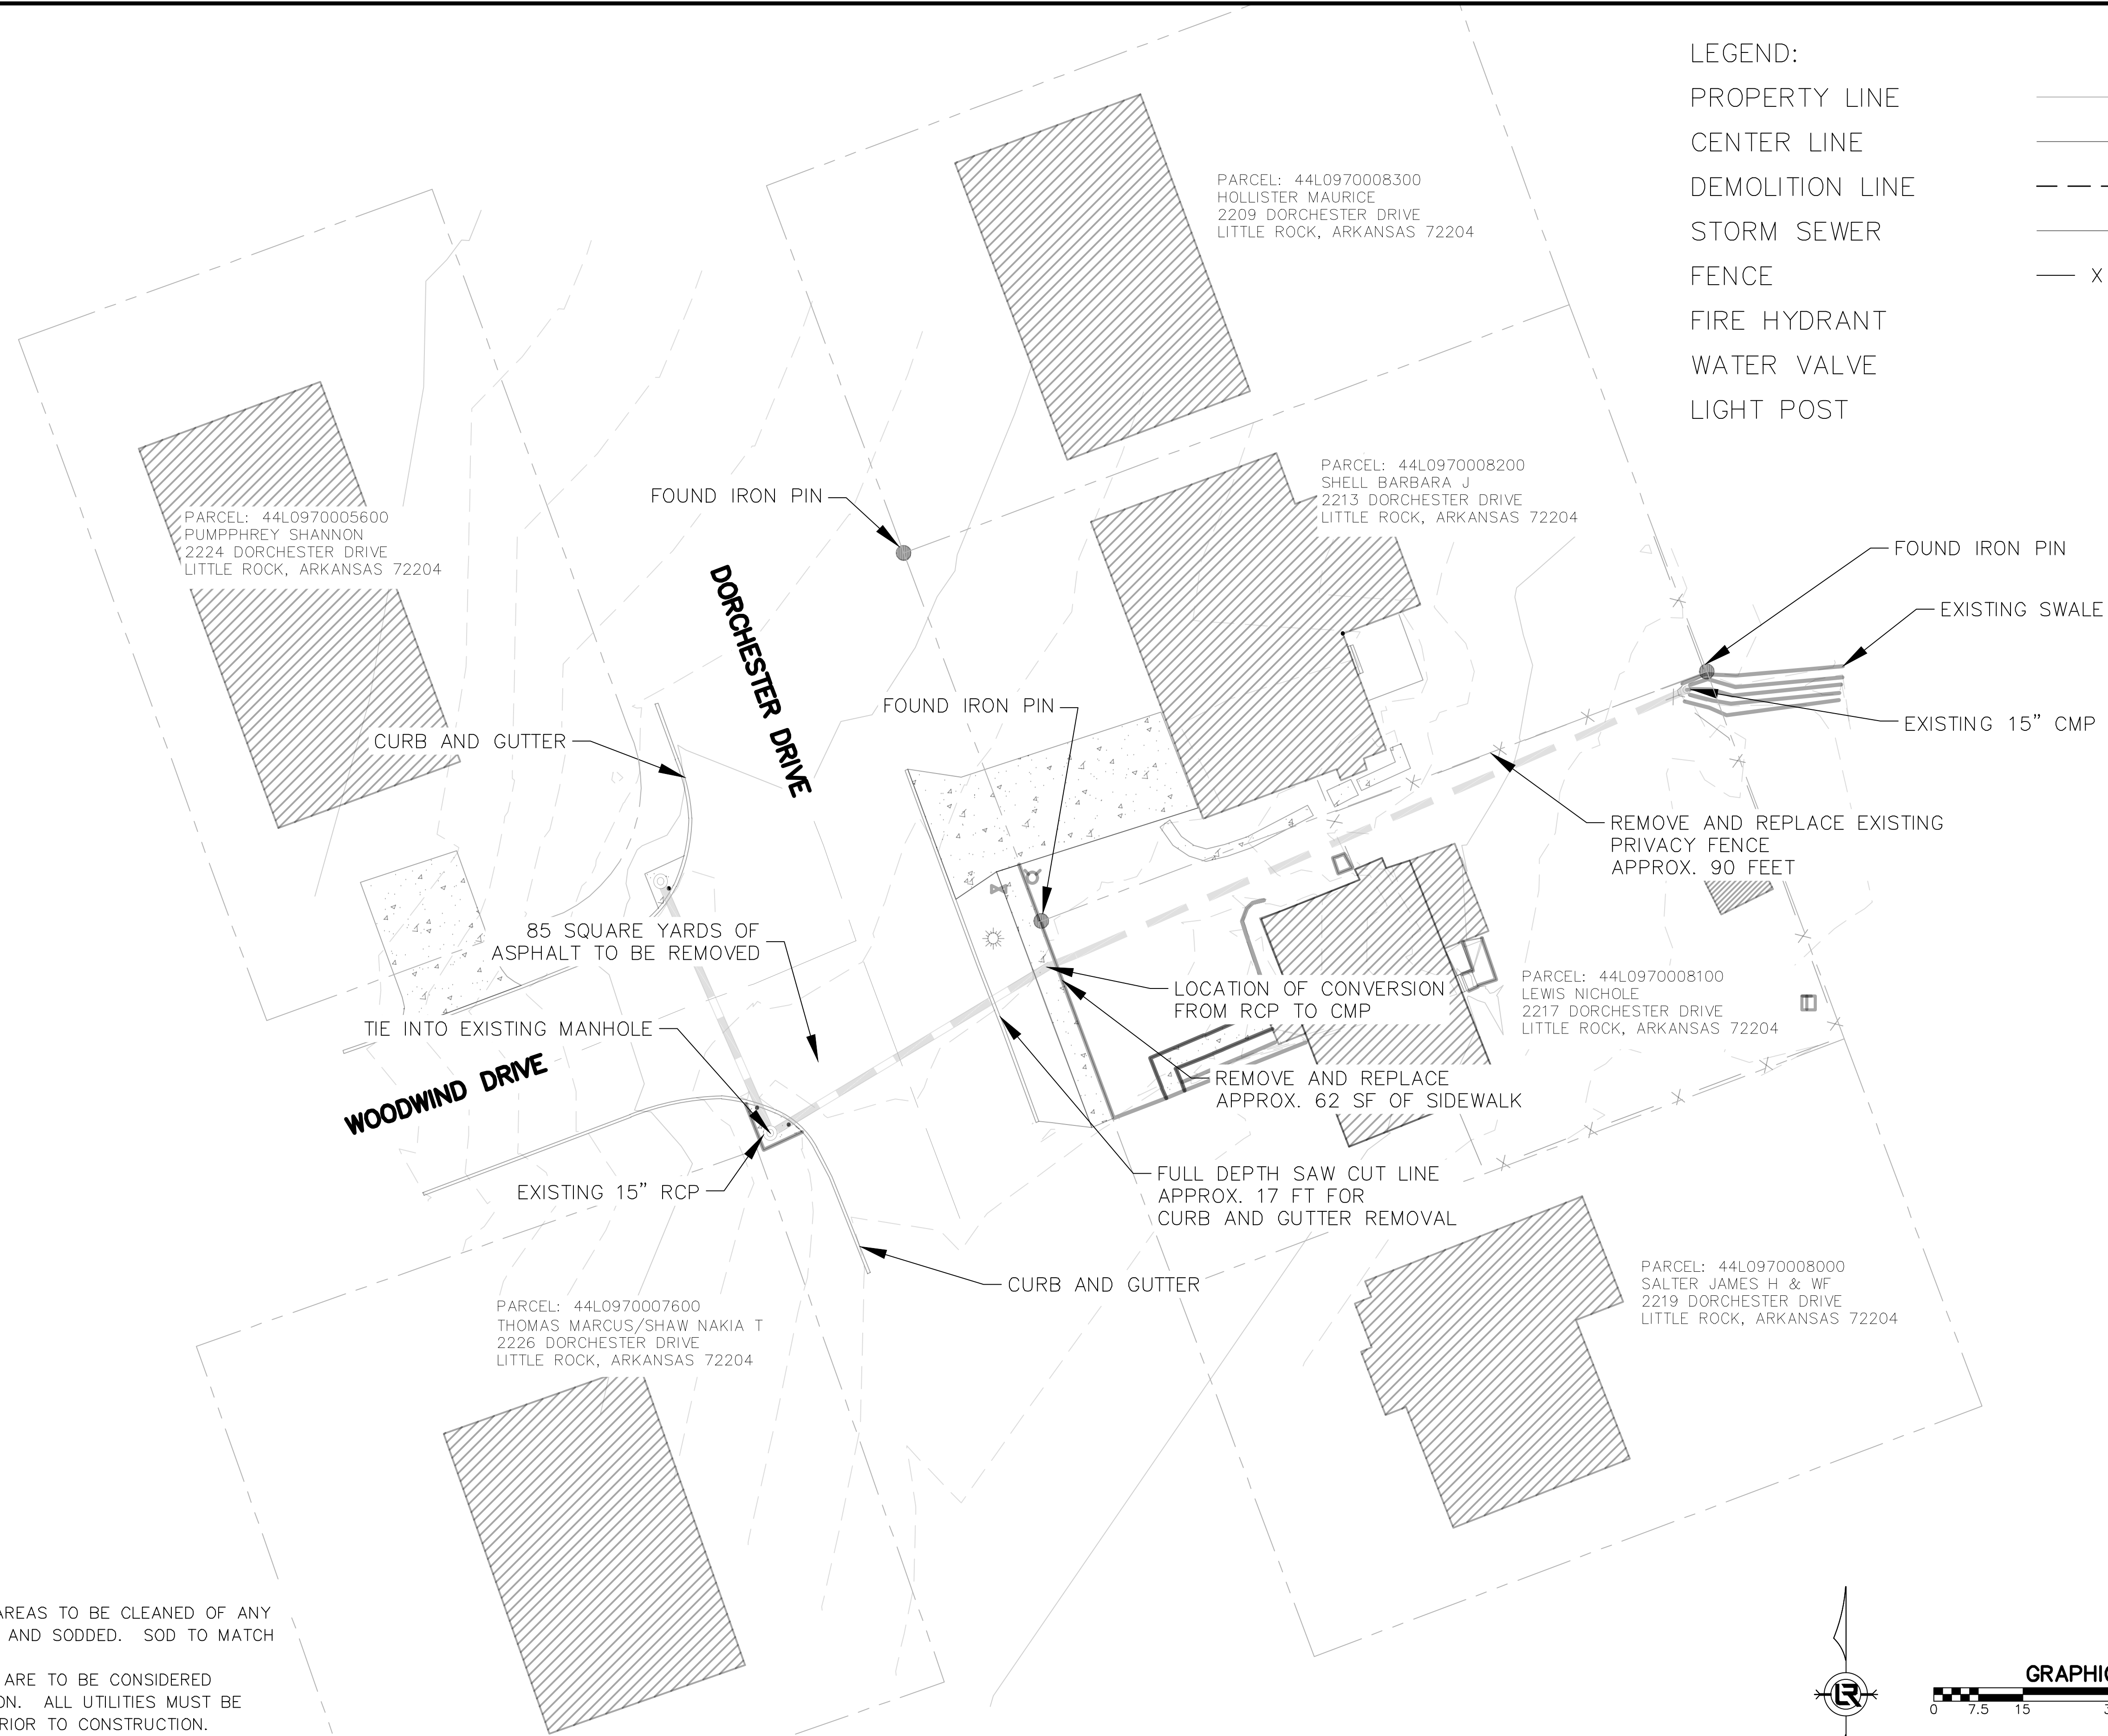

PARCEL: 44L0970008300
HOLLISTER MAURICE
2209 DORCHESTER DRIVE
LITTLE ROCK, ARKANSAS 72204

PARCEL: 44L0970005600
PUMPPHREY SHANNON
2224 DORCHESTER DRIVE
LITTLE ROCK, ARKANSAS 72204


PARCEL: 44L0970008200
SHELL BARBARA J
2213 DORCHESTER DRIVE
LITTLE ROCK, ARKANSAS 72204

PARCEL: 44L0970008100
LEWIS NICHOLE
2217 DORCHESTER DRIVE
LITTLE ROCK, ARKANSAS 72204

PARCEL: 44L0970007600
THOMAS MARCUS/SHAW NAKIA T
2226 DORCHESTER DRIVE
LITTLE ROCK, ARKANSAS 72204

PARCEL: 44L0970008000
SALTER JAMES H & WF
2219 DORCHESTER DRIVE
LITTLE ROCK, ARKANSAS 72204

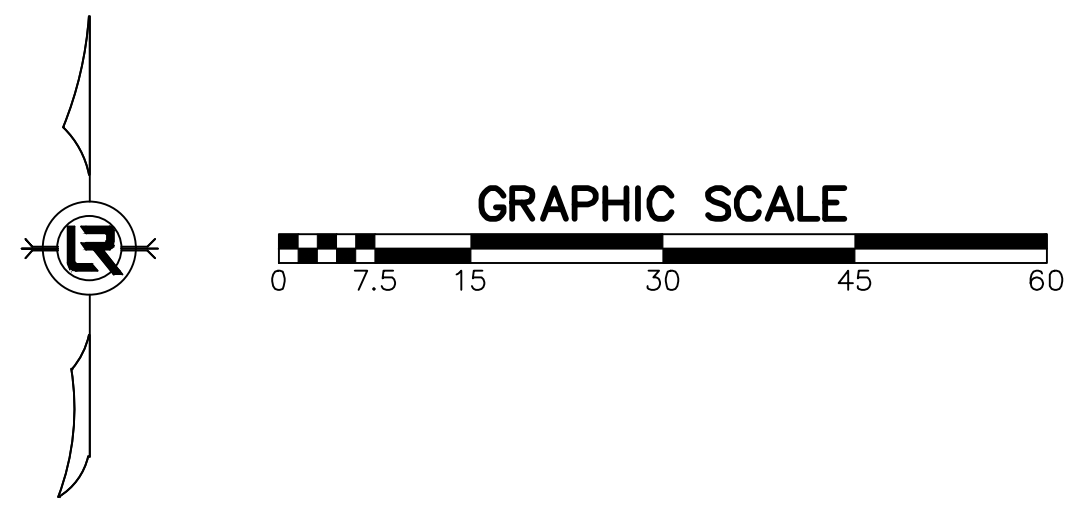


- GENERAL NOTE:
- ALL DISTURBED AREAS TO BE CLEANED OF ANY DEBRIS, GRADED, AND SODDED. SOD TO MATCH EXISTING GRASS.
 - UTILITIES SHOWN ARE TO BE CONSIDERED GENERAL LOCATION. ALL UTILITIES MUST BE FIELD VERIFIED PRIOR TO CONSTRUCTION.



REVISIONS	DATE




CITY OF LITTLE ROCK, ARKANSAS
DROCHESTER DRIVE DRAINAGE
PROPOSED LAYOUT

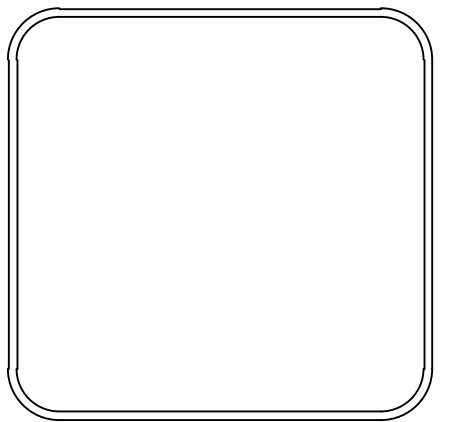
DEPARTMENT OF PUBLIC WORKS
CIVIL ENGINEERING
701 W. MARKHAM
LITTLE ROCK, ARKANSAS 72201







DRAWN BY
JAA
DESIGNED
VSE
CHECKED
JPC
DATE
2/16/24
SCALE
1:15
PROJECT NO.
06-22-DR-004
SHEET NO.
C4

LEGEND:

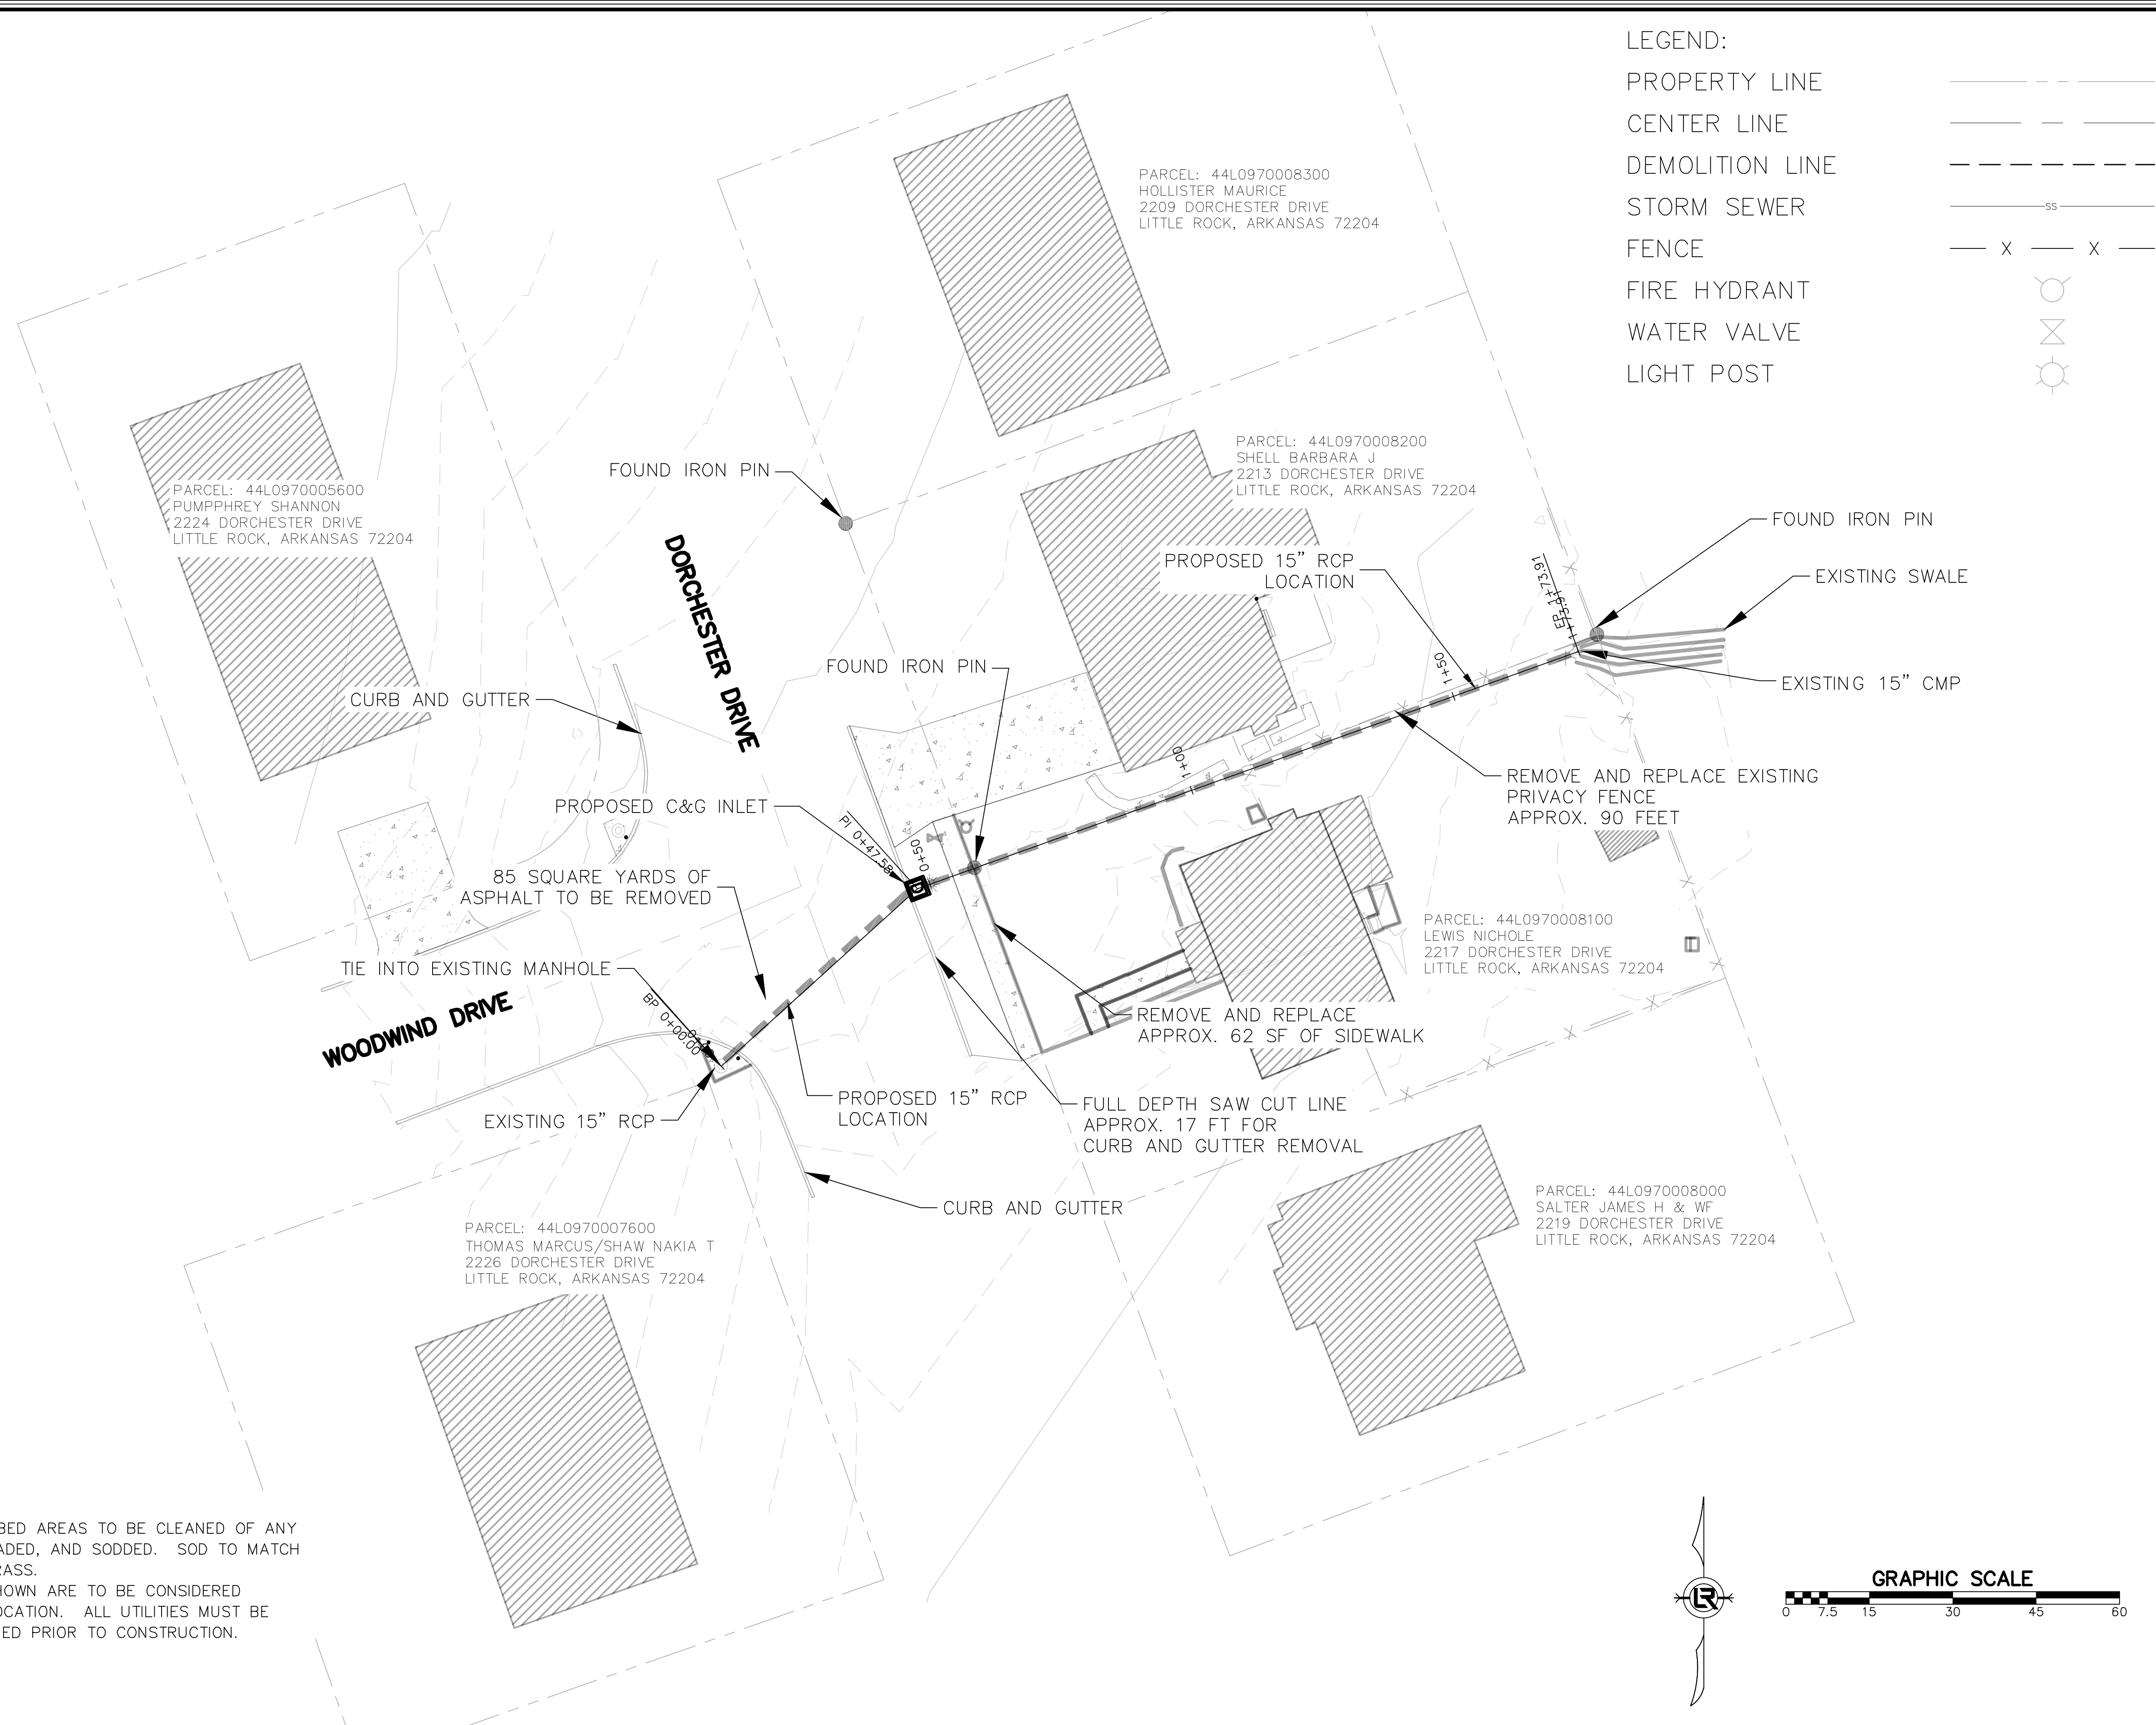PROPERTY LINE	---
CENTER LINE	— — — — —
DEMOLITION LINE	- - - - -
STORM SEWER	— ss —
FENCE	— X — X —
FIRE HYDRANT	
WATER VALVE	
LIGHT POST	

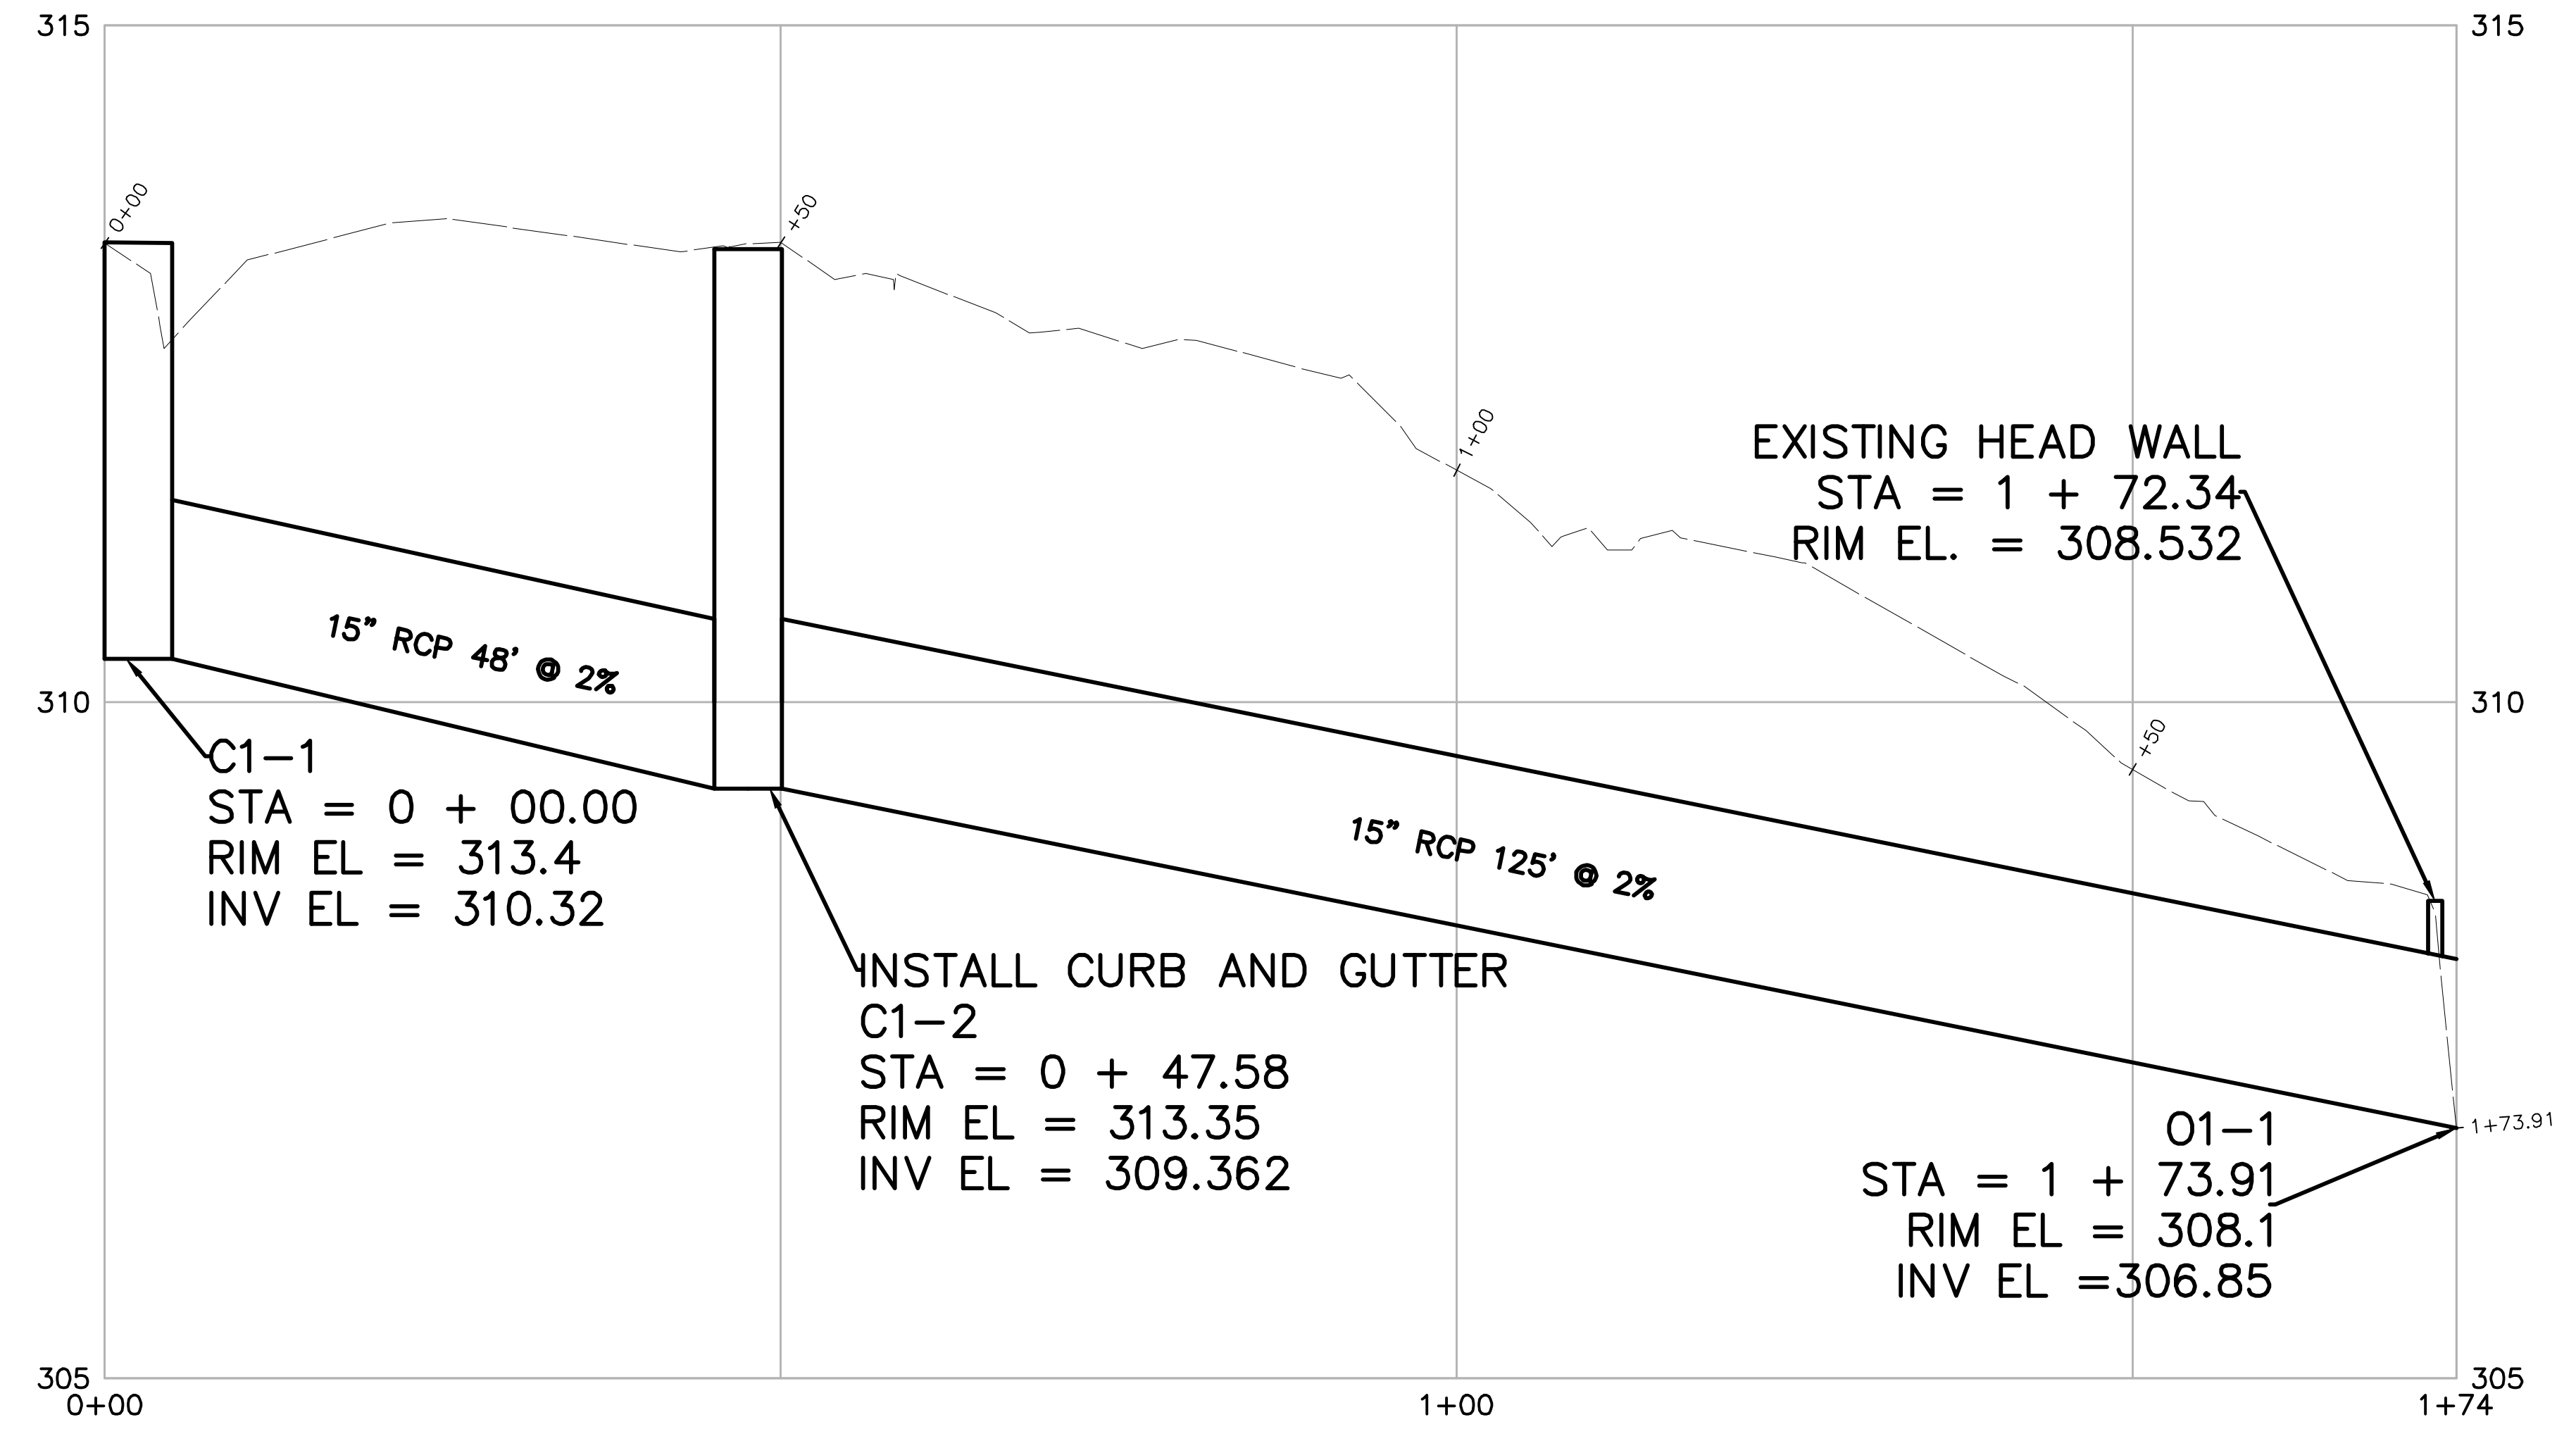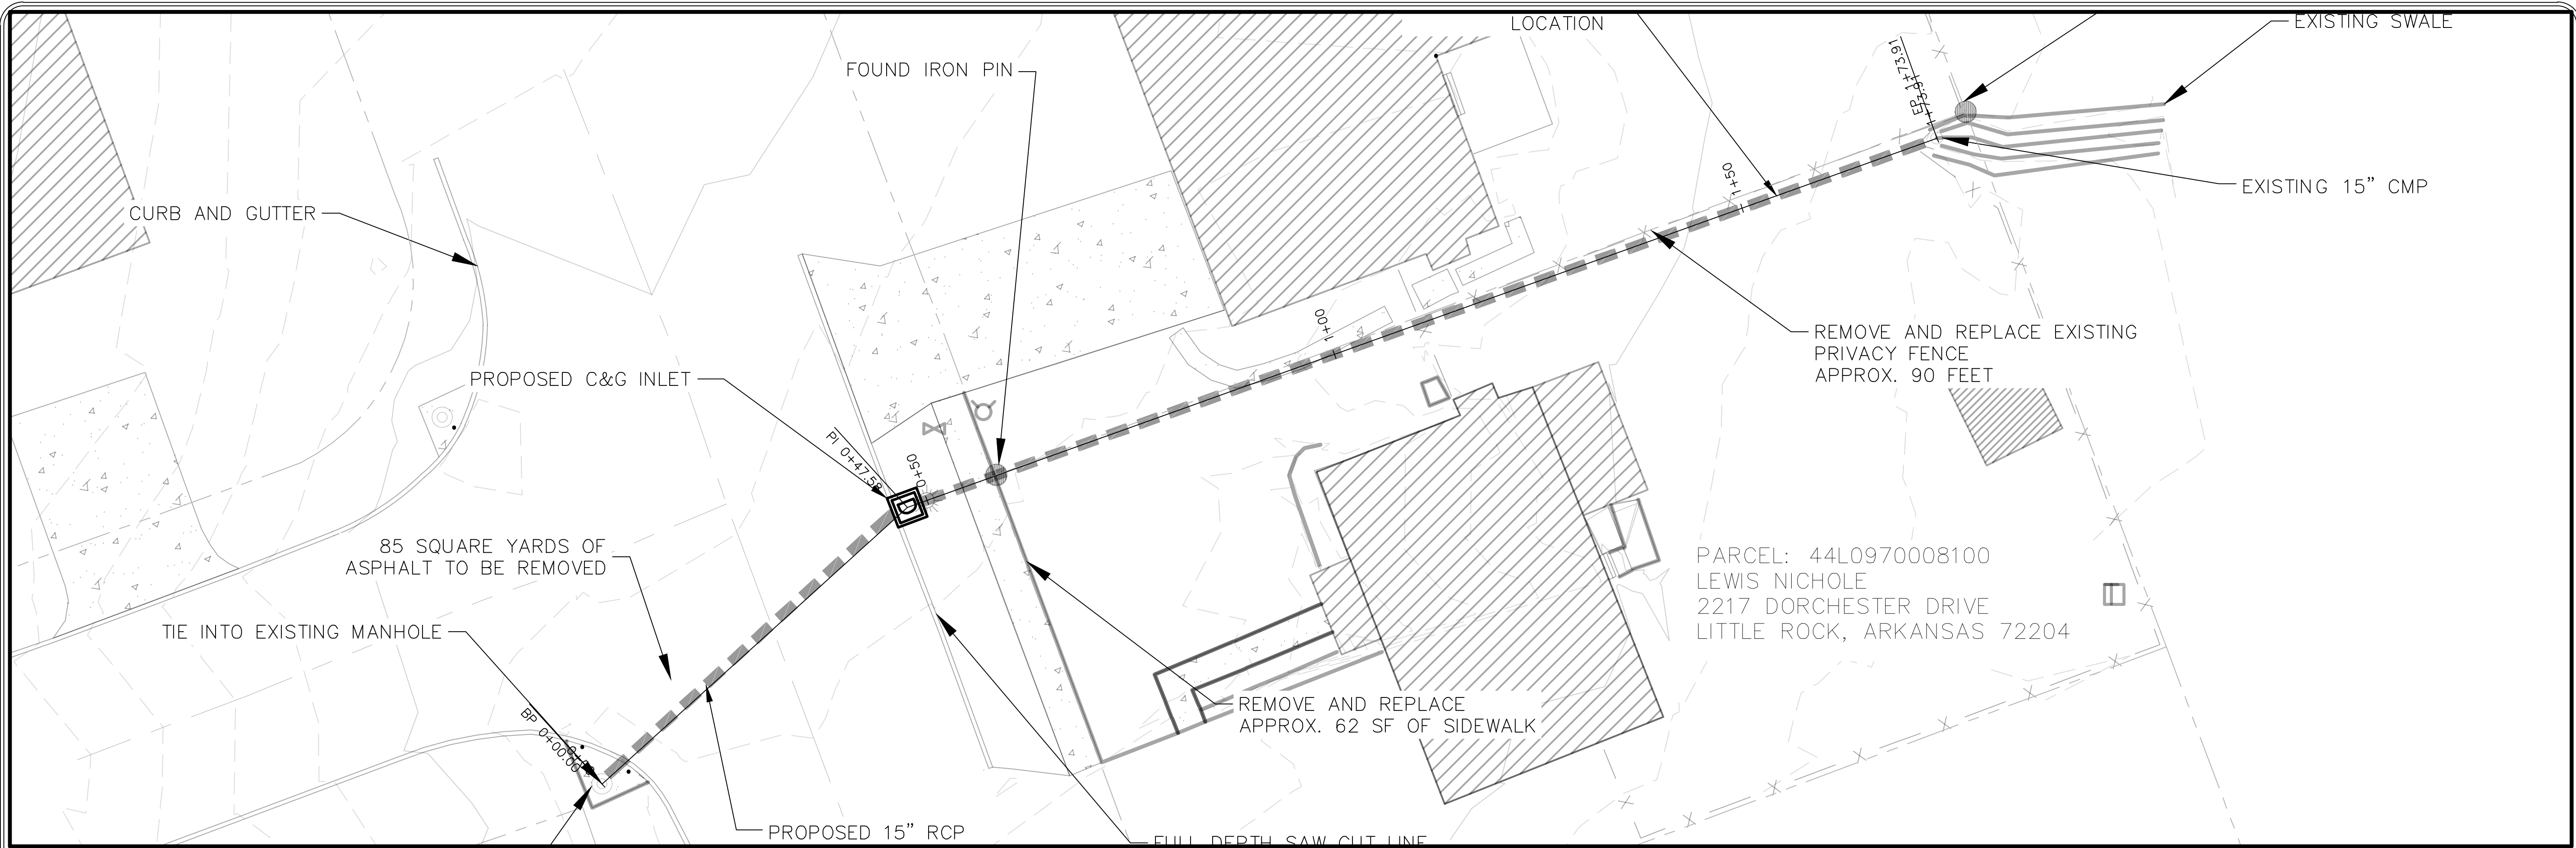




REVISIONS	DATE

CITY OF LITTLE ROCK, ARKANSAS
 DROCHESTER DRIVE DRAINAGE
 PLAN AND PROFILE

DEPARTMENT OF PUBLIC WORKS
 CIVIL ENGINEERING
 701 W. MARKHAM
 LITTLE ROCK, ARKANSAS 72201

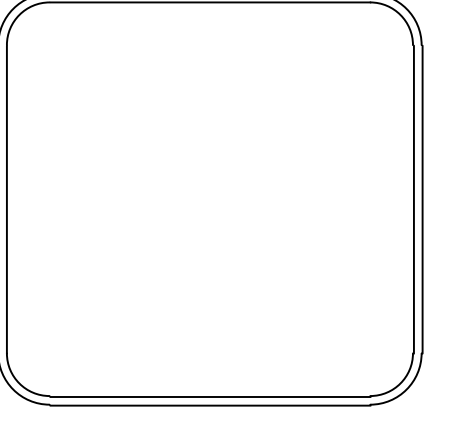

DRAWN BY JAA
DESIGNED VSE
CHECKED JPC
DATE 2/16/24
SCALE 1:10
PROJECT NO. 06-22-DR-004
SHEET NO. C5