


05-17-DR-208

MADISON VALLEY SUBDIVISION


DRAINAGE IMPROVEMENTS

LITTLE ROCK, AR

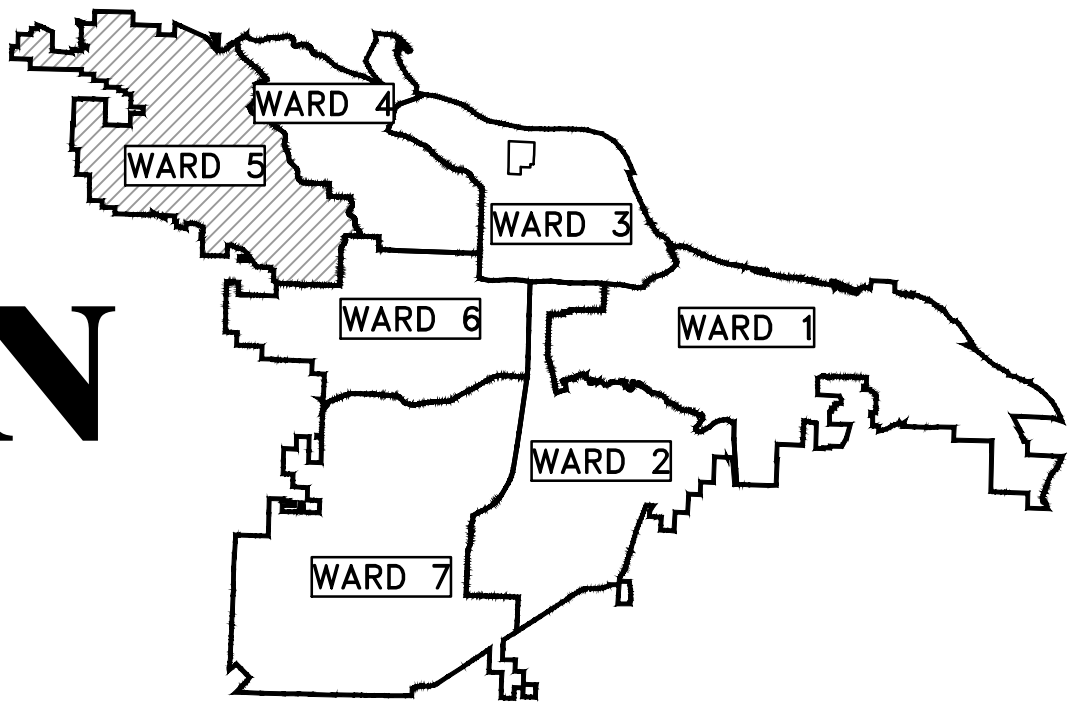

PROJECT LOCATION – WARD 5

SHEET NO.	TITLE
C1	COVER SHEET
C2	QUANTITIES, LEGEND & DETAILS
C3	STORM DRAIN PLAN AND PROFILE
C4	SANITARY SEWER PLAN AND PROFILE

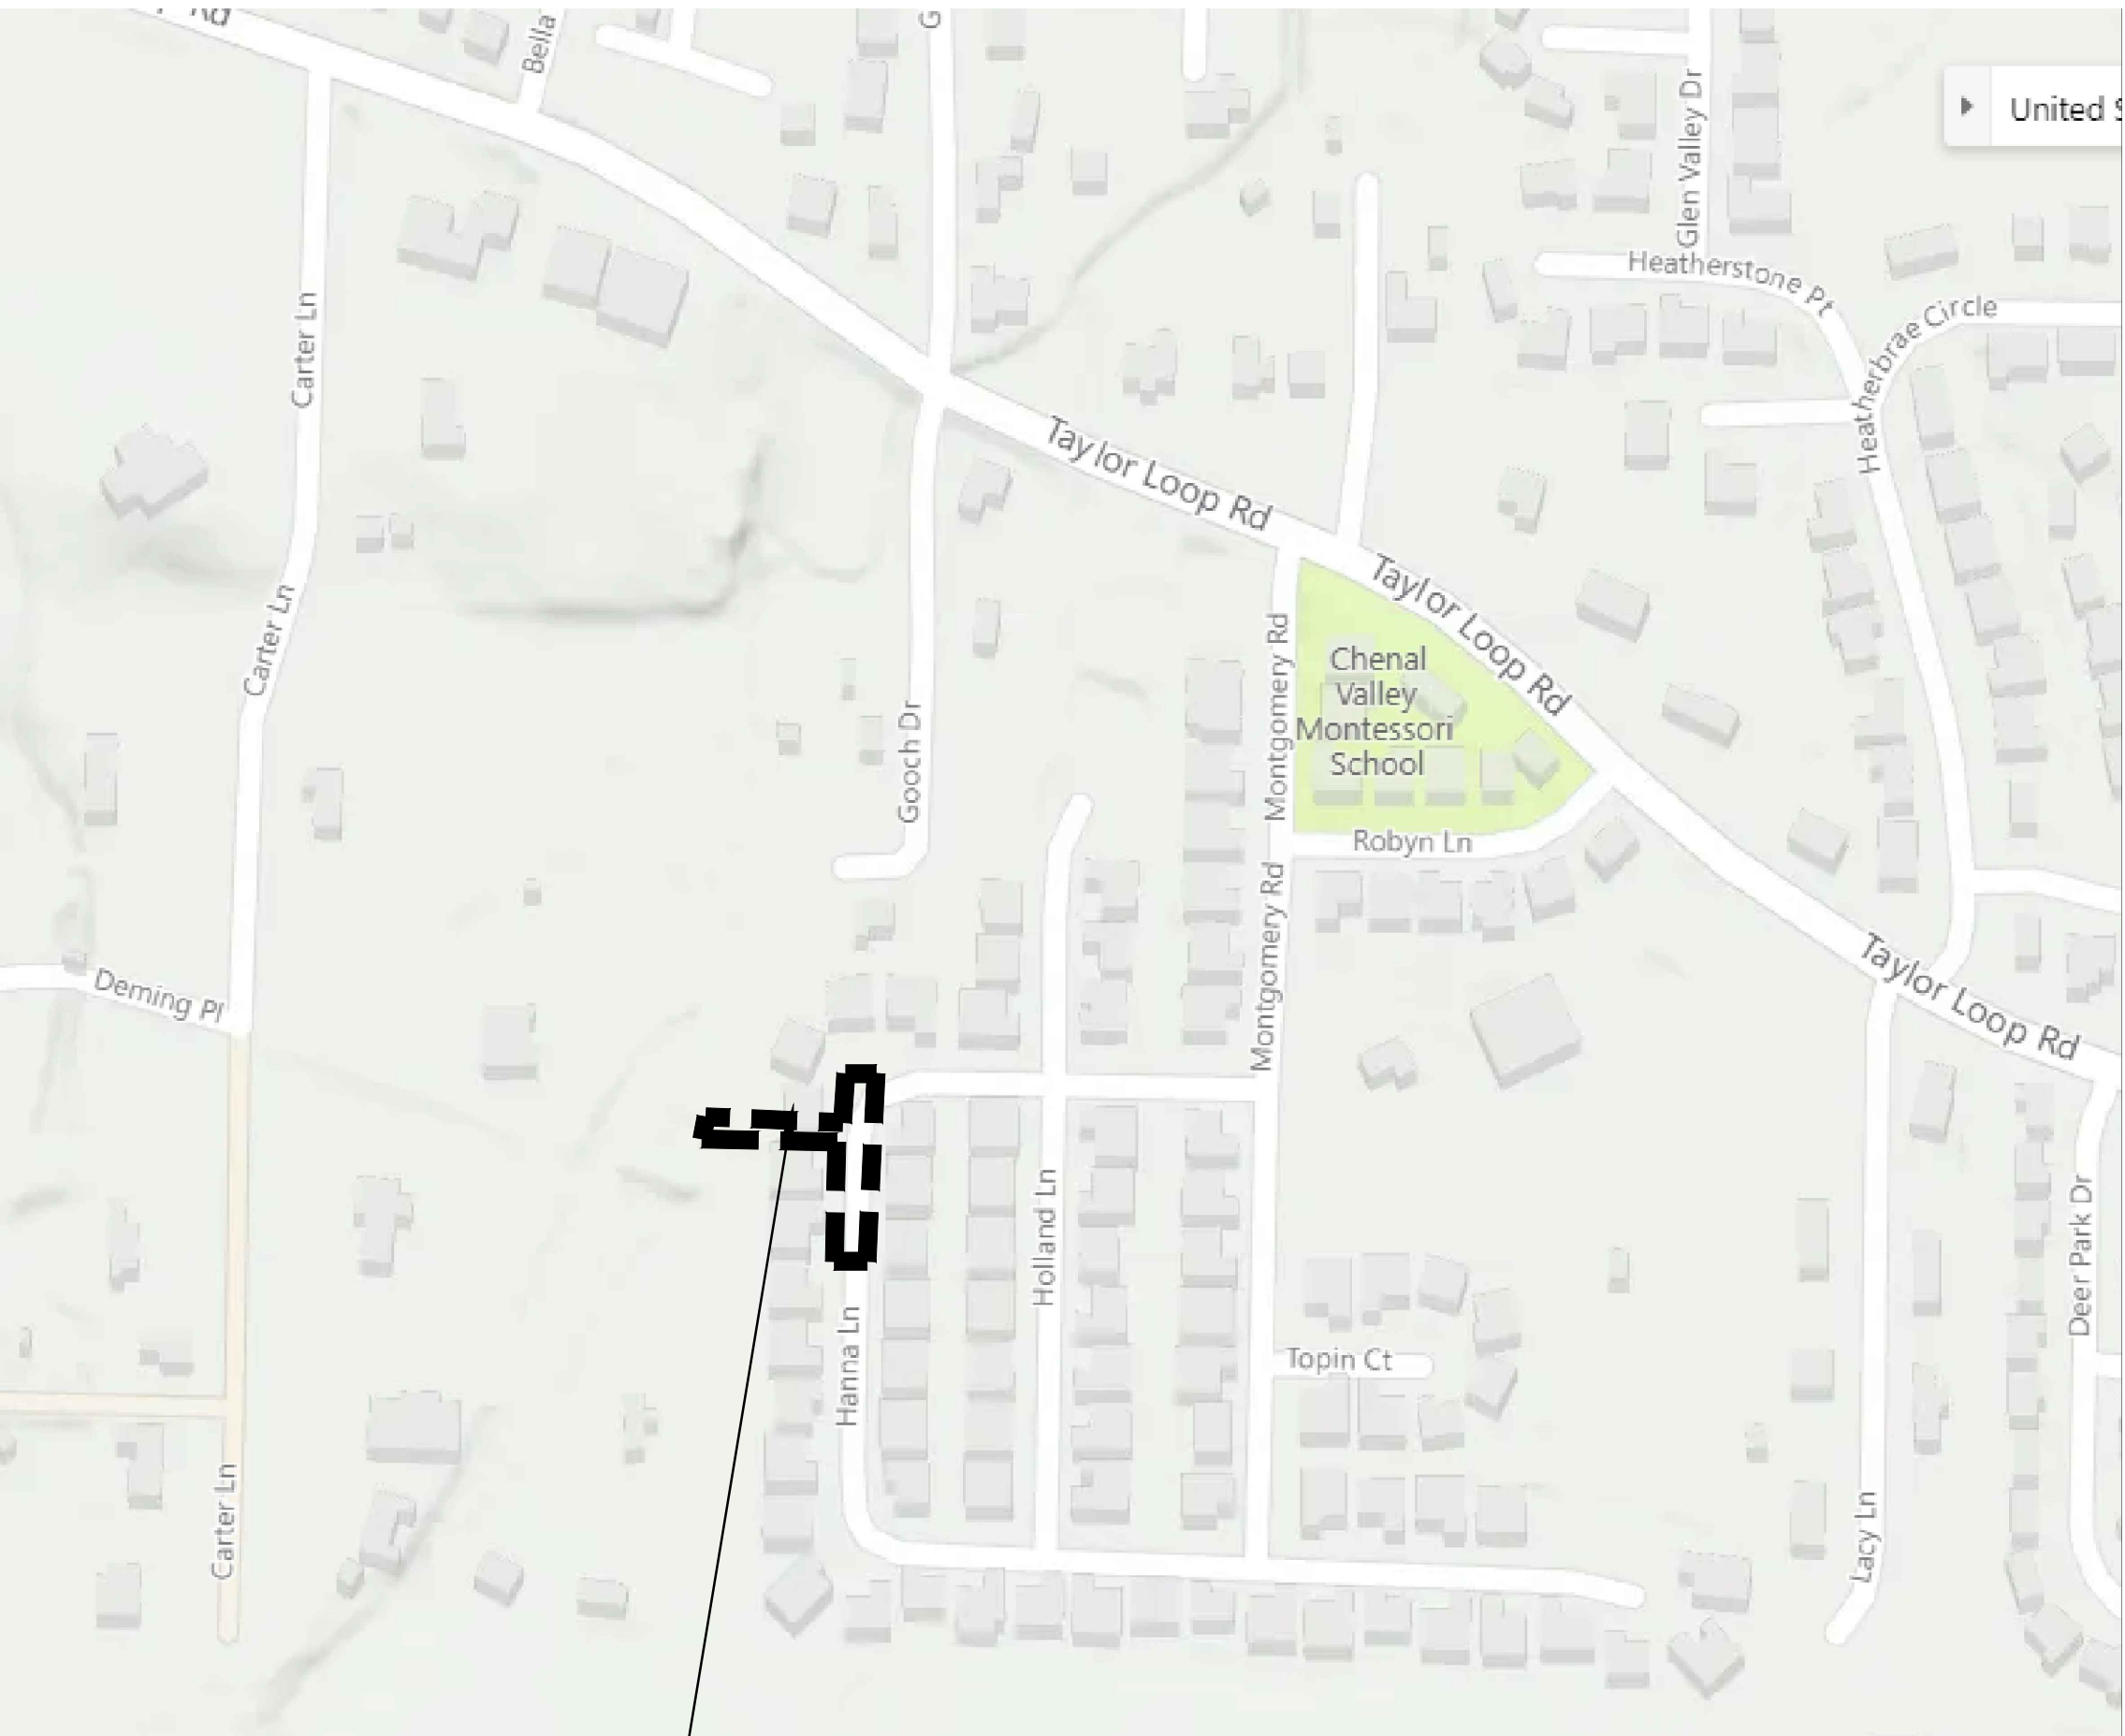

PROJECT
LOCATION



Know what's below.
Call before you dig.

2019-2021

BOND PROGRAM

DEPARTMENT OF PUBLIC WORKS
CIVIL ENGINEERING
701 WEST MARKHAM STREET
LITTLE ROCK, ARKANSAS 72201




REVISIONS	DATE

CITY OF LITTLE ROCK, ARKANSAS	COVER SHEET
MADISON VALLEY SUBDIVISION	

DEPARTMENT OF PUBLIC WORKS	
CIVIL ENGINEERING	
701 W. MARKHAM	
LITTLE ROCK, ARKANSAS 72201	

--

DRAWN BY	VH
DESIGNED	DH
CHECKED	DH
DATE	08-24-2021
SCALE	N.T.S.
PROJECT NO.	05-17-DR-208
SHEET NO.	C1

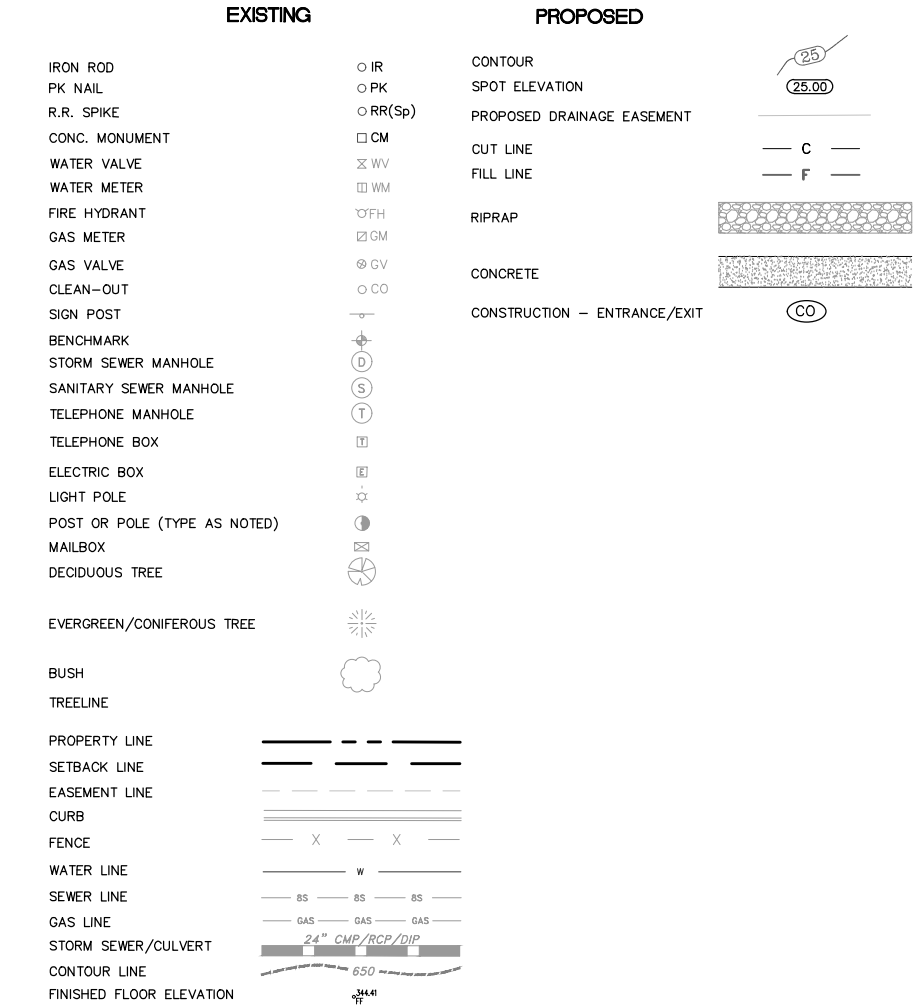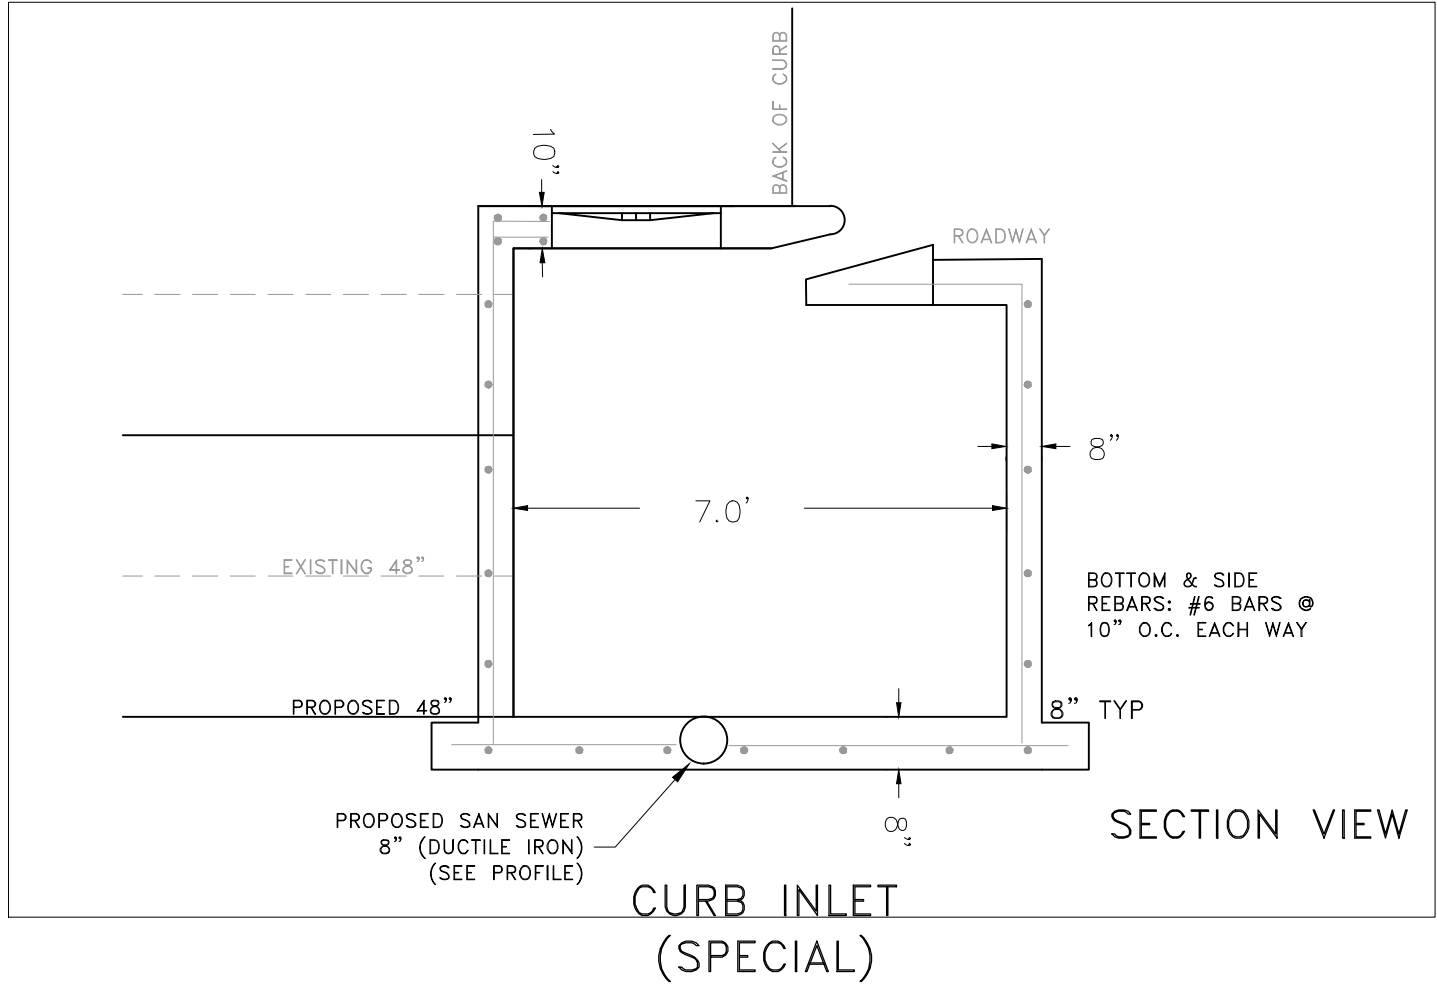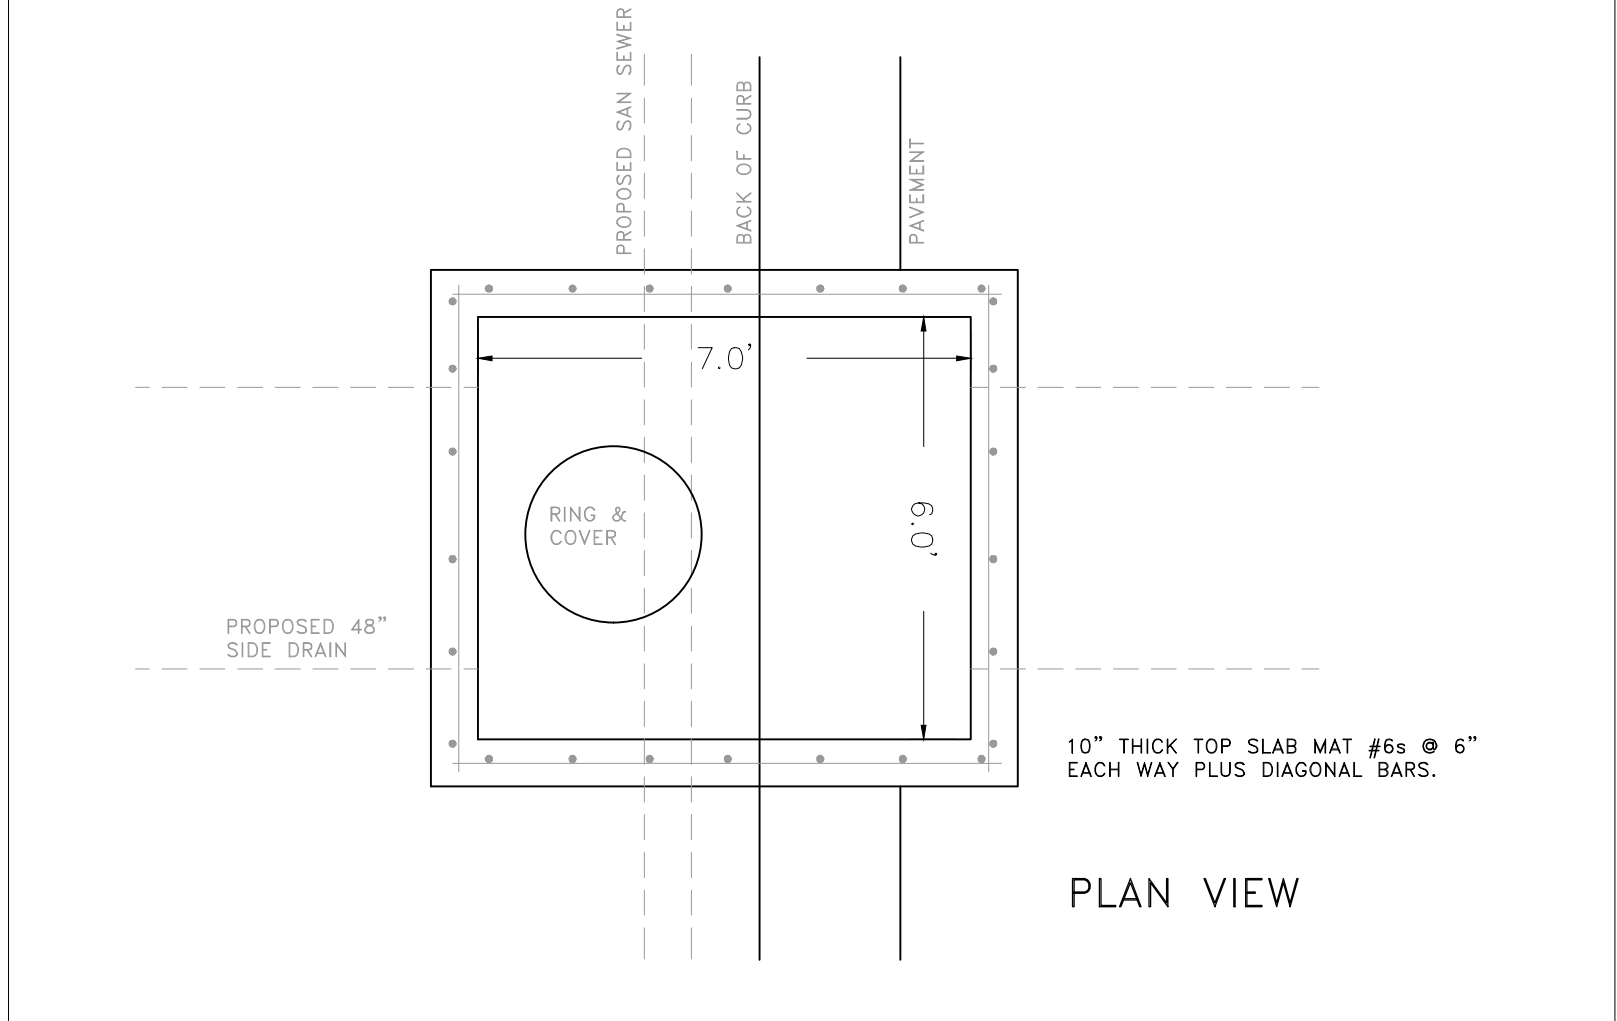

	CLR Project 05-17-DR-208		
	MADISON VALLEY DRAINAGE IMPROVEMENTS		
	August 23, 2021		
ITEM #	ITEM DESCRIPTION	UNIT	QUANTITY
	MADISON VALLEY DRAINAGE IMPROVEMENTS		
2.01	Site Preparation, Including Mobilization	LS	1
7.06	Concrete Driveway (6" Thick) Standard Finish	SF	100
8.03	Concrete Curb and Gutter (Class 3)	LF	60
10.03	Curb Inlet Special (See Detail)	EA	1
13.48C	48" Cross Drain (RCP)	LF	30
13.48S	48" Side Drain	LF	114
13.61	Tie Into Existing Inlet	EA	1
14.01	Solid Sodding (Match Existing) Including Topsoil	SY	175
17.01	Utility Street Cut - Existing Street	SY	80
18.01	Remove and Replace Fence (6' Wood)	LF	125
18.45	Riprap	CY	36
19.01	Final Cleanup	LS	1
26.01	Trench and Excavation Safety (including San Sewer)	LS	1

	CLR Project 05-17-DR-208		
ITEM #	MADISON VALLEY DRAINAGE IMPROVEMENTS		
	August 23, 2021		
	ITEM DESCRIPTION	UNIT	QUANTITY
SS1	MADISON VALLEY SANITARY SEWER IMPROVEMENTS		
SS2			
SS3	8" Ductile Iron Pipe Installed	LF	64
SS4	Connection To Existing Manhole	EA	1
SS5	Sanitary Sewer Manhole (W / Offset Cone)	EA	1
SS6	4" SDR 21 Sanitary Sewer Connection	EA	2
SS7	Select Backfill	CY	60
	Vacuum / Pressure Testing	LS	1
	Trenching (6'-8')	LF	64

REVISIONS	DATE

CITY OF LITTLE ROCK, ARKANSAS	QUANTITIES, LEGEND AND DETAIL
MADISON VALLEY SUBDIVISION	

DEPARTMENT OF PUBLIC WORKS	CIVIL ENGINEERING	701 W. MARKHAM	LITTLE ROCK, ARKANSAS 72201
CL			



DRAWN BY	VH
DESIGNED	DH
CHECKED	DH
DATE	08-23-2021
SCALE	N.T.S.
PROJECT NO.	05-17-DR-208
SHEET NO.	C2


REVISIONS	DATE

CITY OF LITTLE ROCK, ARKANSAS
MADISON VALLEY SUBDIVISION
PLAN - PROFILE
STORM DRAIN PLAN & PROFILE

DEPARTMENT OF PUBLIC WORKS
CIVIL ENGINEERING
701 W. MARKHAM
LITTLE ROCK, ARKANSAS 72201


DRAWN BY
VH
DESIGNED
DH
CHECKED
DH
DATE
08-23-2021
SCALE
1"=10'
PROJECT NO.
05-17-DR-208
SHEET NO.
C3

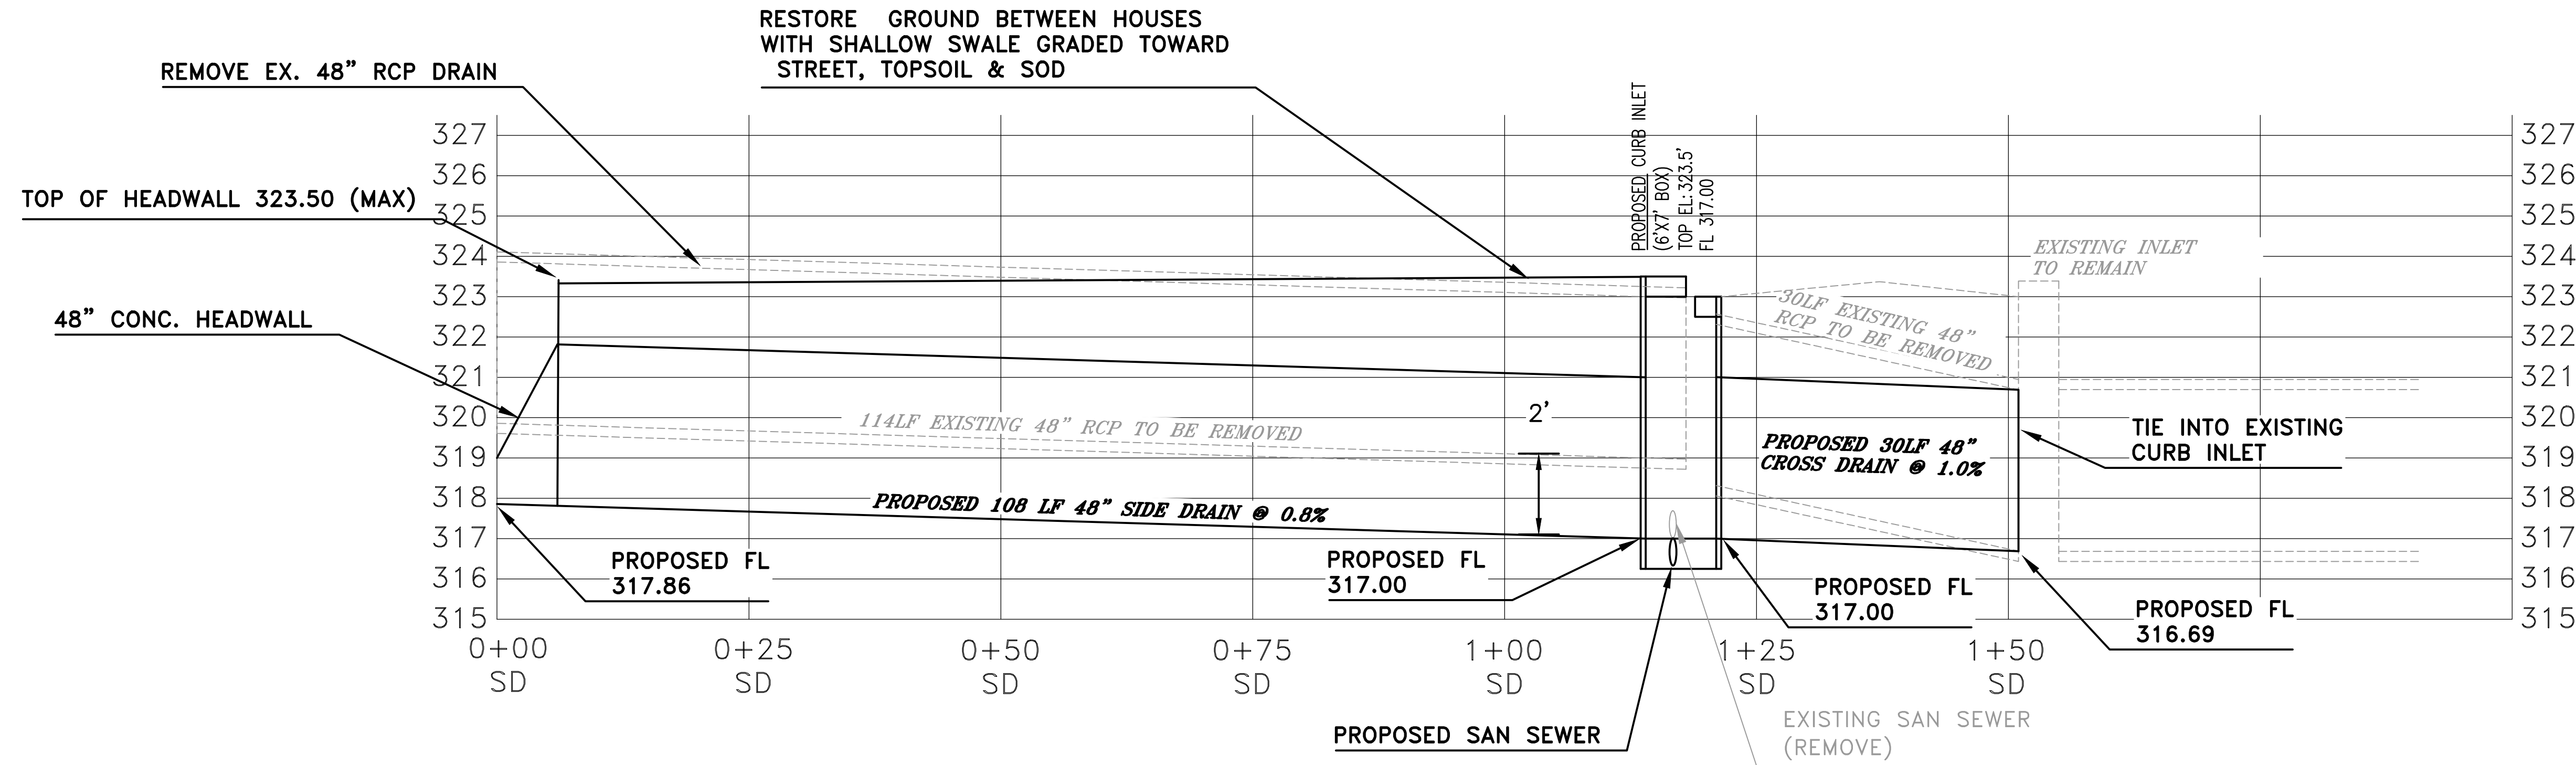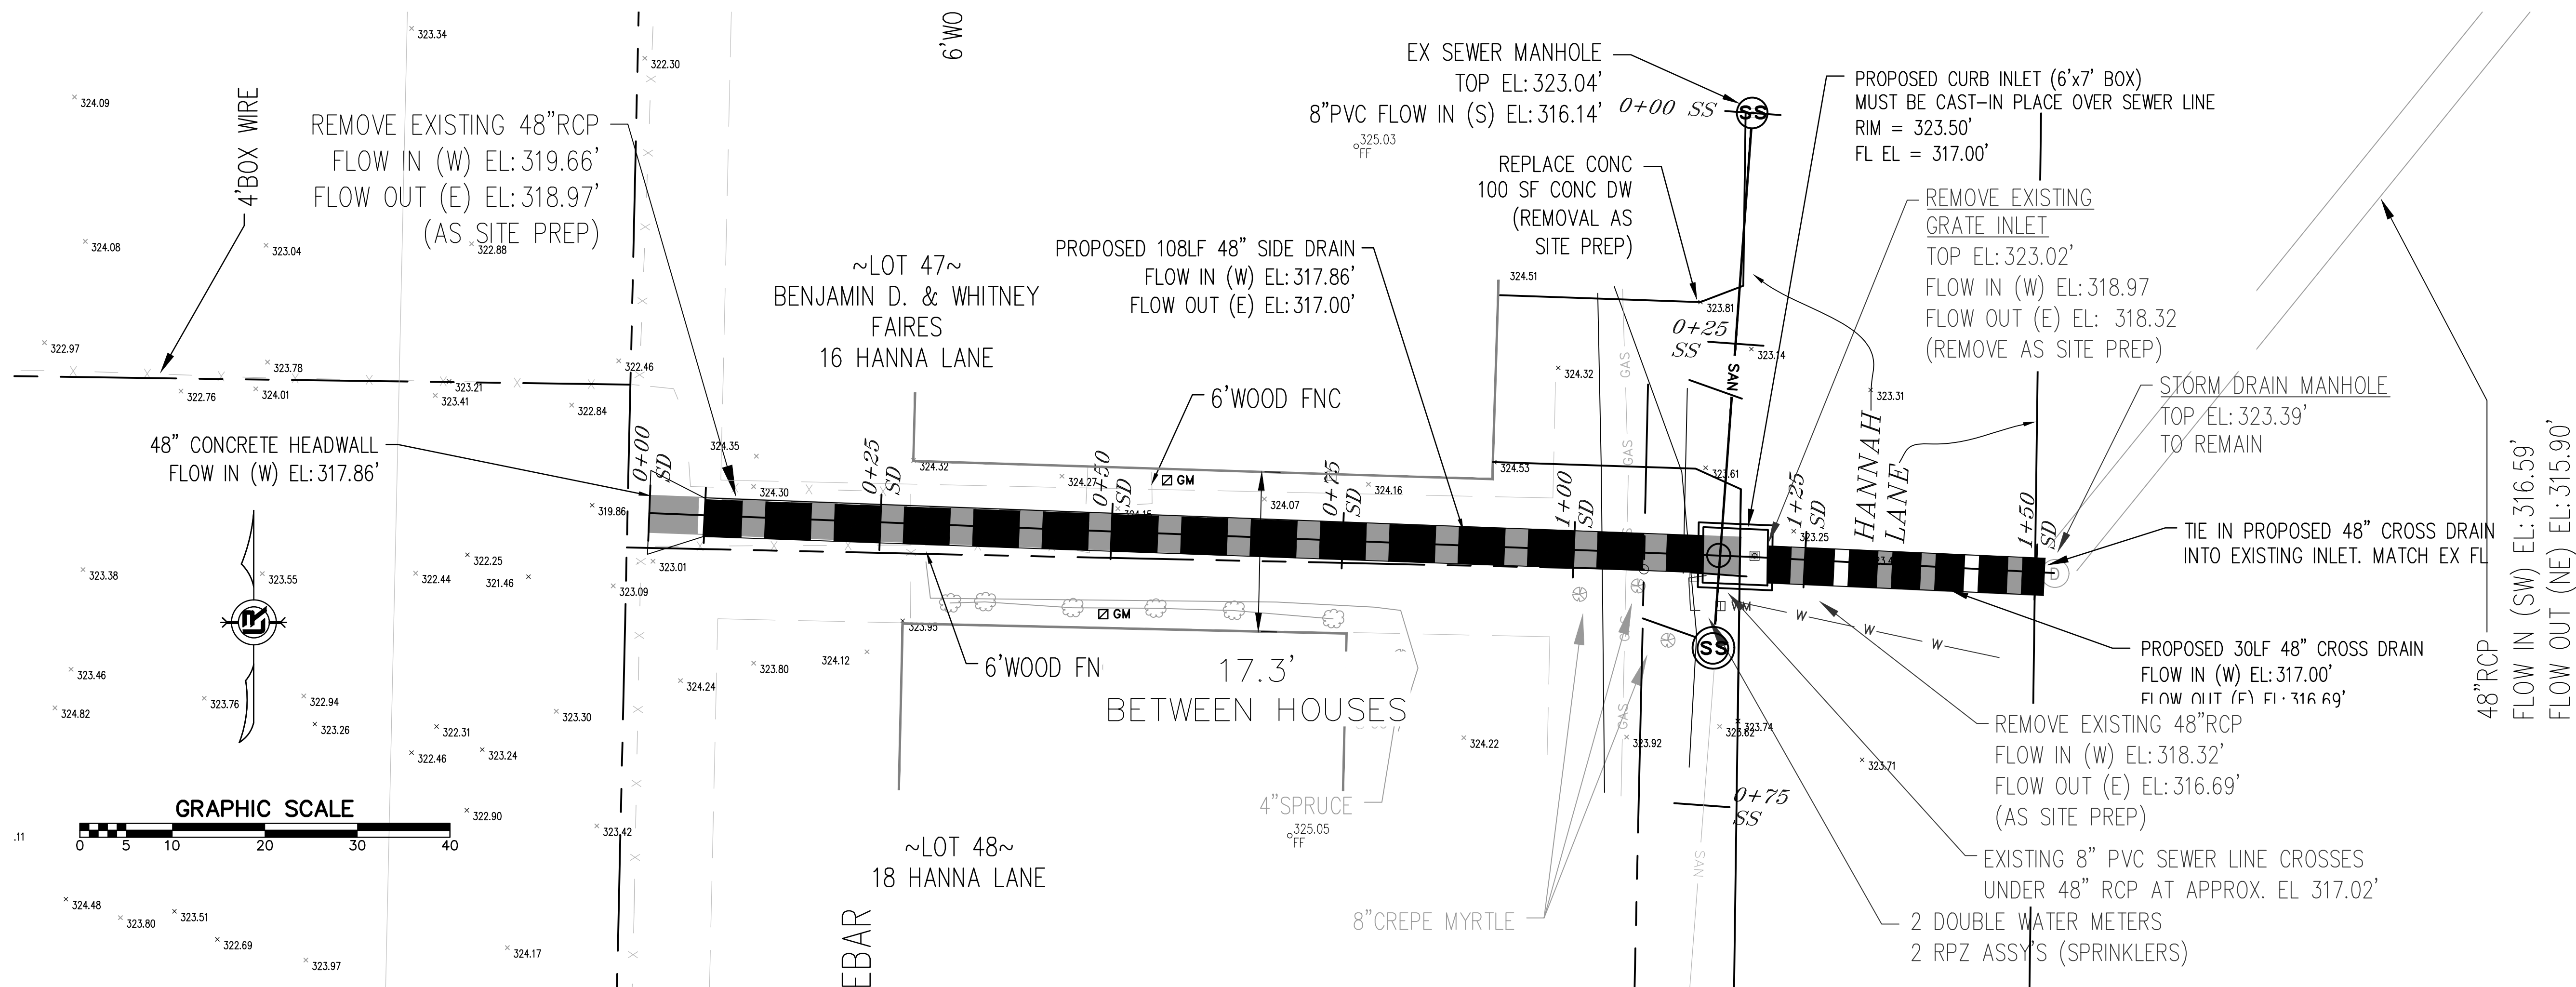

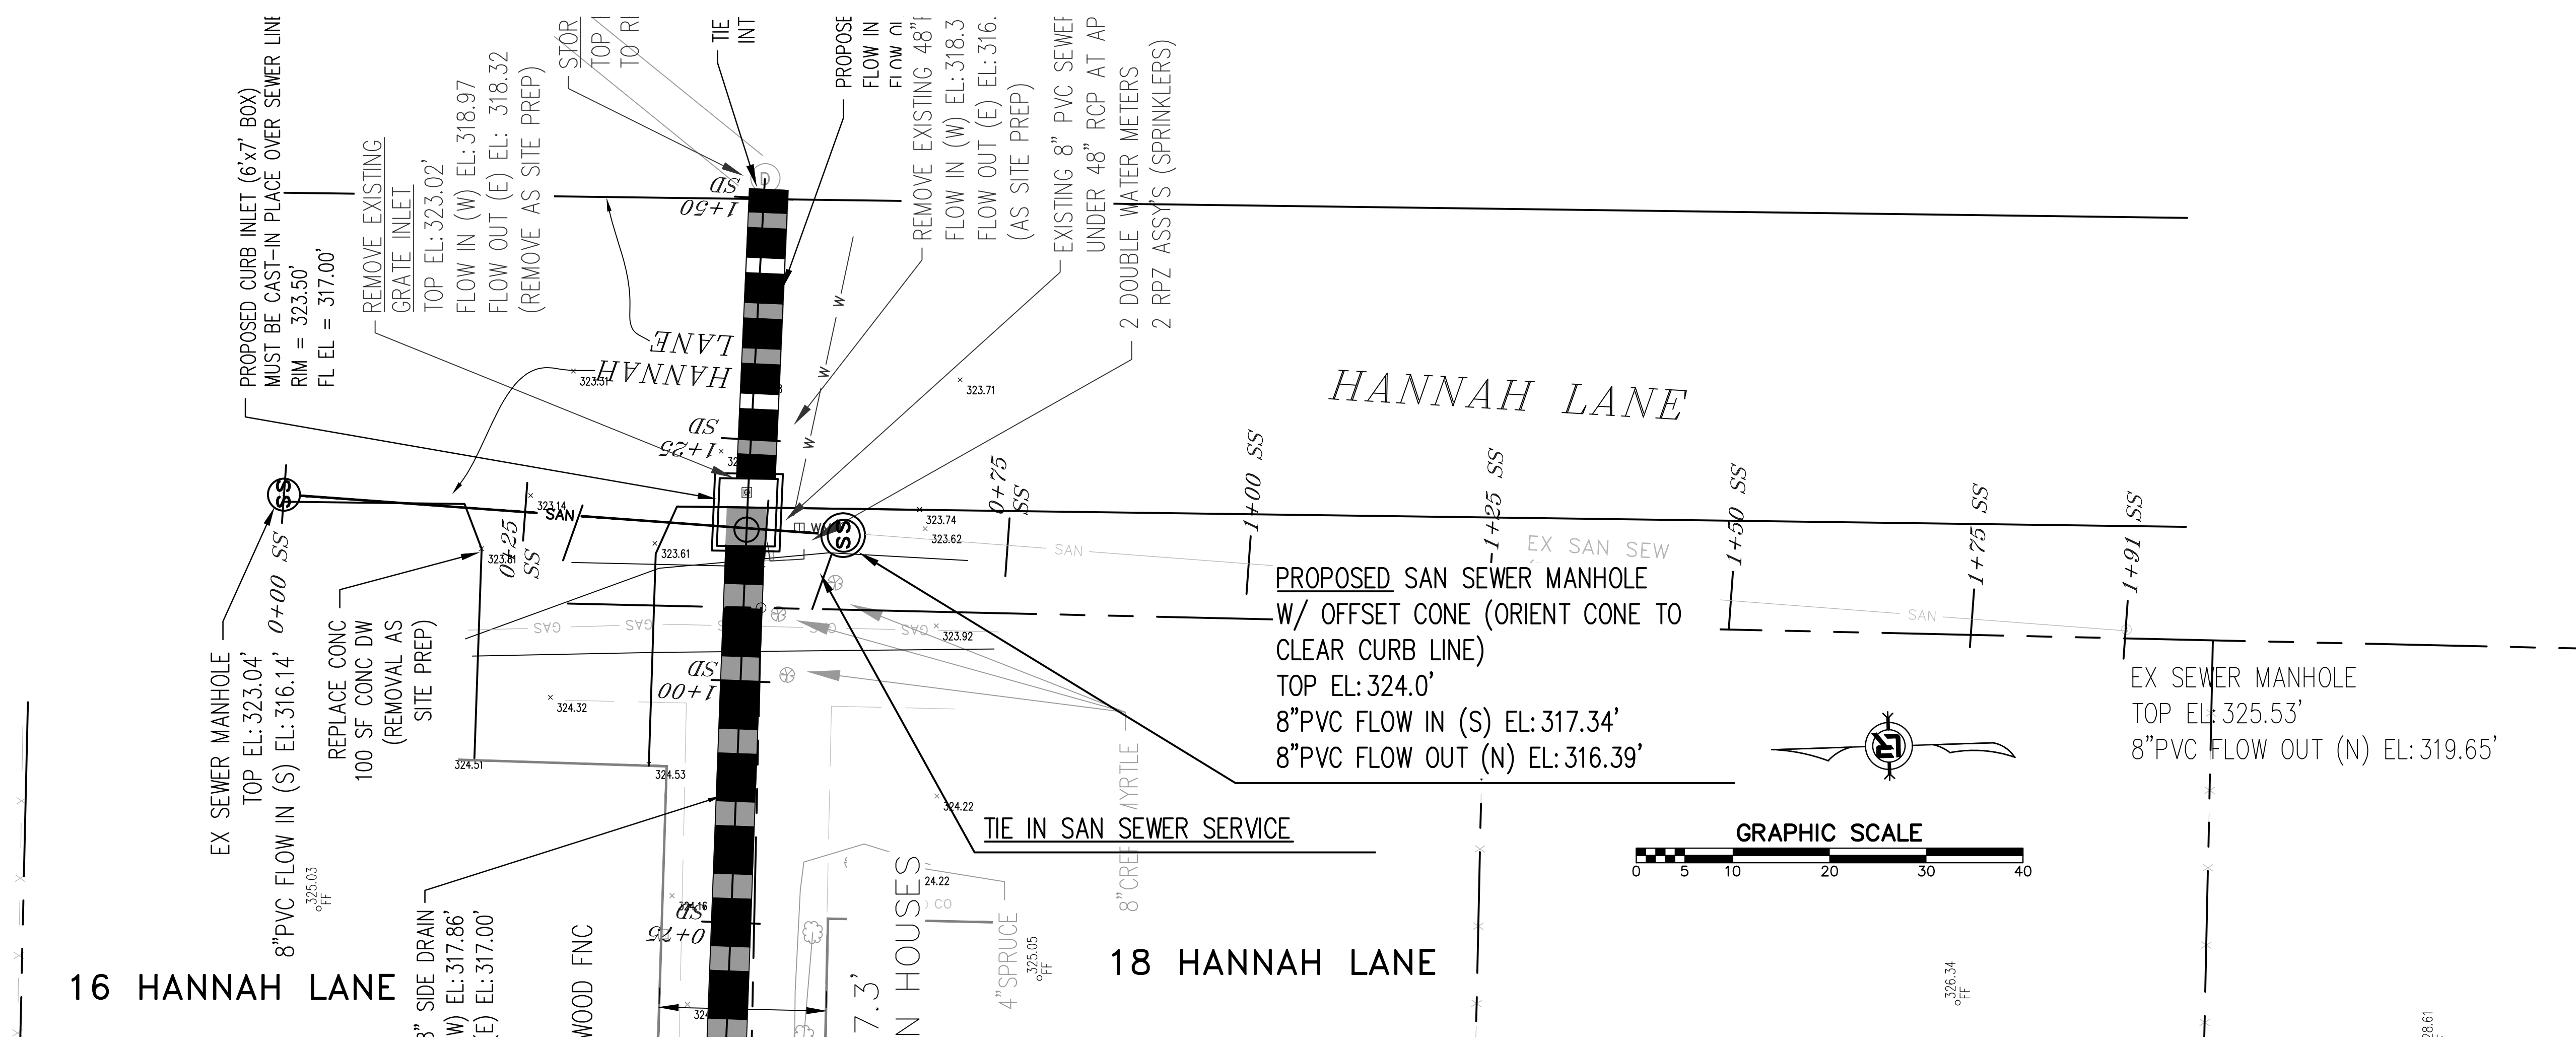

16 HANNAH LANE


18 HANNAH LANE

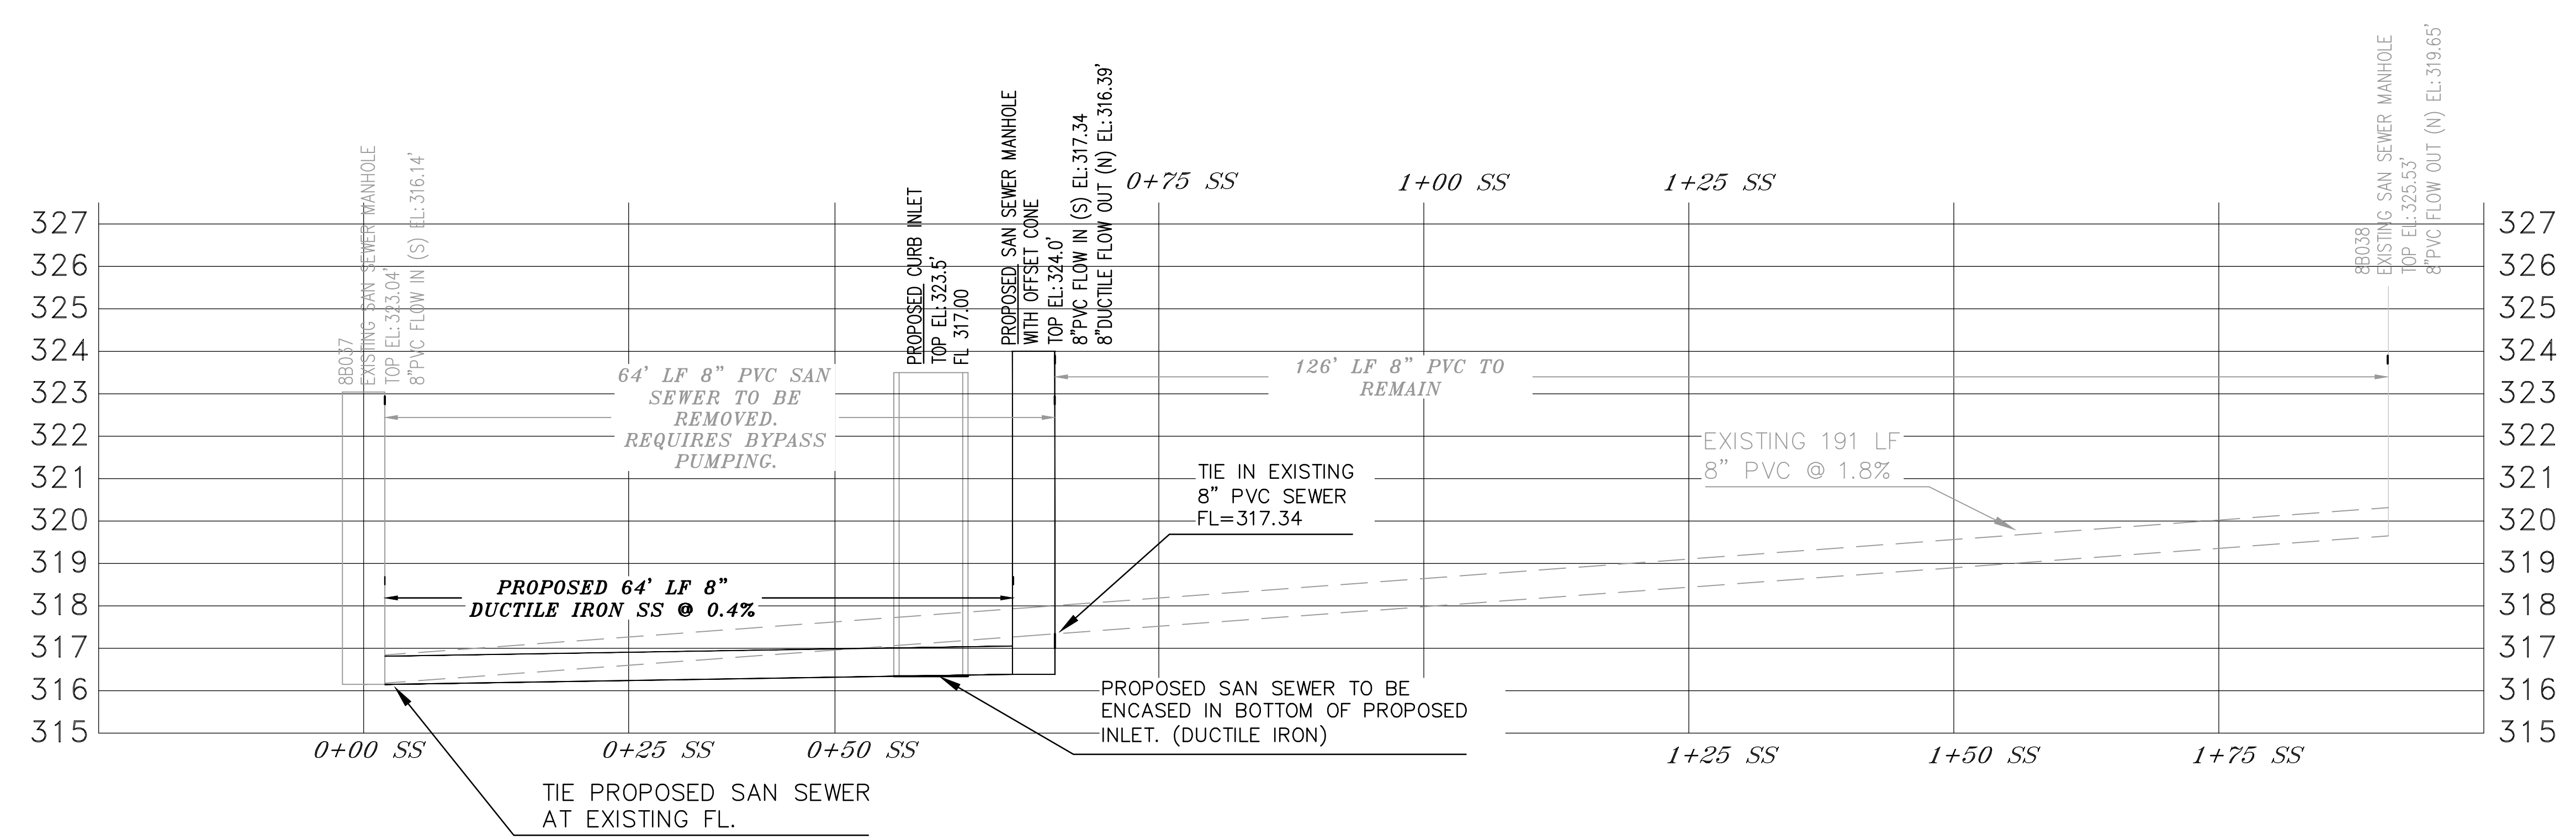

REVISIONS	DATE

CITY OF LITTLE ROCK, ARKANSAS
MADISON VALLEY SUBDIVISION
PLAN - PROFILE
SANITARY SEWER PLAN & PROFILE

DEPARTMENT OF PUBLIC WORKS
CIVIL ENGINEERING
701 W. MARKHAM
LITTLE ROCK, ARKANSAS 72201

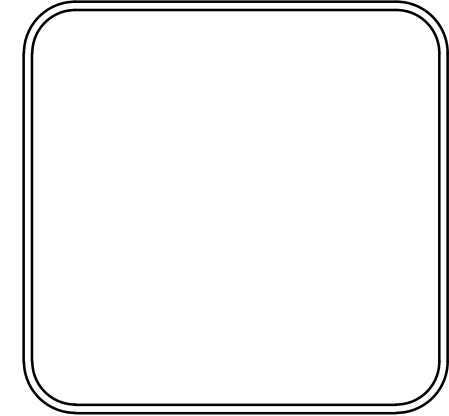

DRAWN BY	VH
DESIGNED	DH
CHECKED	DH
DATE	08-23-2021
SCALE	1"=10'
PROJECT NO.	05-17-DR-208
SHEET NO.	C4