



WALKER STREET DRAINAGE

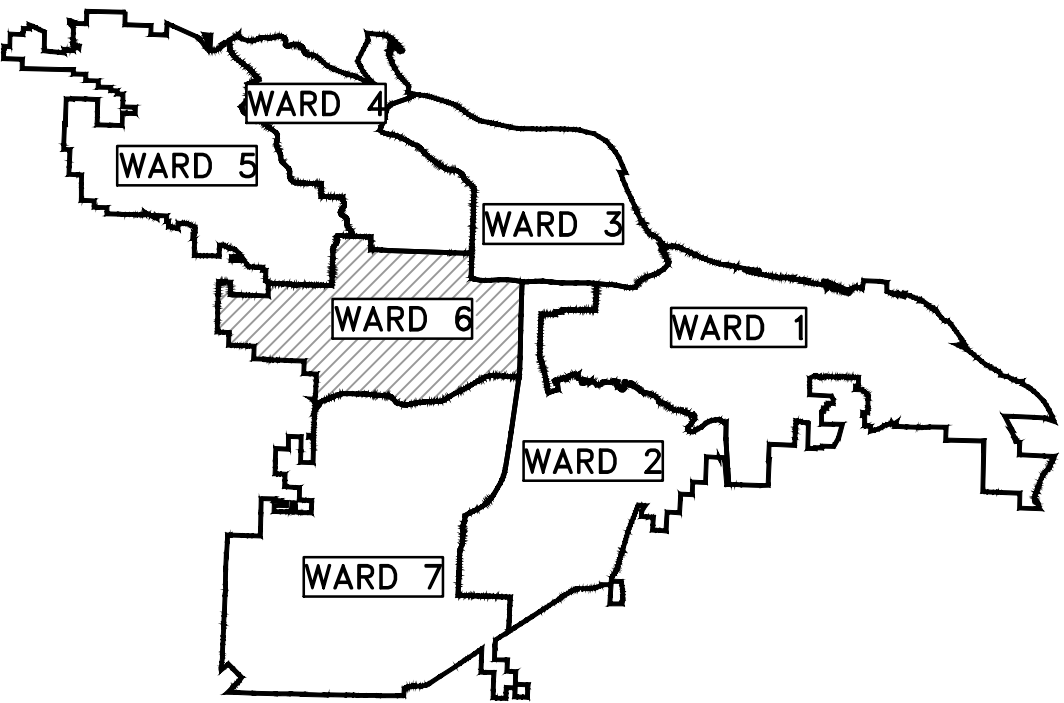

PROJECT LOCATION – WARD 6

SHEET NO.	TITLE
C0	COVER SHEET
C1	GENERAL NOTES, LEGEND AND QUANTITY
C2	EXISTING CONDITION
C3	PLAN AND PROFILE
C4	PLAN AND PROFILE

PROJECT
LOCATION

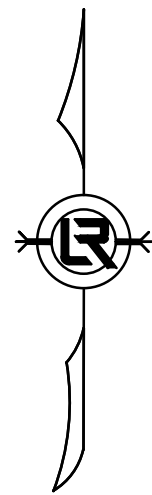

DEPARTMENT OF PUBLIC WORKS
CIVIL ENGINEERING
701 WEST MARKHAM STREET
LITTLE ROCK, ARKANSAS 72201



Know what's below.
Call before you dig.

GNE Designing our client's success
GarNat Engineering, LLC

P.O. Box 116 (72018) Ph (501) 408-4650
3825 Mt Carmel Rd Fx (888) 900-3068
Bryant, AR 72022 garnatengineering@gmail.com

REVISIONS	DATE

CITY OF LITTLE ROCK, ARKANSAS
WALKER STREET DRAINAGE
COVER SHEET
15% SUBMITTAL



DEPARTMENT OF PUBLIC WORKS
CIVIL ENGINEERING
701 W. MARKHAM
LITTLE ROCK, ARKANSAS 72201



PRELIMINARY

DRAWN BY TM
DESIGNED VJW & TM
CHECKED VJW
DATE 09-20-2023
SCALE N.T.S.
PROJECT NO. 23081
SHEET NO. C0

REVISIONS	DATE

**CITY OF LITTLE ROCK, ARKANSAS
WALKER STREET DRAINAGE**

**GENERAL NOTES, LEGEND AND QUANTITY
15% SUBMITTAL**

PRELIMINARY

DRAWN BY
TM
DESIGNED
VJW & TM
CHECKED
VJW
DATE
09-20-2023
SCALE
1"=20' (22X34)
PROJECT NO.
23081
SHEET NO.
C1

Walker Street Drainage - 15% QUANTITIES			
2-Oct-2023			
Item#	Description	Unit	Quantity
2.01	Site Preparation	LS	1
2.02	Clearing and Grubbing	LS	1
	SP Concrete Bridge Removal	LS	1
3.40	Top Soil	CY	50
5.01	Tack Coat	GAL	12
6.10	ACHM Surface Course (Type 2)	TON	30
8.03	Concrete Curb and Gutter (Class 3)	LF	25
10.05	Curb Inlet 5' Box	EA	1
10.07	Wing 3' Extension	EA	1
11.01	Tripple Barrel Reinforced Concrete Precast Box Culvert (4'X6')	LF	32
11.06	Reinfordc Concrete Headwall, Straight Wings and Aprons	CY	20
14.01	Solid Sod, Bermuda	SY	350
16.01	Maintenance of Traffic	LS	1
18.40	1' Thick Grouted Riprap	SY	550
18.55	Water for Dust Control	GAL	5000
19.01	Final cleanup	LS	1
22.10	Mailbox Relocation	EA	2
26.10	Trench excavation & safety	LS	1
24.11	Silt Fence Type A (SFA)	LF	1000
25.06	Chain Link Fence (6')	LF	70
	SP Channel Widening	LS	1
	SP Excavate Earthen Ditch	LF	240

EXISTING		PROPOSED	
IRON ROD	○ IR	CONTOUR	
PK NAIL	○ PK	SPOT ELEVATION	
R.R. SPIKE	□ RR(Sp)	SPOT CURB ELEVATION	
CONC. MONUMENT	□ CM	STORM SEWER – PIPE	
WATER VALVE	⊠ WV	STORM SEWER – MITERED END SECTION	
WATER METER	⊠ WM	STORM SEWER – GRATE INLET	
FIRE HYDRANT	⊠ FH	STORM SEWER – JUNCTION BOX	
GAS METER	⊠ GM	STORM SEWER – FLARED END SECTION	
GAS VALVE	⊠ GV	STORM SEWER – HEADWALL	
CLEAN-OUT	○ CO	STORM SEWER – INLET WITH SINGLE EXTENSION	
GUARD POST (BOLLARD)	● GP	STORM SEWER – INLET WITH DOUBLE EXTENSION	
SIGN POST		STORM SEWER – AREA INLET	
BENCHMARK		GRADE BREAK LINE	
STORM SEWER MANHOLE	⊙ D	HIGH POINT	HP
SANITARY SEWER MANHOLE	⊙ S	LOW POINT	LP
TELEPHONE MANHOLE	⊙ T	CUT LINE	— C —
ELECTRIC MANHOLE	⊙ E	FILL LINE	— F —
TELEPHONE BOX	⊠	SANITARY SEWER PIPE	
ELECTRIC BOX	⊠	SANITARY SEWER MANHOLE	⊙ S
CABLE BOX	⊠	CURB	
UTILITY POLE	⊠	CONCRETE	
GUY WIRE	⊠	CONSTRUCTION – ENTRANCE/EXIT	⊙ CO
LIGHT POLE	⊠	CHECK DAM	⊙ CD
POST OR POLE (TYPE AS NOTED)	⊠	DIVERSION BERM	⊙ DI
MAILBOX	⊠	DOWNDRAIN STRUCTURE – TEMPORARY	⊙ DN
DECIDUOUS TREE		ROCK DAM	⊙ RD
EVERGREEN/CONIFEROUS TREE		SEDIMENT BARRIER – SILT FENCE	⊙ SD1
BUSH		SEDIMENT BARRIER – GRAVEL RING	⊙ SD2
PROPERTY LINE	— — — — —	SEDIMENT BARRIER – BLOCK & GRAVEL	⊙ SD3
SETBACK LINE	— — — — —	SEDIMENT BARRIER – BLOCK	⊙ SD4
EASEMENT LINE	— — — — —	TEMPORARY SEDIMENT BASIN	⊙ SB1
CURB	— — — — —	SILT FENCE – TYPE A	⊙ SFA
FENCE	— X — X —	SILT FENCE – TYPE B	⊙ SFB
OVERHEAD UTILITY	— OHP — OHP —	SILT FENCE – TYPE C	⊙ SFC
UNDERGROUND TELEPHONE	— UGT — UGT — UGT —	STORM DRAIN OUTLET PROTECTION	⊙ ST
UNDERGROUND ELECTRIC	— UGE — UGE — UGE —	SURFACE ROUGHENING	⊙ SU
WATER LINE	— 8" W — 8" W — 8" W —	DISTURBED AREA STABILIZATION –TEMPORARY STABILIZATION	⊙ TS1
SEWER LINE	— SAN —	DISTURBED AREA STABILIZATION –TEMPORARY GRASSING	⊙ TS2
GAS LINE	— GAS — GAS — GAS —	DISTURBED AREA STABILIZATION –PERMANENT GRASSING	⊙ TS3
STORM SEWER/CULVERT	— 24" CMP/RCP/DIP —	MATTING/BLANKETS	⊙ MB
CONTOUR LINE	— 650 —		

REVISIONS	DATE

CITY OF LITTLE ROCK, ARKANSAS
WALKER STREET DRAINAGE
EXISTING CONDITIONS
15% SUBMITTAL

1022 LITTLE ROCK, ARKANSAS 72201

WALKER STREET DRAINAGE


ENGINEERING

CIVIL

DEPARTMENT OF PUBLIC WORKS

PRELIMINARY

DRAWN BY TM	DESIGNED VJW & TM	CHECKED VJW	DATE 09-20-2023	SCALE 1"=20' (22X34)	PROJECT NO. 23081	SHEET NO. C2
----------------	----------------------	----------------	--------------------	-------------------------	----------------------	-----------------

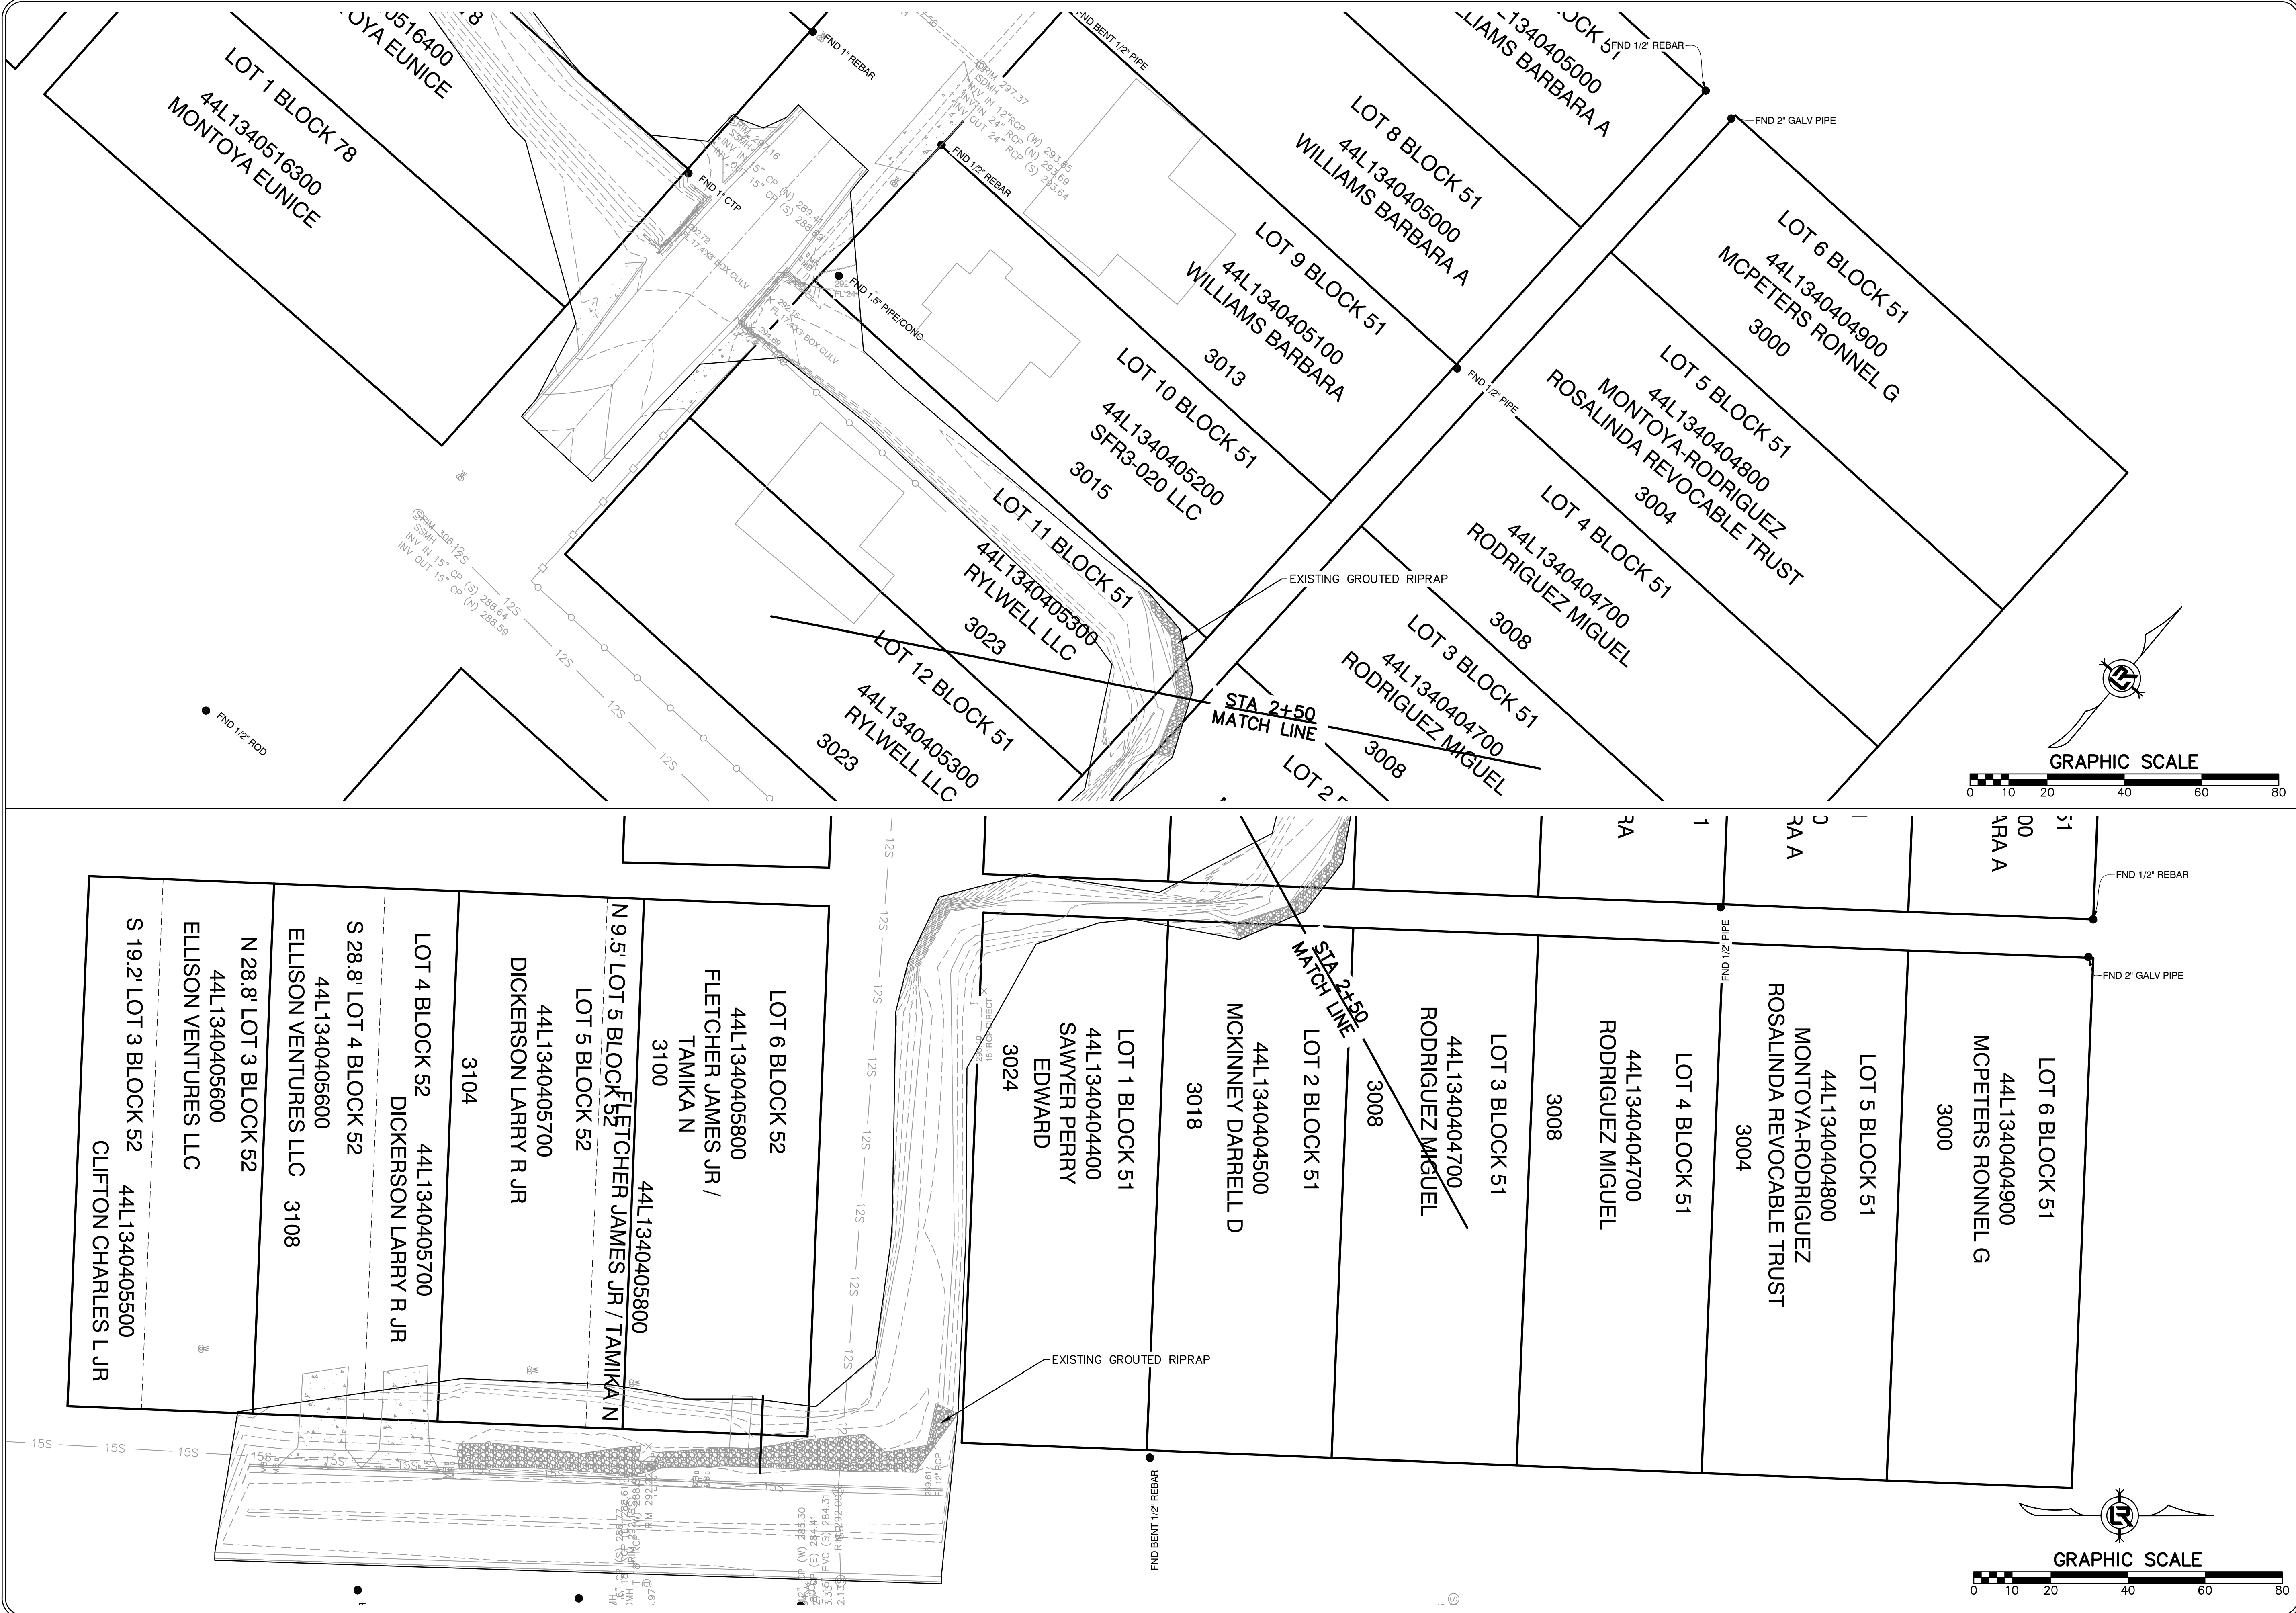

REVISIONS	DATE

7227 SASSANUKA ROCK LITTLE ROCK, AR
CIVIL ENGINEERING
DEPARTMENT OF PUBLIC WORKS

7227 SASSANUKA ROCK LITTLE ROCK, AR
CIVIL ENGINEERING
DEPARTMENT OF PUBLIC WORKS

7227 SASSANUKA ROCK LITTLE ROCK, AR
CIVIL ENGINEERING
DEPARTMENT OF PUBLIC WORKS

7227 SASSANUKA ROCK LITTLE ROCK, AR
CIVIL ENGINEERING
DEPARTMENT OF PUBLIC WORKS

7227 SASSANUKA ROCK LITTLE ROCK, AR
CIVIL ENGINEERING
DEPARTMENT OF PUBLIC WORKS

7227 SASSANUKA ROCK LITTLE ROCK, AR
CIVIL ENGINEERING
DEPARTMENT OF PUBLIC WORKS

7227 SASSANUKA ROCK LITTLE ROCK, AR
CIVIL ENGINEERING
DEPARTMENT OF PUBLIC WORKS





7227 SASSANUKA ROCK LITTLE ROCK, AR
CIVIL ENGINEERING
DEPARTMENT OF PUBLIC WORKS

7227 SASSANUKA ROCK LITTLE ROCK, AR
CIVIL ENGINEERING
DEPARTMENT OF PUBLIC WORKS

7227 SASSANUKA ROCK LITTLE ROCK, AR
CIVIL ENGINEERING
DEPARTMENT OF PUBLIC WORKS

7227 SASSANUKA ROCK LITTLE ROCK, AR
CIVIL ENGINEERING
DEPARTMENT OF PUBLIC WORKS

7227 SASSANUKA ROCK LITTLE ROCK, AR
CIVIL ENGINEERING
DEPARTMENT OF PUBLIC WORKS

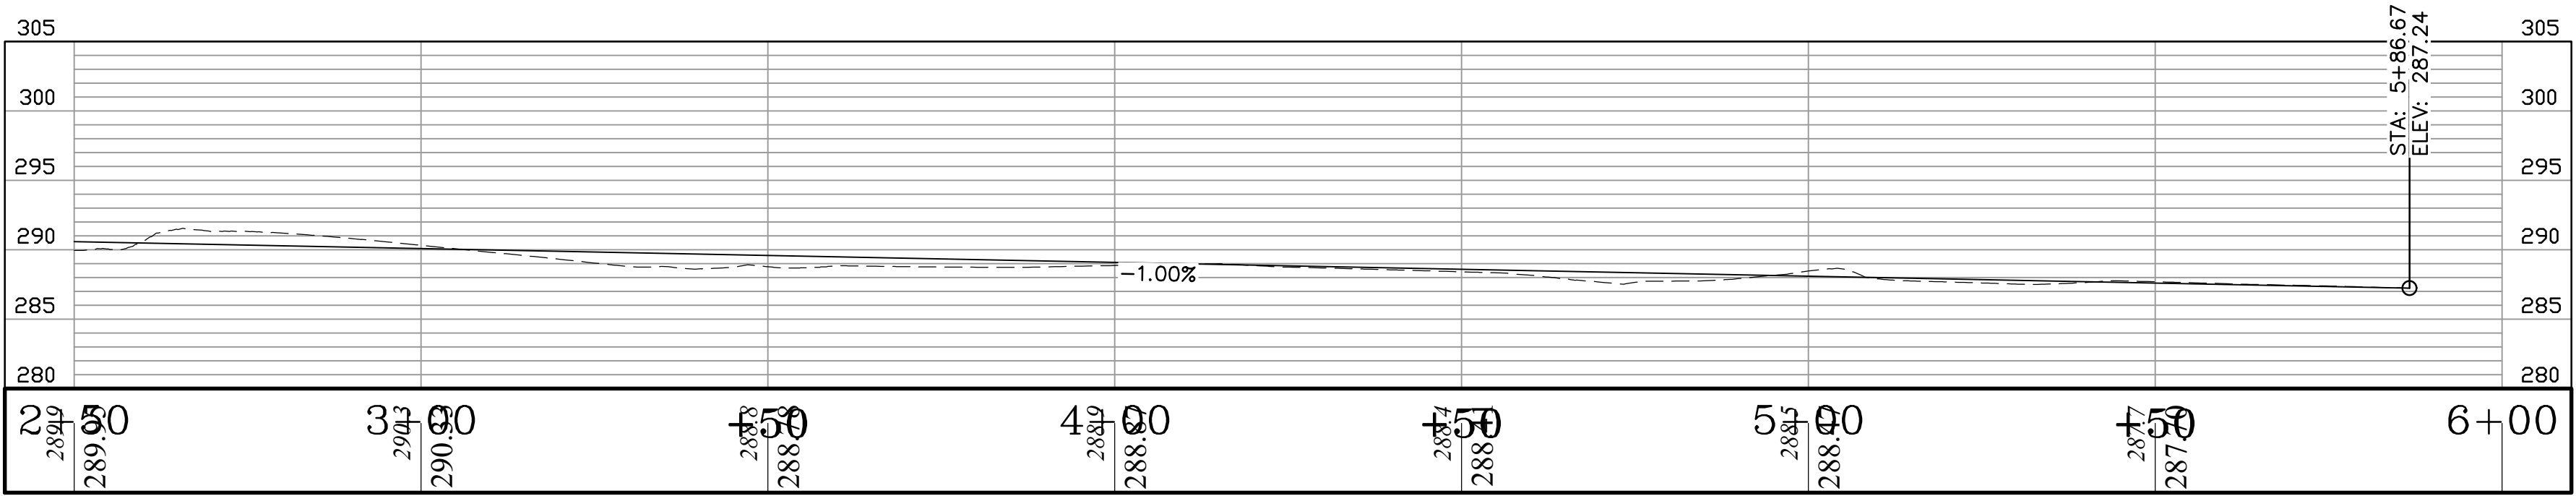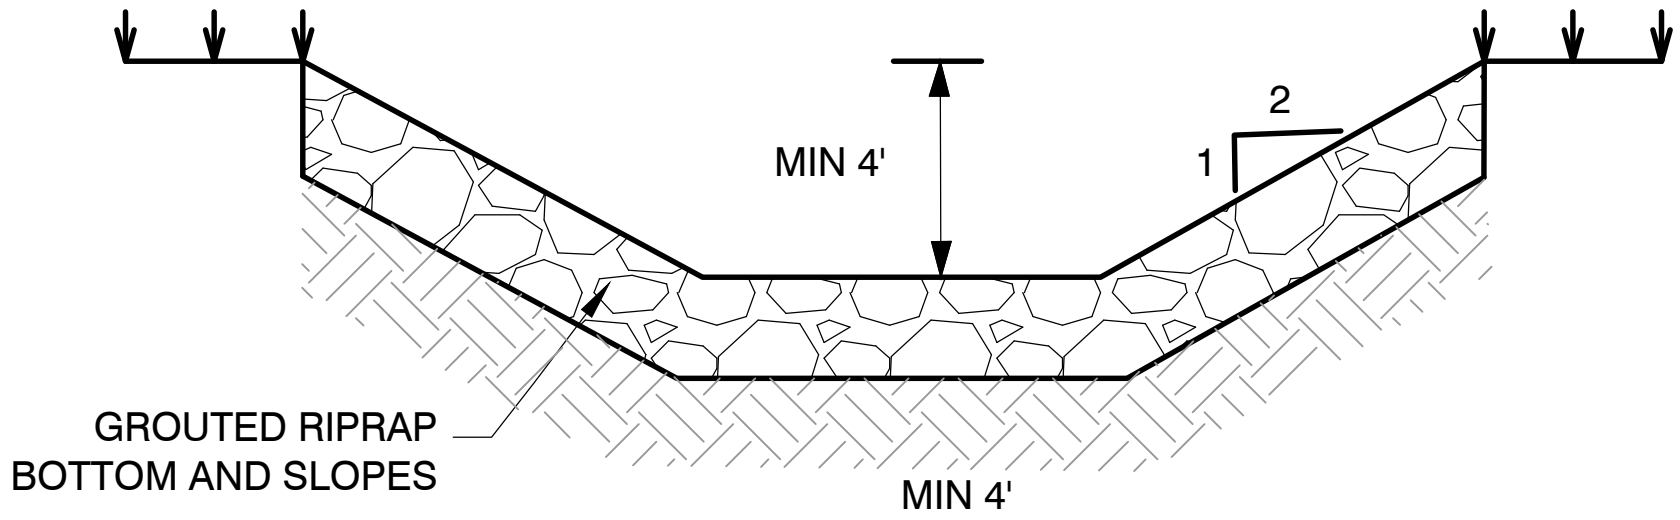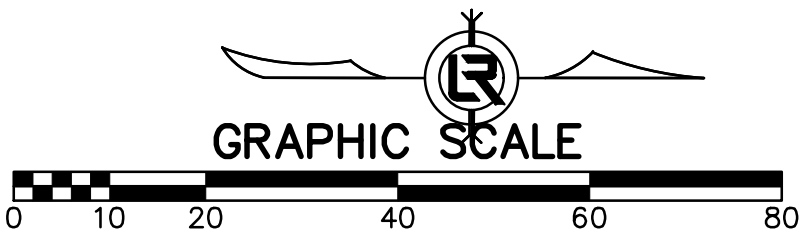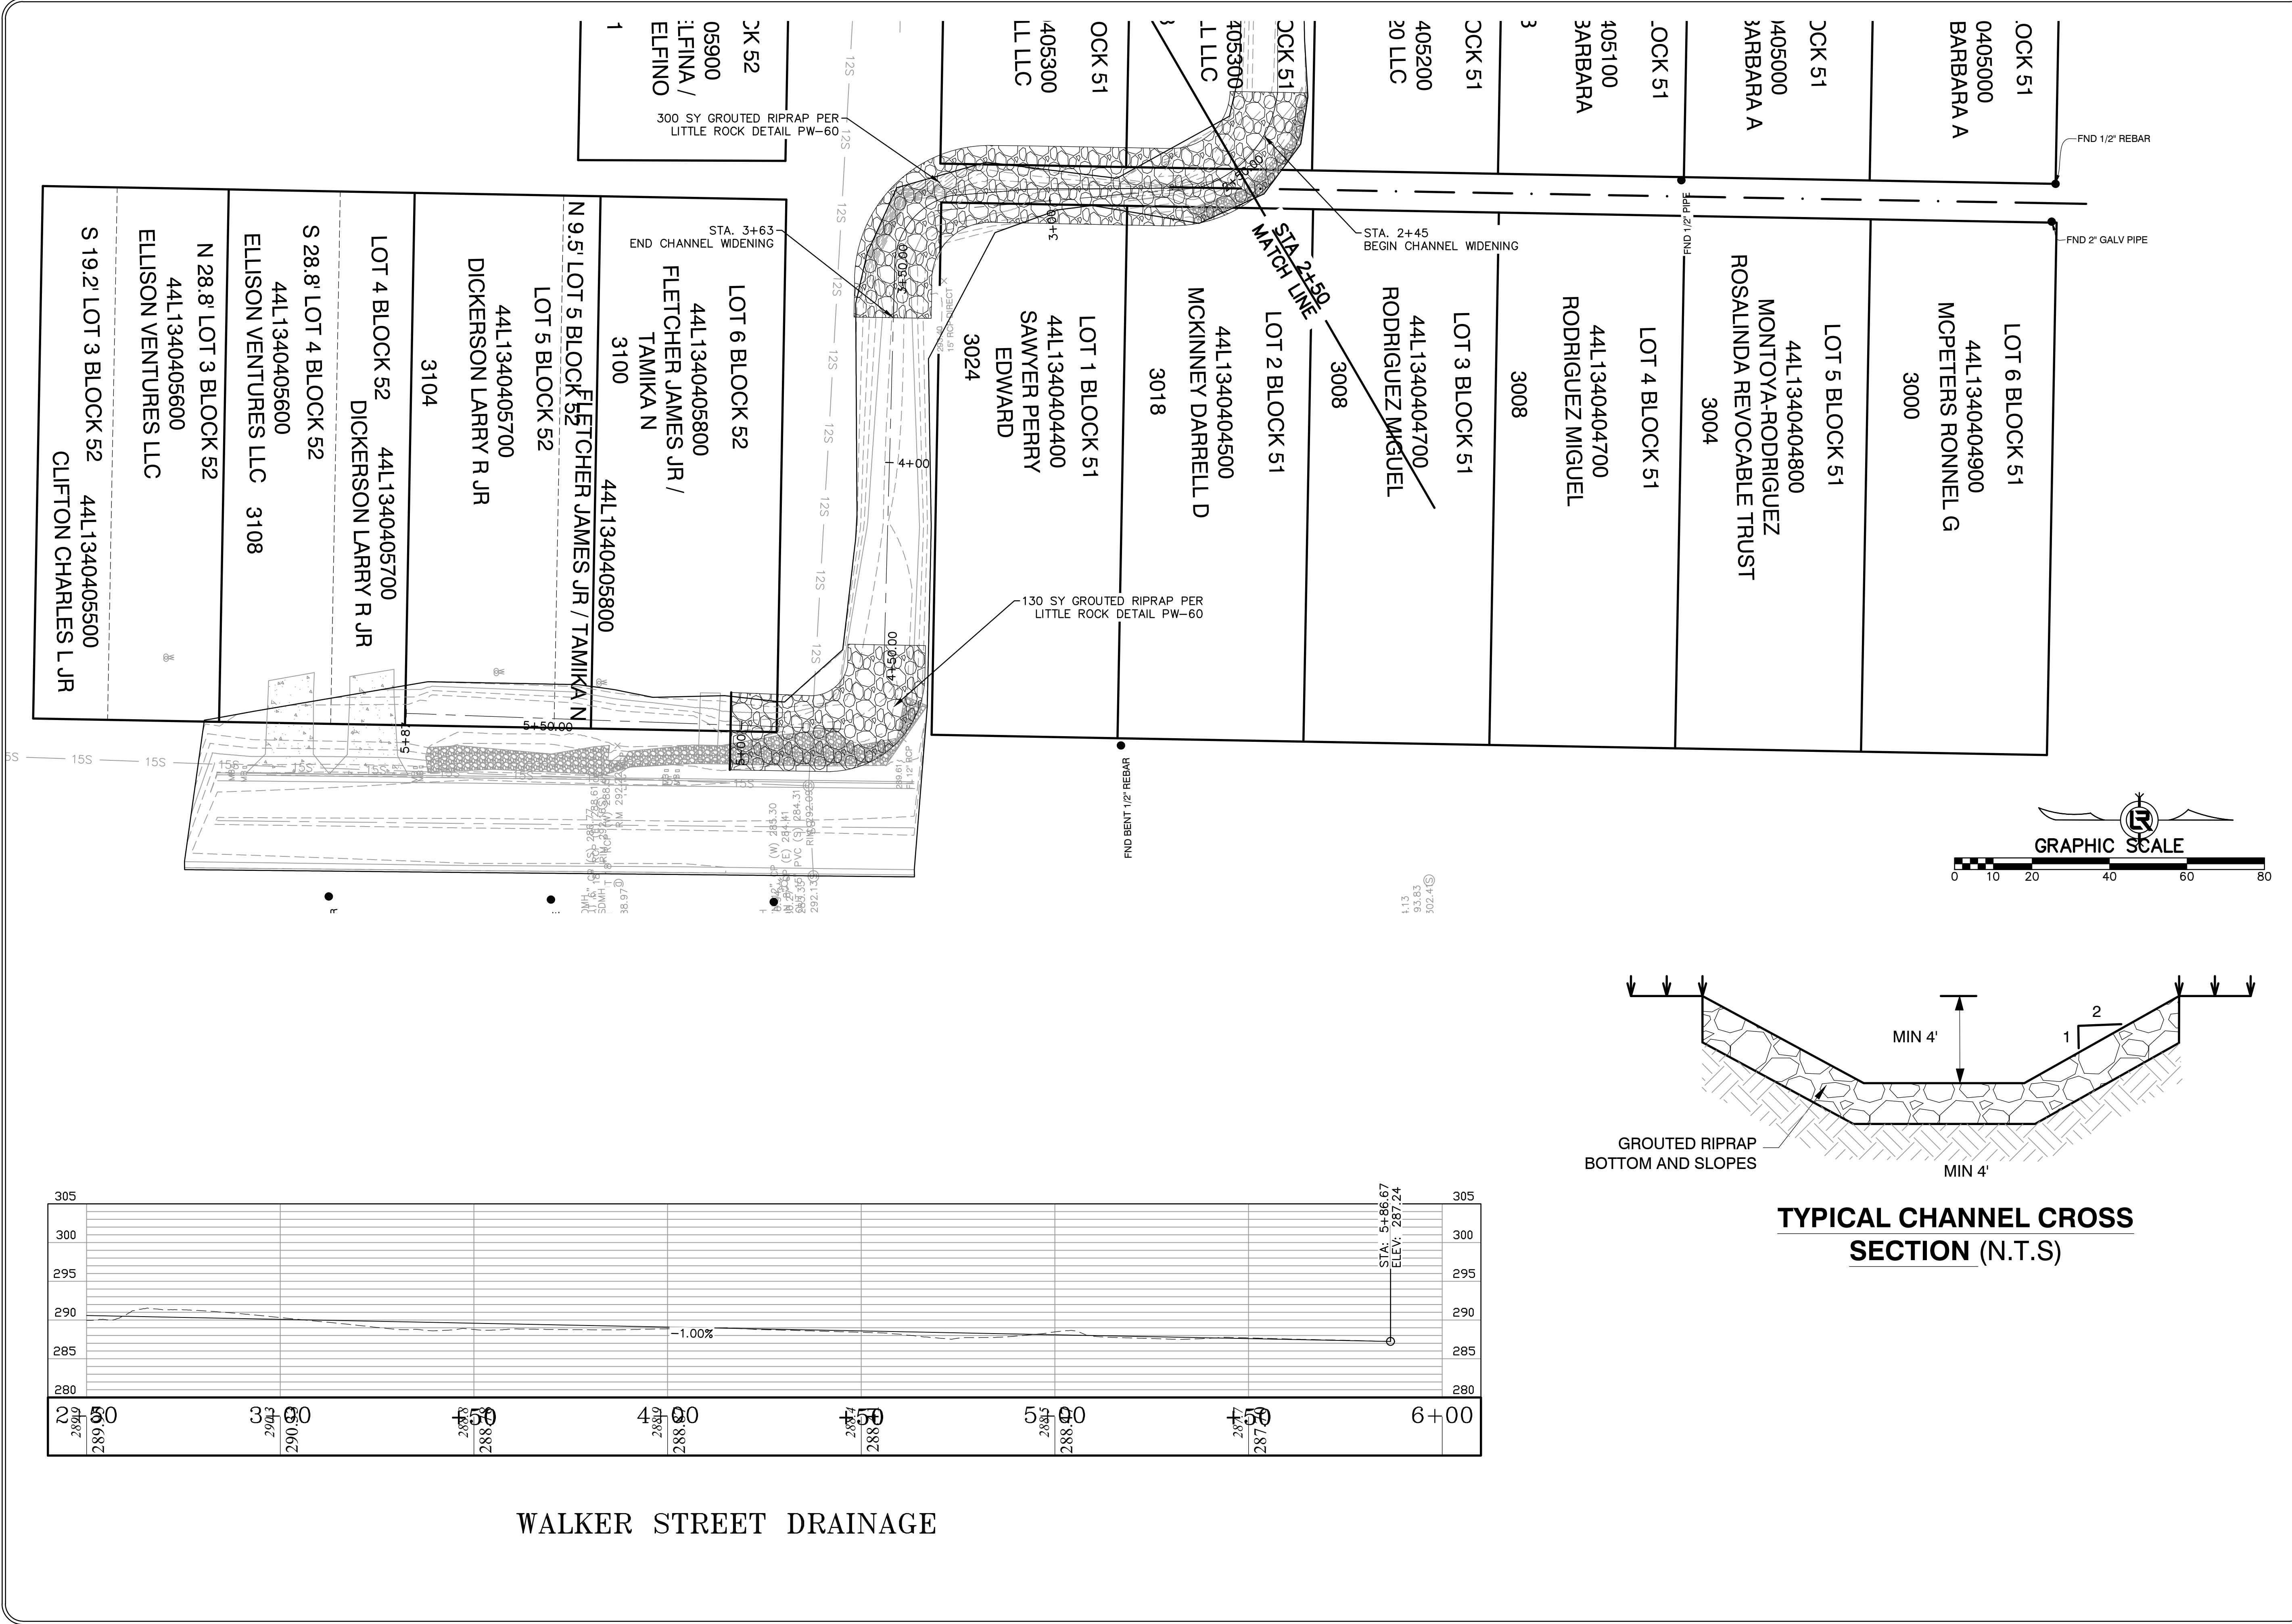

WALKER STREET DRAINAGE