


06-22-DR-213

WEST 35TH STREET



SCALE: 1"=1000'

PROJECT
LOCATION

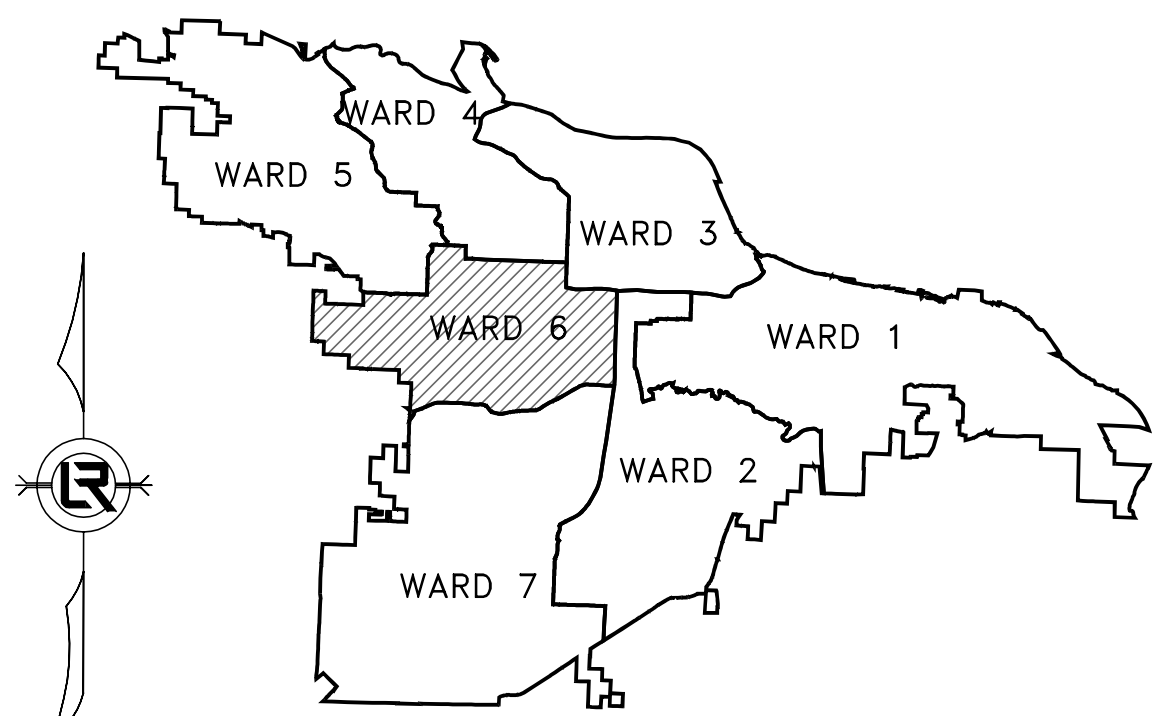

PROJECT LOCATION – WARD 6

SHEET NO.	TITLE
1	COVER SHEET
2	QUANTITIES, LEGEND, AND TYPICAL SECTIONS
3	EXISTING SITE PLAN AND EROSION CONTROL
4	STA 0+00 TO END PLAN AND PROFILE
5	CROSS SECTIONS AND DETAILS
6	SURVEY CONTROL PLAN



Know what's below.
Call before you dig.

HW **HAWKINS WEIR**
ENGINEERS, INC.

110 South 7th Street Van Buren, AR 72956 (479) 474-1227
403 Garrison Avenue Fort Smith, AR 72901 (479) 242-4685
438 Millsap Road, Suite 107 Fayetteville, AR 72703 (479) 455-2206
211 Natural Resources Drive Little Rock, AR 72205 (501) 374-4846




www.hawkins-weir.com

HWEI NO. 2023085

REVISIONS DATE

CITY OF LITTLE ROCK, ARKANSAS
WEST 35TH STREET
COVER SHEET

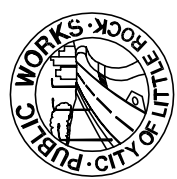

DEPARTMENT OF PUBLIC WORKS
CIVIL ENGINEERING
701 W. MARKHAM
LITTLE ROCK, ARKANSAS 72201



DRAWN BY

BAP
DESIGNED
BAP
CHECKED

JKS

DATE

JULY 2024

SCALE

N.T.S.

PROJECT NO.


06-22-DR-213

SHEET NO.


1

Z:\3\2023085 2023 STREET & DRAINAGE + 2022-2025 BAND PROGRAM - CITY OF LITTLE ROCK W 35TH STREET\02 DETAIL.DWG, 9/15/2024 2:53 PM, JOSH NICHOLS, LAYOUT

ITEM NO.	DESCRIPTION	QUANTITY AND UNIT
1	2.01 SITE PREPARATION (INCLUDING MOBILIZATION)	1 LS
2	3.01 UNCLASSIFIED EXCAVATION	100 CY
3	3.06 BORROW MATERIAL	100 CY
4	4.01 AGGREGATE BASE COURSE (CLASS 7)	50 CY
5	5.01 TACK COAT	90 GAL
6	6.01 ASPHALT SURFACE COURSE	65 TON
7	7.04 CONCRETE DRIVE (PRIVATE 6")	50 SY
8	8.01 CONCRETE CURB & GUTTER	285 LF
9	10.06 TYPE S CURB INLET (4' x 4')	3 EA
10	10.063 3' EXTENSION	3 EA
11	13.18 STORM DRAIN PIPES, 15" SIDE DRAIN	225 LF
12	14.01 SOLID SODDING (BERMUDA) MAINTENANCE OF TRAFFIC AND TRAFFIC CONTROL	300 SY 1 LS
13	16.01	
14	18.1 WATER FOR DUST CONTROL	10000 GAL
15	19.01 FINAL CLEAN-UP	1 LS
16	24.06 SEDIMENT BARRIER, SILT FENCE (SD1)	3 EA
17	24.09 SEDIMENT BARRIER, BLOCK (SD4)	3 EA
18	24.11 SILT FENCE - TYPE A (SFA) DISTURBED AREA STABILIZATION -	300 LF
19	24.16 TEMPORARY STABILIZATION (TS1)	0.1 AC
20	26.01 TRENCH AND EXCAVATION SAFETY SYSTEM	1 LS
21	27.07 COLD MILLING ASPHALT PAVEMENT	100 SY
22	SP.1 TIE INTO EXISTING DRAINAGE INLET	1 EA
23	SP.2 AS BUILT SURVEY	1 LS

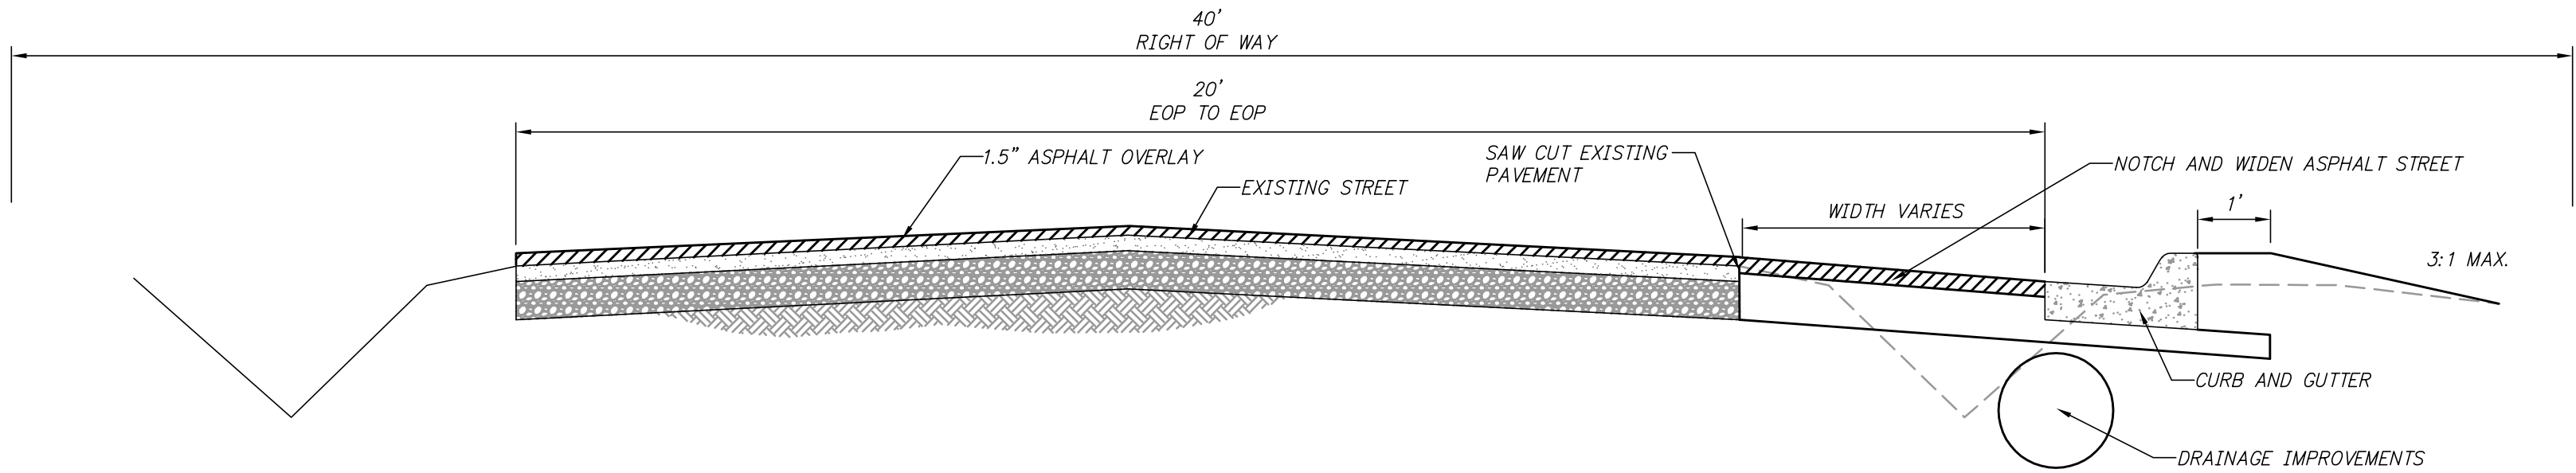

WEST 35TH STREET
WIDENING DETAIL
DETAIL A
N.T.S.

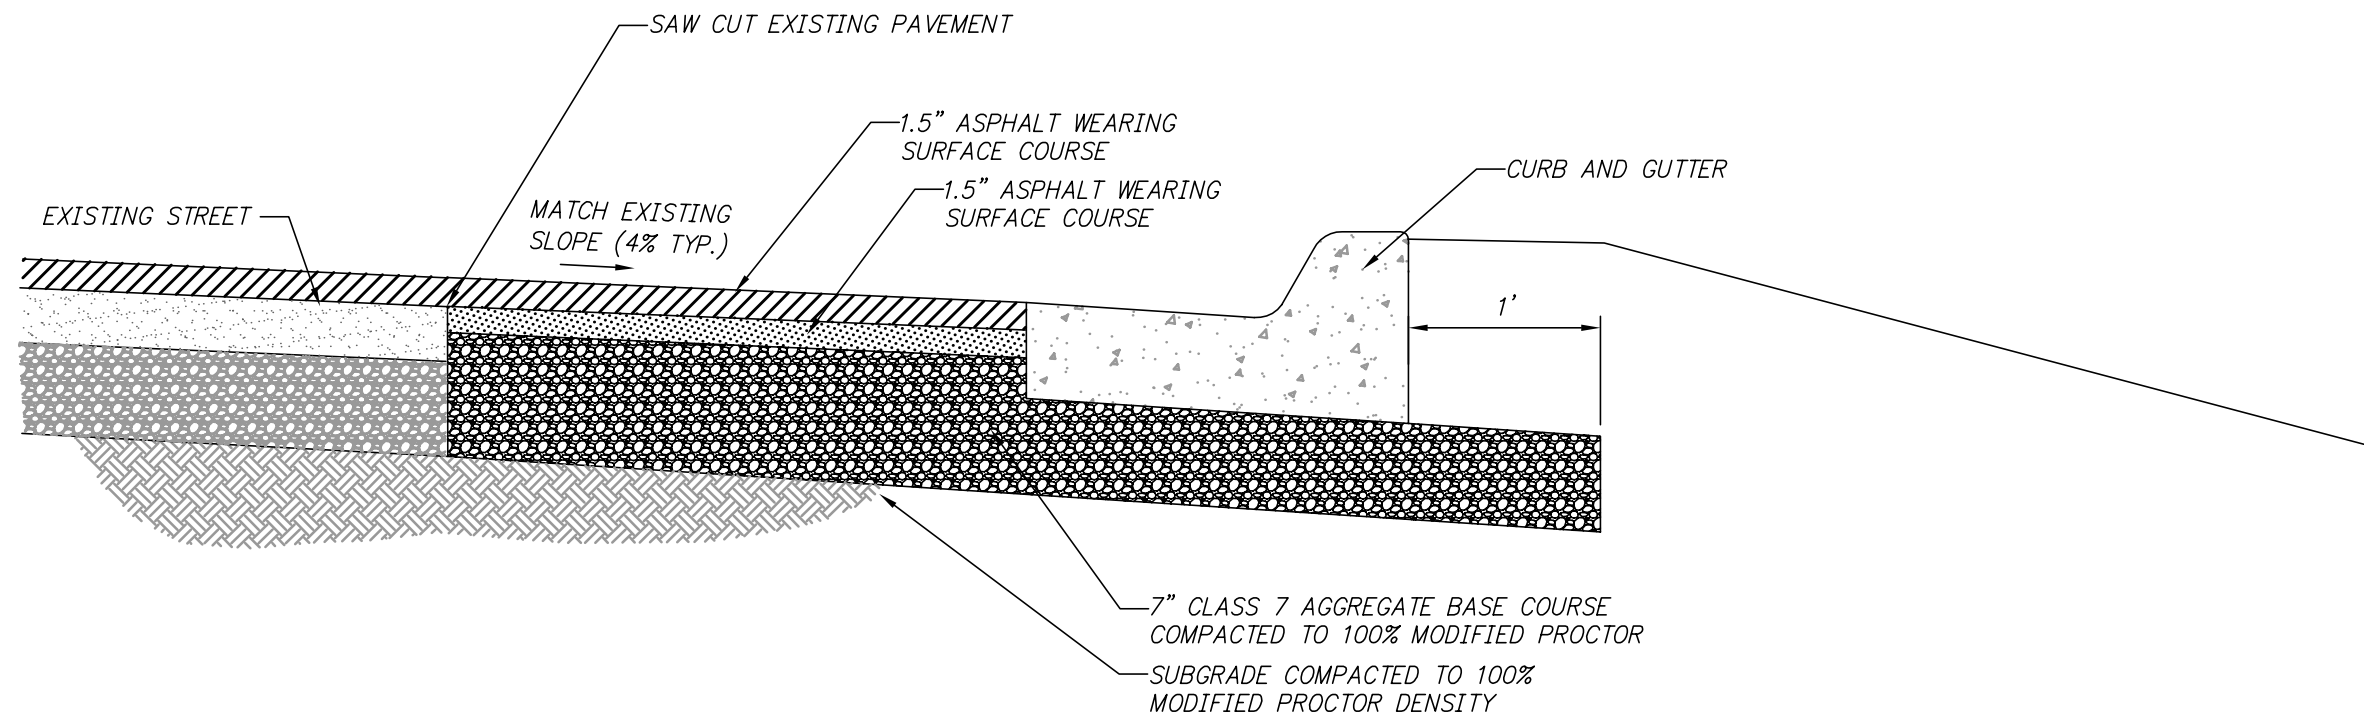

NOTCH AND WIDENING
TYPICAL CURB AND GUTTER STREET
DETAIL B
N.T.S.

LEGEND

IPF	IRON PIN FOUND
SIP	SET IRON PIN
SRIP	SET REFERENCE IRON PIN
GM	GAS METER
MH	MANHOLE
DI	DROP INLET
JB	JUNCTION BOX
SG	SIGN
TR	TELEPHONE RISER
TVR	TELEVISION RISER
ER	ELECTRICAL RISER
PP	POWER POLE
*	LIGHT POLE
◇	FIRE HYDRANT
OWM	WATER METER
WV	WATER VALVE
MB	MAIL BOX
G	GAS LINE
SS	SANITARY SEWER
W	WATER LINE
OHE	OVERHEAD ELECTRIC
OHT	OVERHEAD TELEPHONE
OHE&T	OVERHEAD ELECTRIC & TELEPHONE
UGE	UNDERGROUND ELECTRIC
UGT	UNDERGROUND TELEPHONE
450	CONTOUR LINE
x-x-x-x	FENCE
644	CONTOUR
627.10FG	SPOT ELEVATION
PIPE	STORM SEWER - PIPE
MITERED	STORM SEWER - MITERED END SECTION
GRATE	STORM SEWER - GRATE INLET
JUNCTION	STORM SEWER - JUNCTION BOX
FLARED	STORM SEWER - FLARED END SECTION
HEADWALL	STORM SEWER - HEADWALL
INLET SINGLE	STORM SEWER - INLET WITH SINGLE EXTENSION
INLET DOUBLE	STORM SEWER - INLET WITH DOUBLE EXTENSION
AREA	STORM SEWER - AREA INLET
CO	CONSTRUCTION - ENTRANCE/EXIT
CD	CHECK DAM
DI	DIVERSION BERM
DN	DOWNDRAIN STRUCTURE - TEMPORARY
RD	ROCK DAM
SD1	SEDIMENT BARRIER - SILT FENCE
SD2	SEDIMENT BARRIER - GRAVEL RING
SD3	SEDIMENT BARRIER - BLOCK & GRAVEL
SD4	SEDIMENT BARRIER - BLOCK
SB1	TEMPORARY SEDIMENT BASIN
SFA	SILT FENCE - TYPE A
SFB	SILT FENCE - TYPE B
SFC	SILT FENCE - TYPE C
ST	STORM DRAIN OUTLET PROTECTION
SU	SURFACE ROUGHENING
TS1	DISTURBED AREA STABILIZATION -TEMPORARY STABILIZATION
TS2	DISTURBED AREA STABILIZATION -TEMPORARY GRASSING
TS3	DISTURBED AREA STABILIZATION -PERMANENT GRASSING
Mb	MATTING/BLANKETS

CONSTRUCTION NOTES

- FIELD DENSITY TESTS ARE REQUIRED TO VERIFY COMPACTION. WHEN THE TESTS INDICATE THAT THE DENSITY OF ANY AREA OR LIFT IS BELOW THE REQUIRED DENSITY OR BEYOND THE SPECIFIED MOISTURE CONTENTS, THE FAILING PORTION SHOULD BE REWORKED AND TESTED UNTIL THE RESULTS ARE WITHIN THE SPECIFICATIONS.
- PRIOR TO INSTALLING THE BASE COURSE THE CONTRACTOR SHALL PROOF-ROLL THE SUBGRADE. ANY SOFT AND YIELDING AREAS SHALL BE REMOVED AND REPAIRED PER THE SPECIFICATIONS. PROOF-ROLLING SHOULD BE ACCOMPLISHED WITH A LOADED DUMP TRUCK EXERTING A MINIMUM OF 10,000 LBS. PER AXLE.
- ALL DISTURBED AREAS SHALL BE RESTORED WITH 4-INCH TOPSOIL AND SOLID SOD.

REVISIONS DATE

CITY OF LITTLE ROCK, ARKANSAS

WEST 35TH STREET

QUANTITIES, LEGEND,
AND TYPICAL SECTIONS

DEPARTMENT OF PUBLIC WORKS

CIVIL ENGINEERING

701 W. MARKHAM

LITTLE ROCK, ARKANSAS 72201



DRAWN BY
BAP
DESIGNED
BAP
CHECKED
JKS

DATE
JULY 2024
SCALE
NTS

PROJECT NO.
06-22-DR-213
SHEET NO.


2

REVISIONS	DATE

CITY OF LITTLE ROCK, ARKANSAS

WEST 35TH STREET

EXISTING SITE PLAN AND EROSION CONTROL PLAN

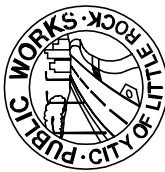


DEPARTMENT OF PUBLIC WORKS

CIVIL ENGINEERING

701 W. MARKHAM

LITTLE ROCK, ARKANSAS 72201


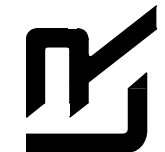


DRAWN BY	BAP
DESIGNED	BAP
CHECKED	JKS


DATE	JULY 2024
------	-----------

SCALE

PROJECT NO.	06-22-DR-213
SHEET NO.	

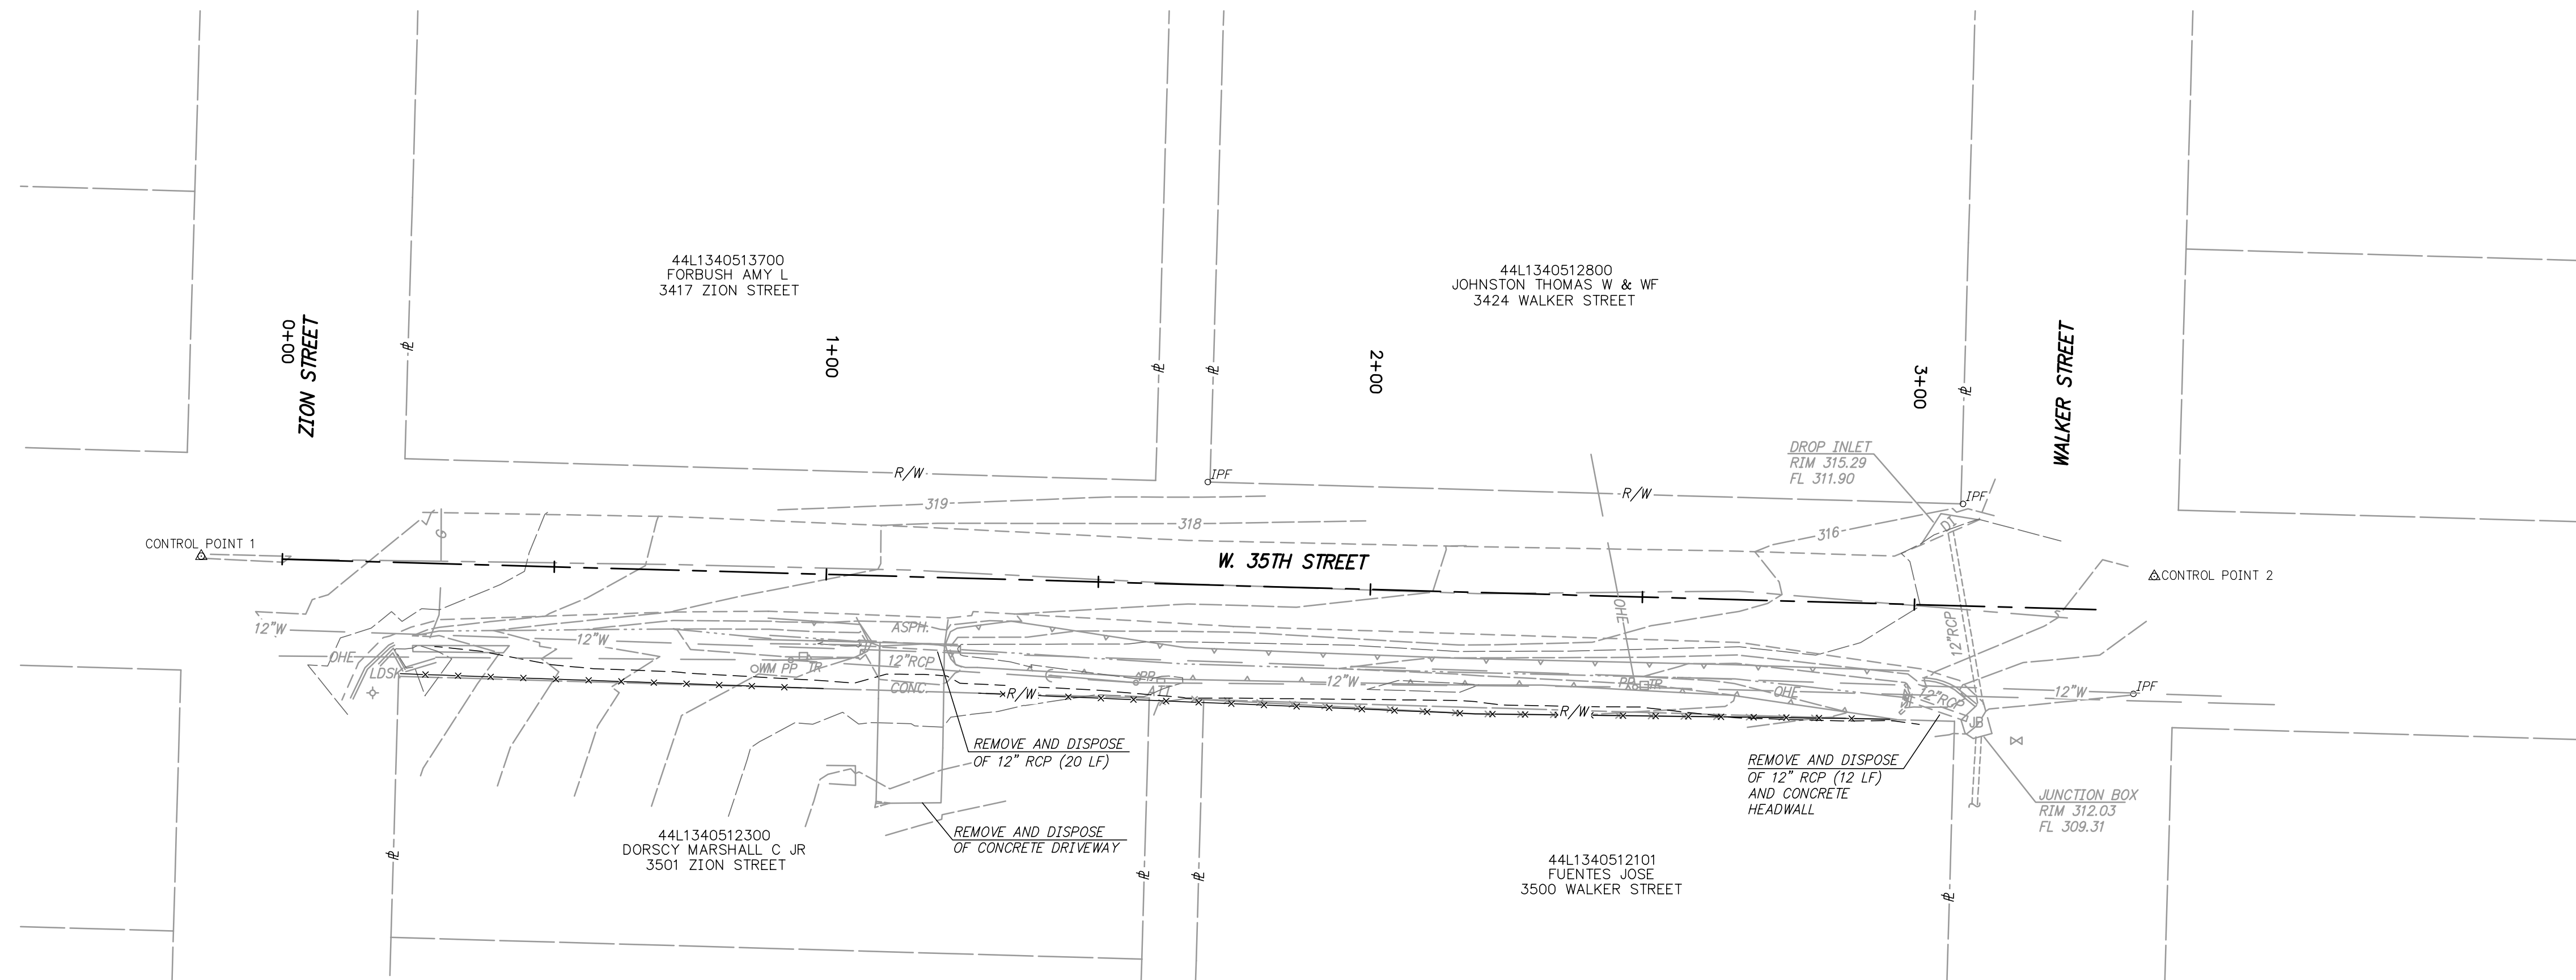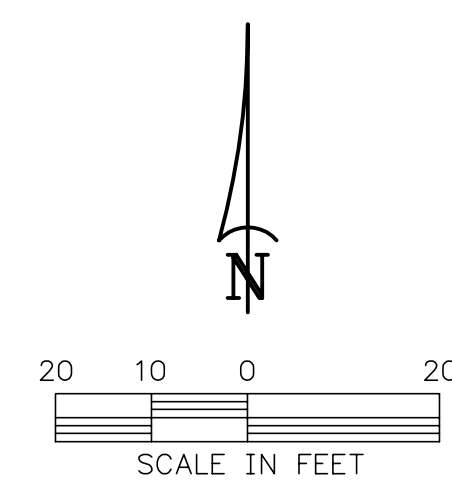


EXISTING SITE PLAN
1"=20'

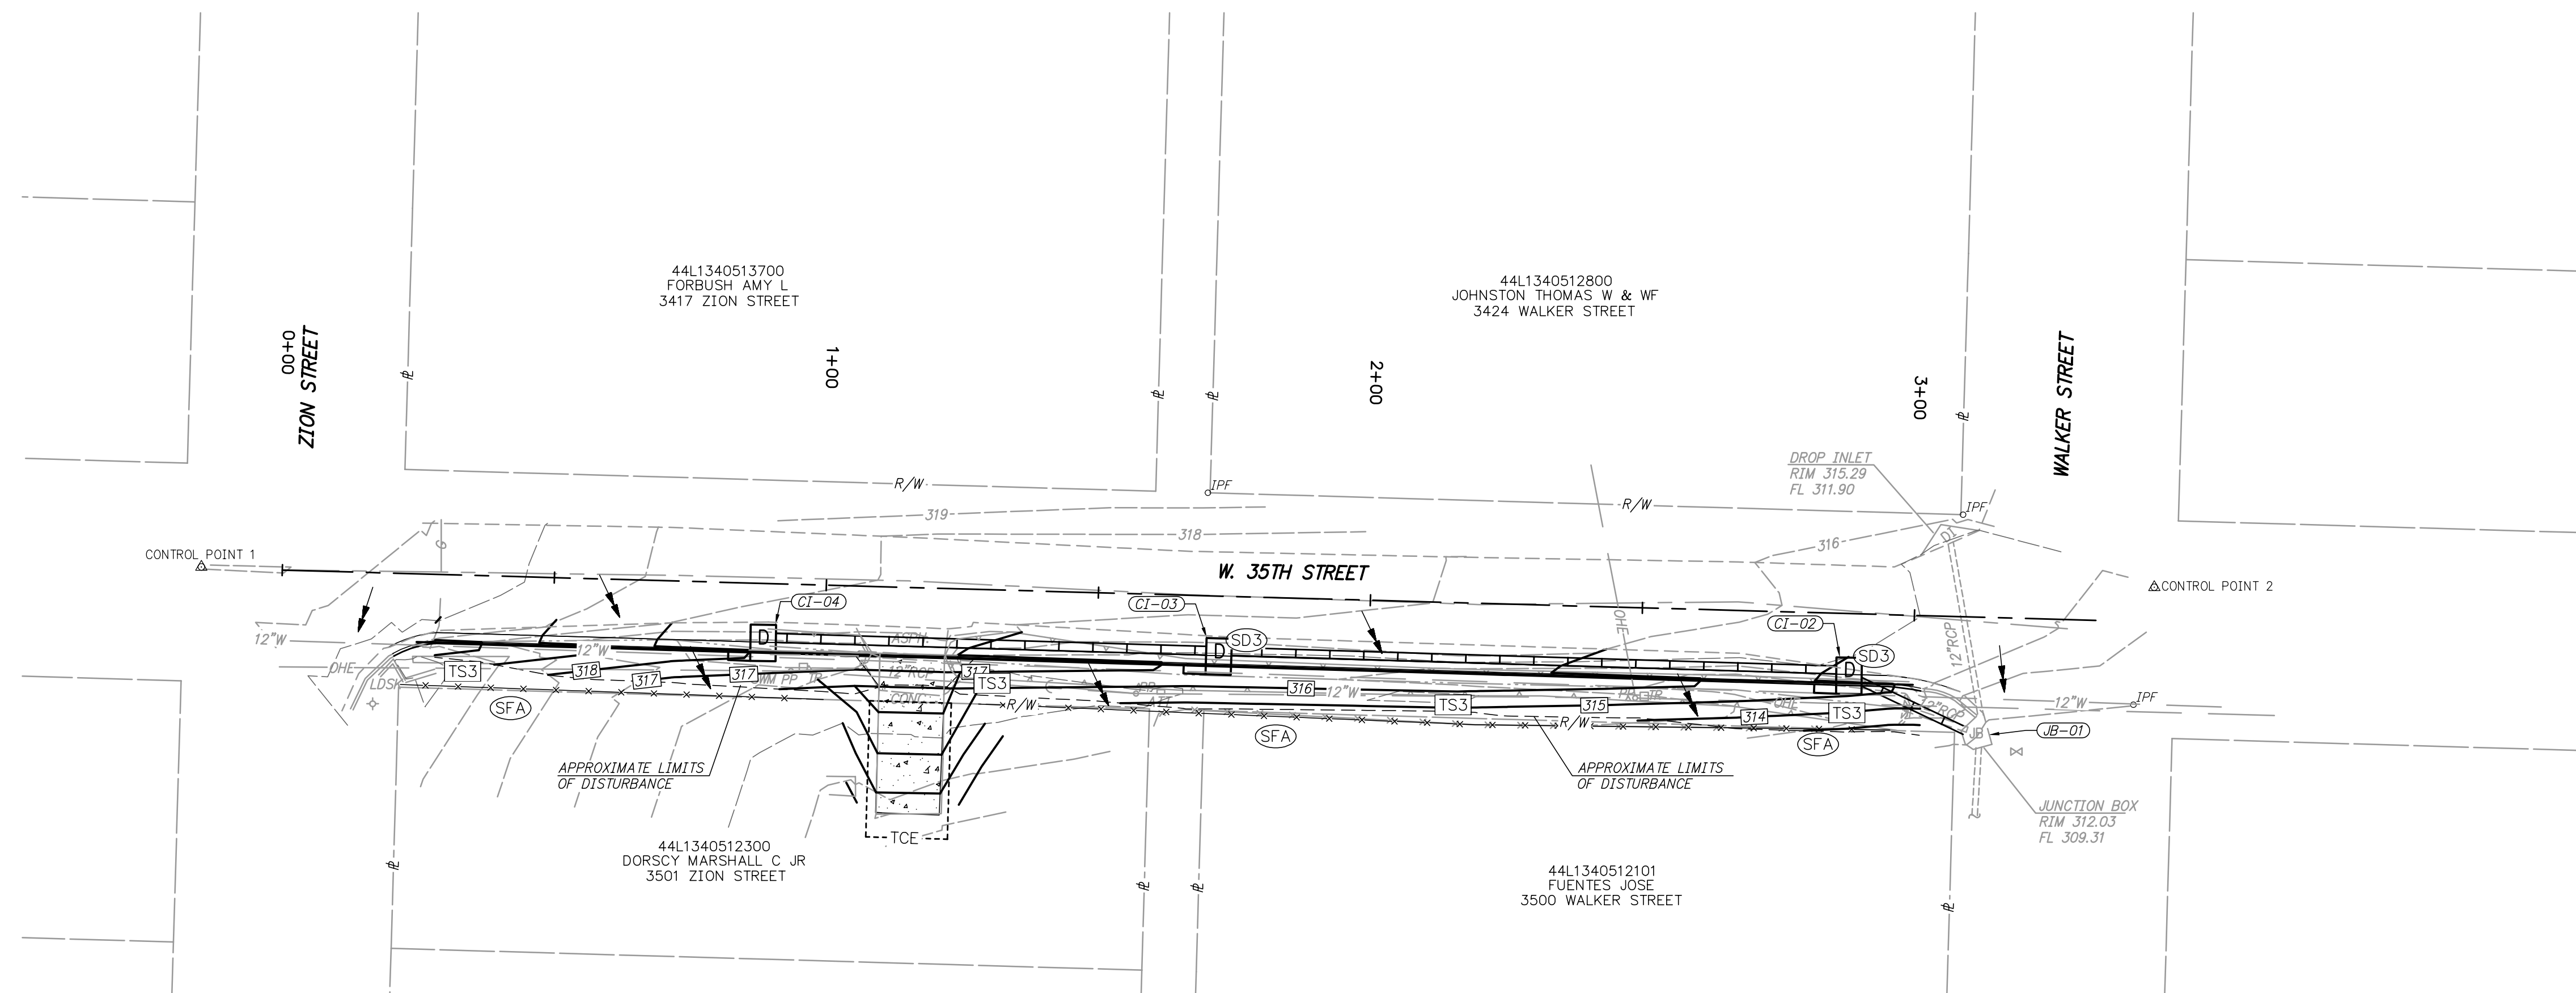


EROSION CONTROL PLAN
1"=20'


Z:\23\2023085 - 2023 STREET & DRAINAGE + 2022-2025 BAND PROGRAM - CITY OF LITTLE ROCK W 35TH STREET\US PLANS\DWG. 06-22-DR-213.DWG. 8/15/2024 2:54 PM JOSH MICHAELS LAYOUT1

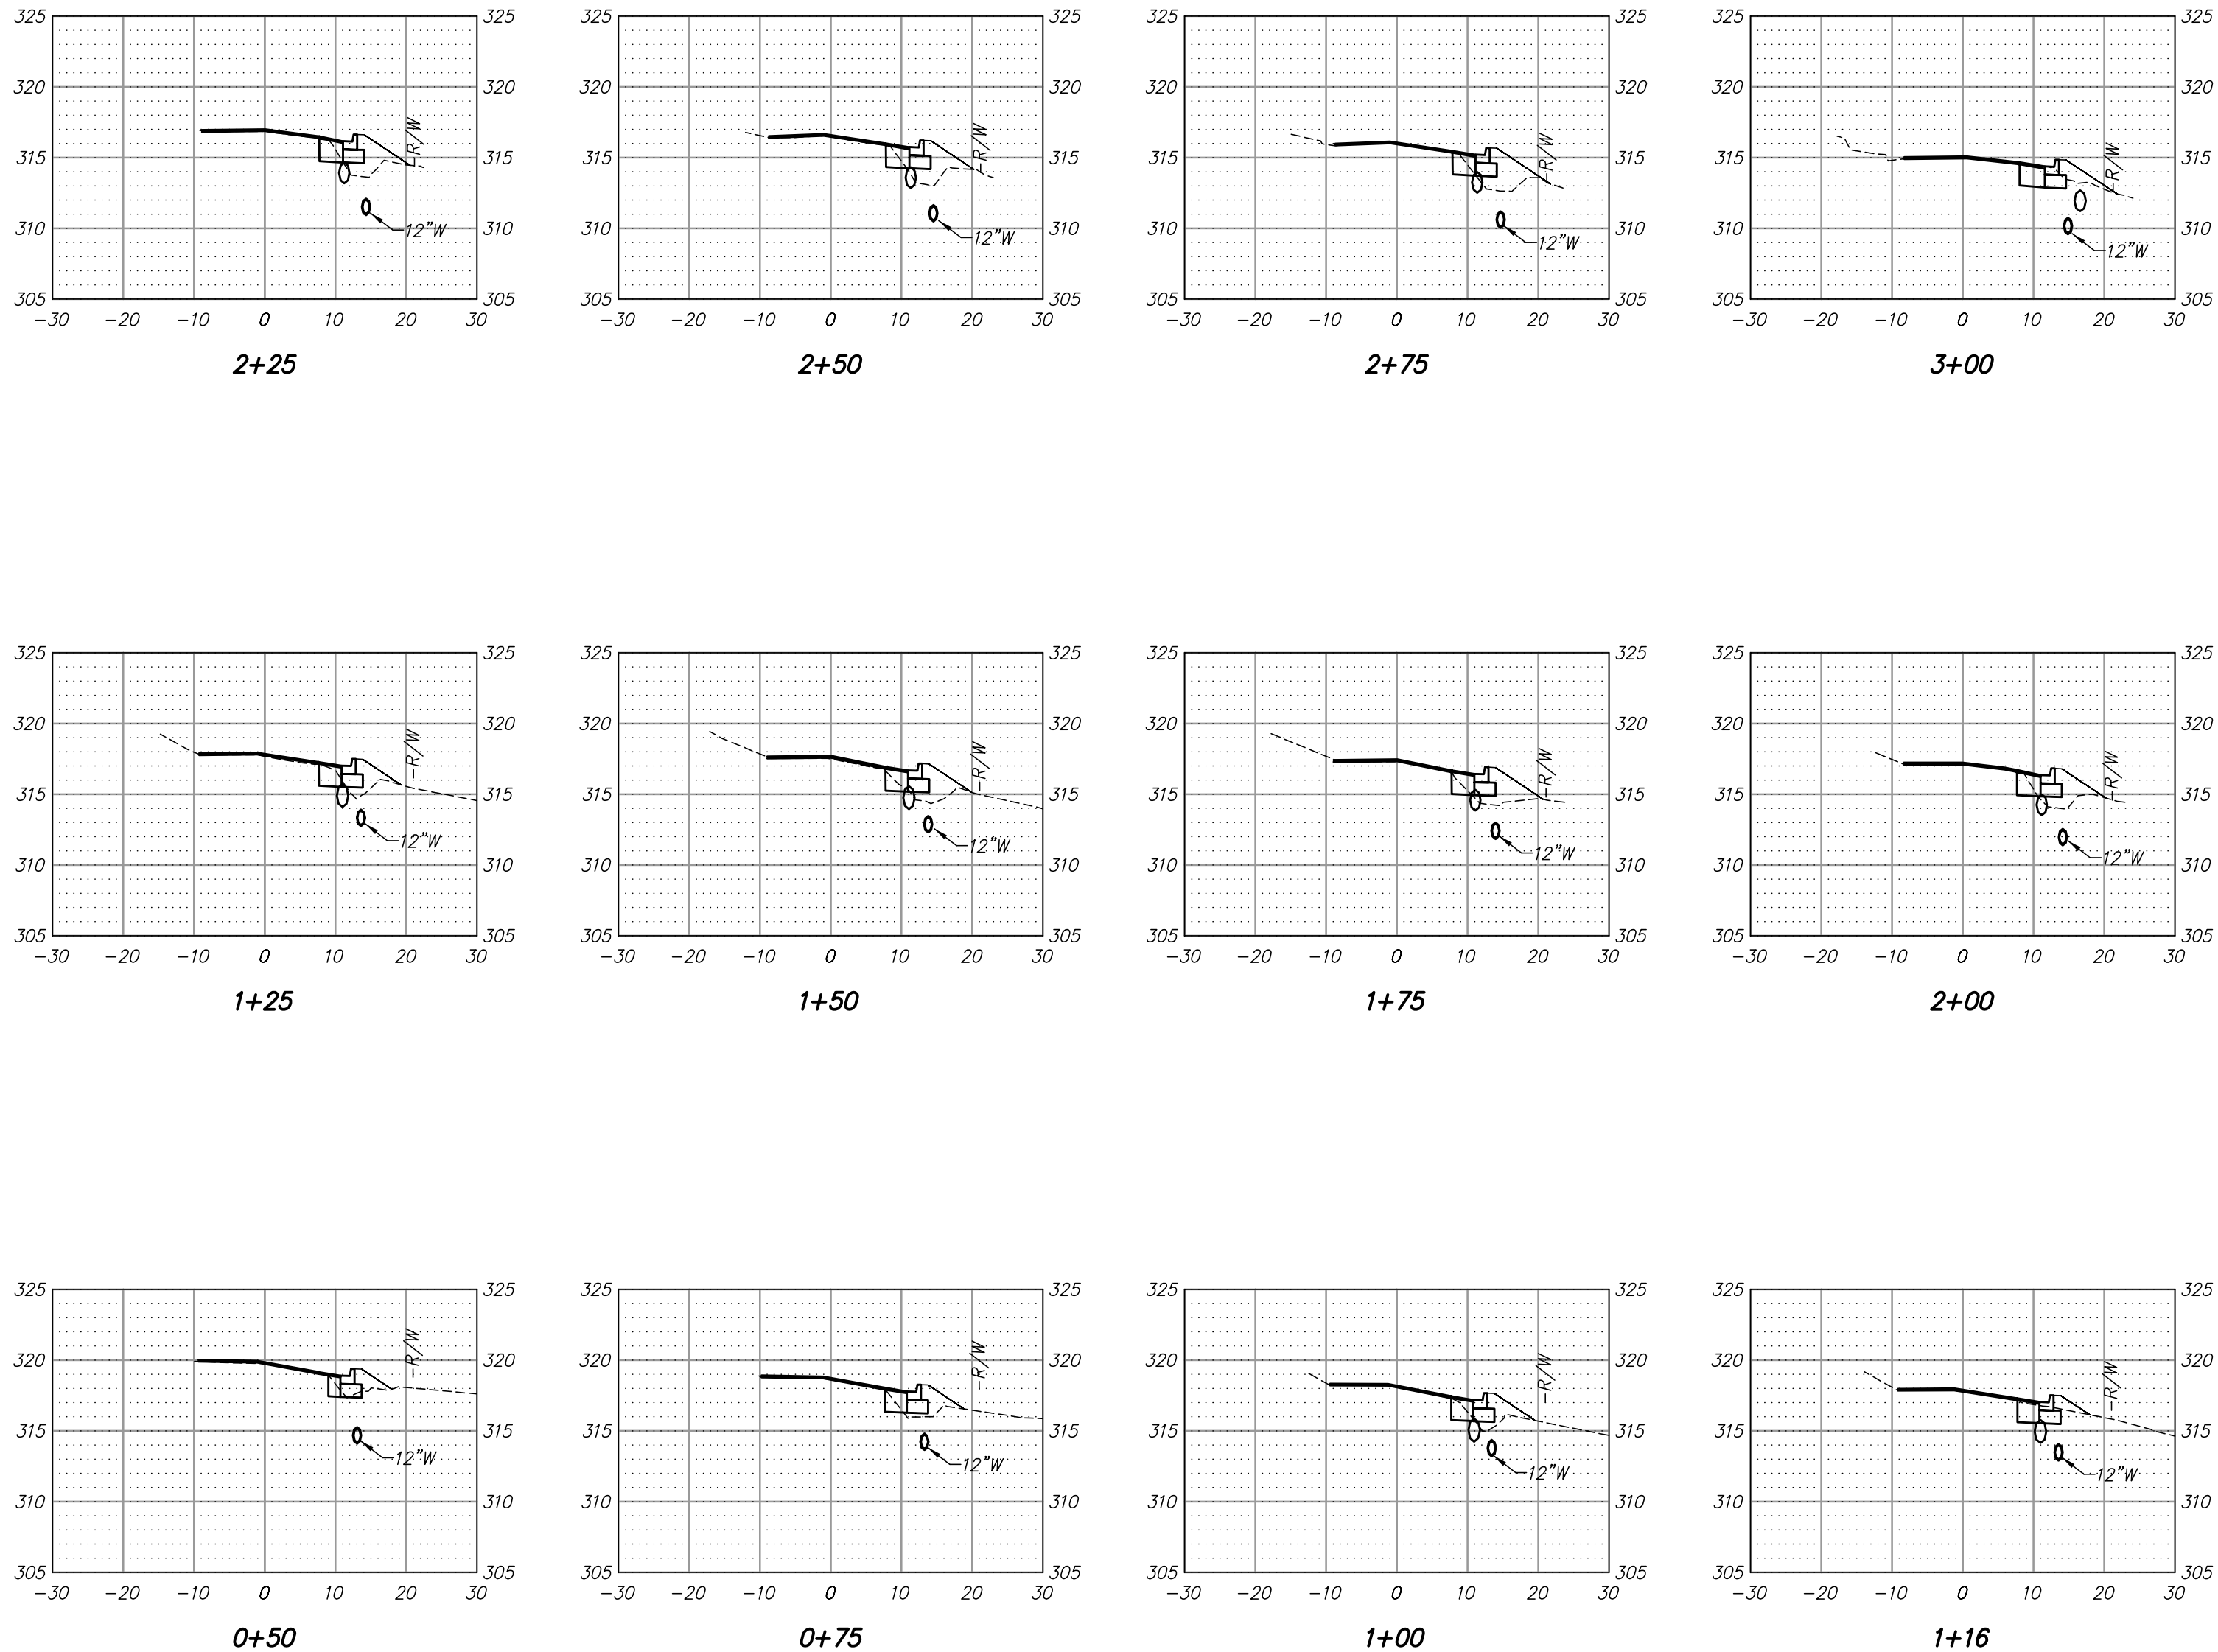

NOTES:
ELEVATION OF 12" WATER LINE SHOWN IS APPROXIMATE. CONTRACTOR SHALL VERIFY ELEVATION PRIOR TO CONSTRUCTION AND NOTIFY ENGINEER IF ANY CONFLICTS EXIST.

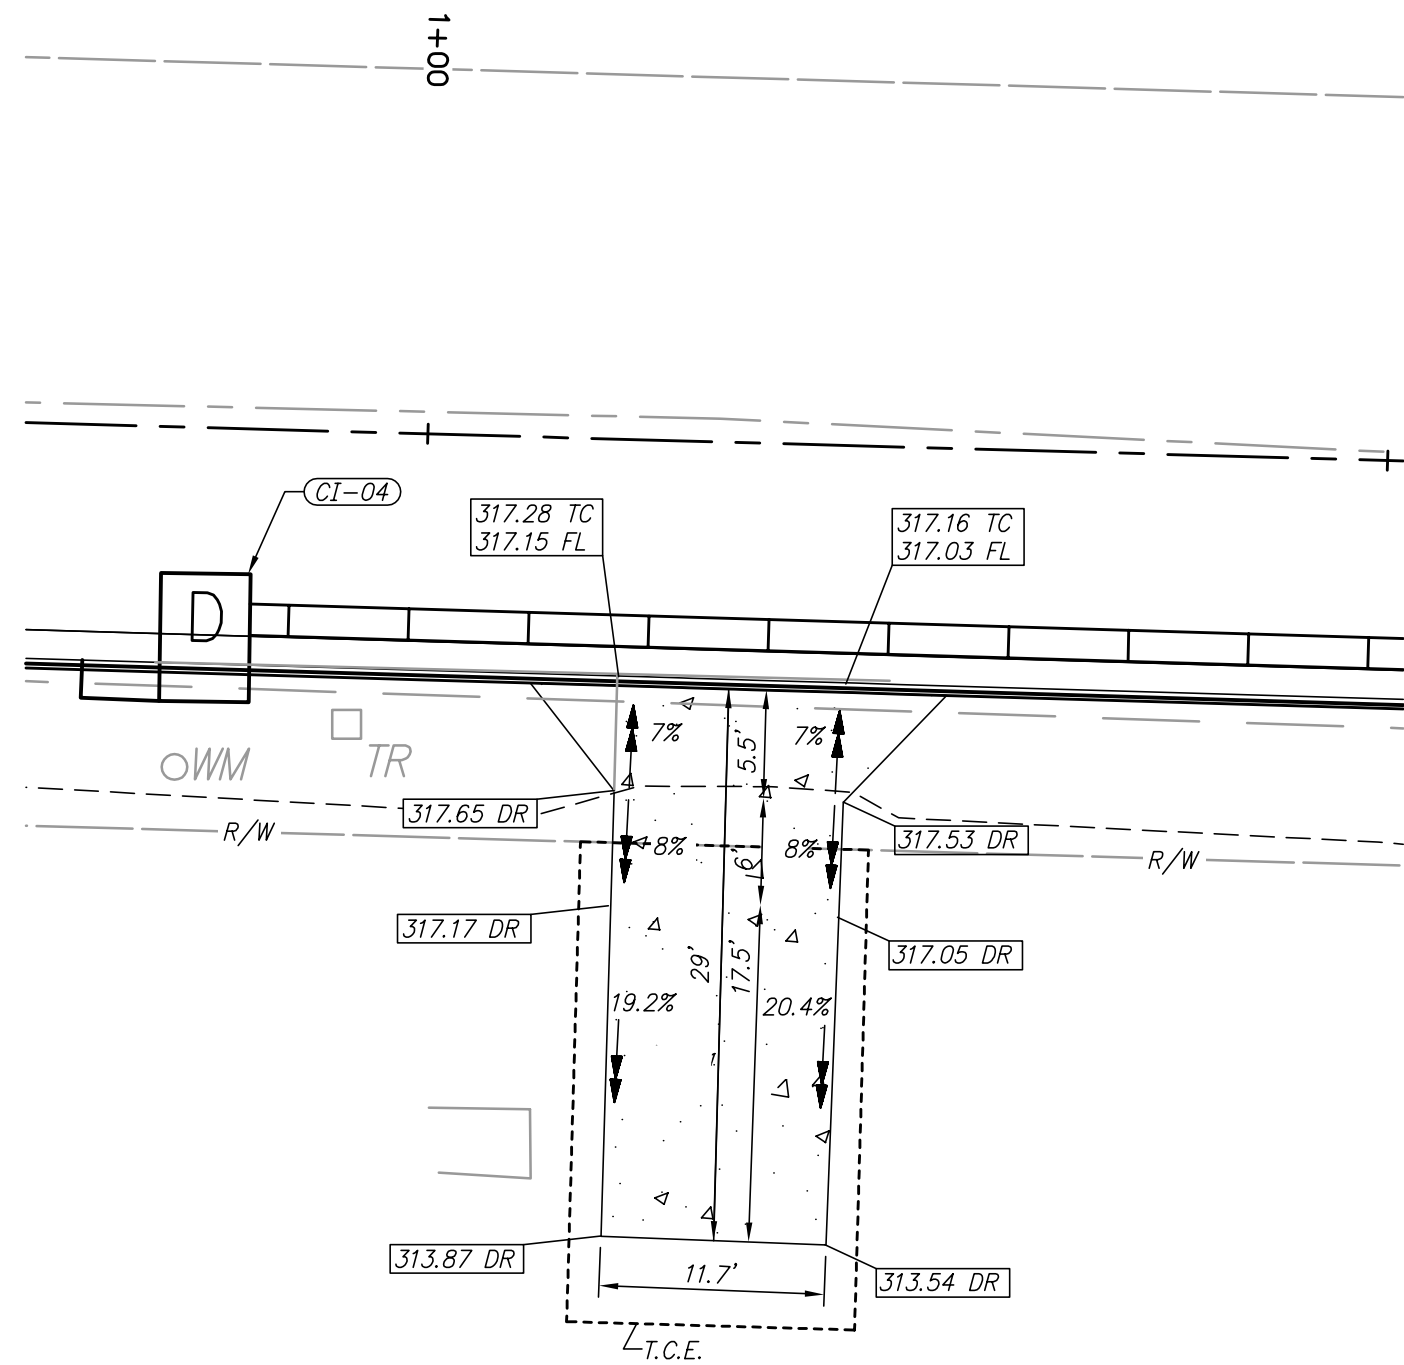

DRIVEWAY PLAN
1"=10'

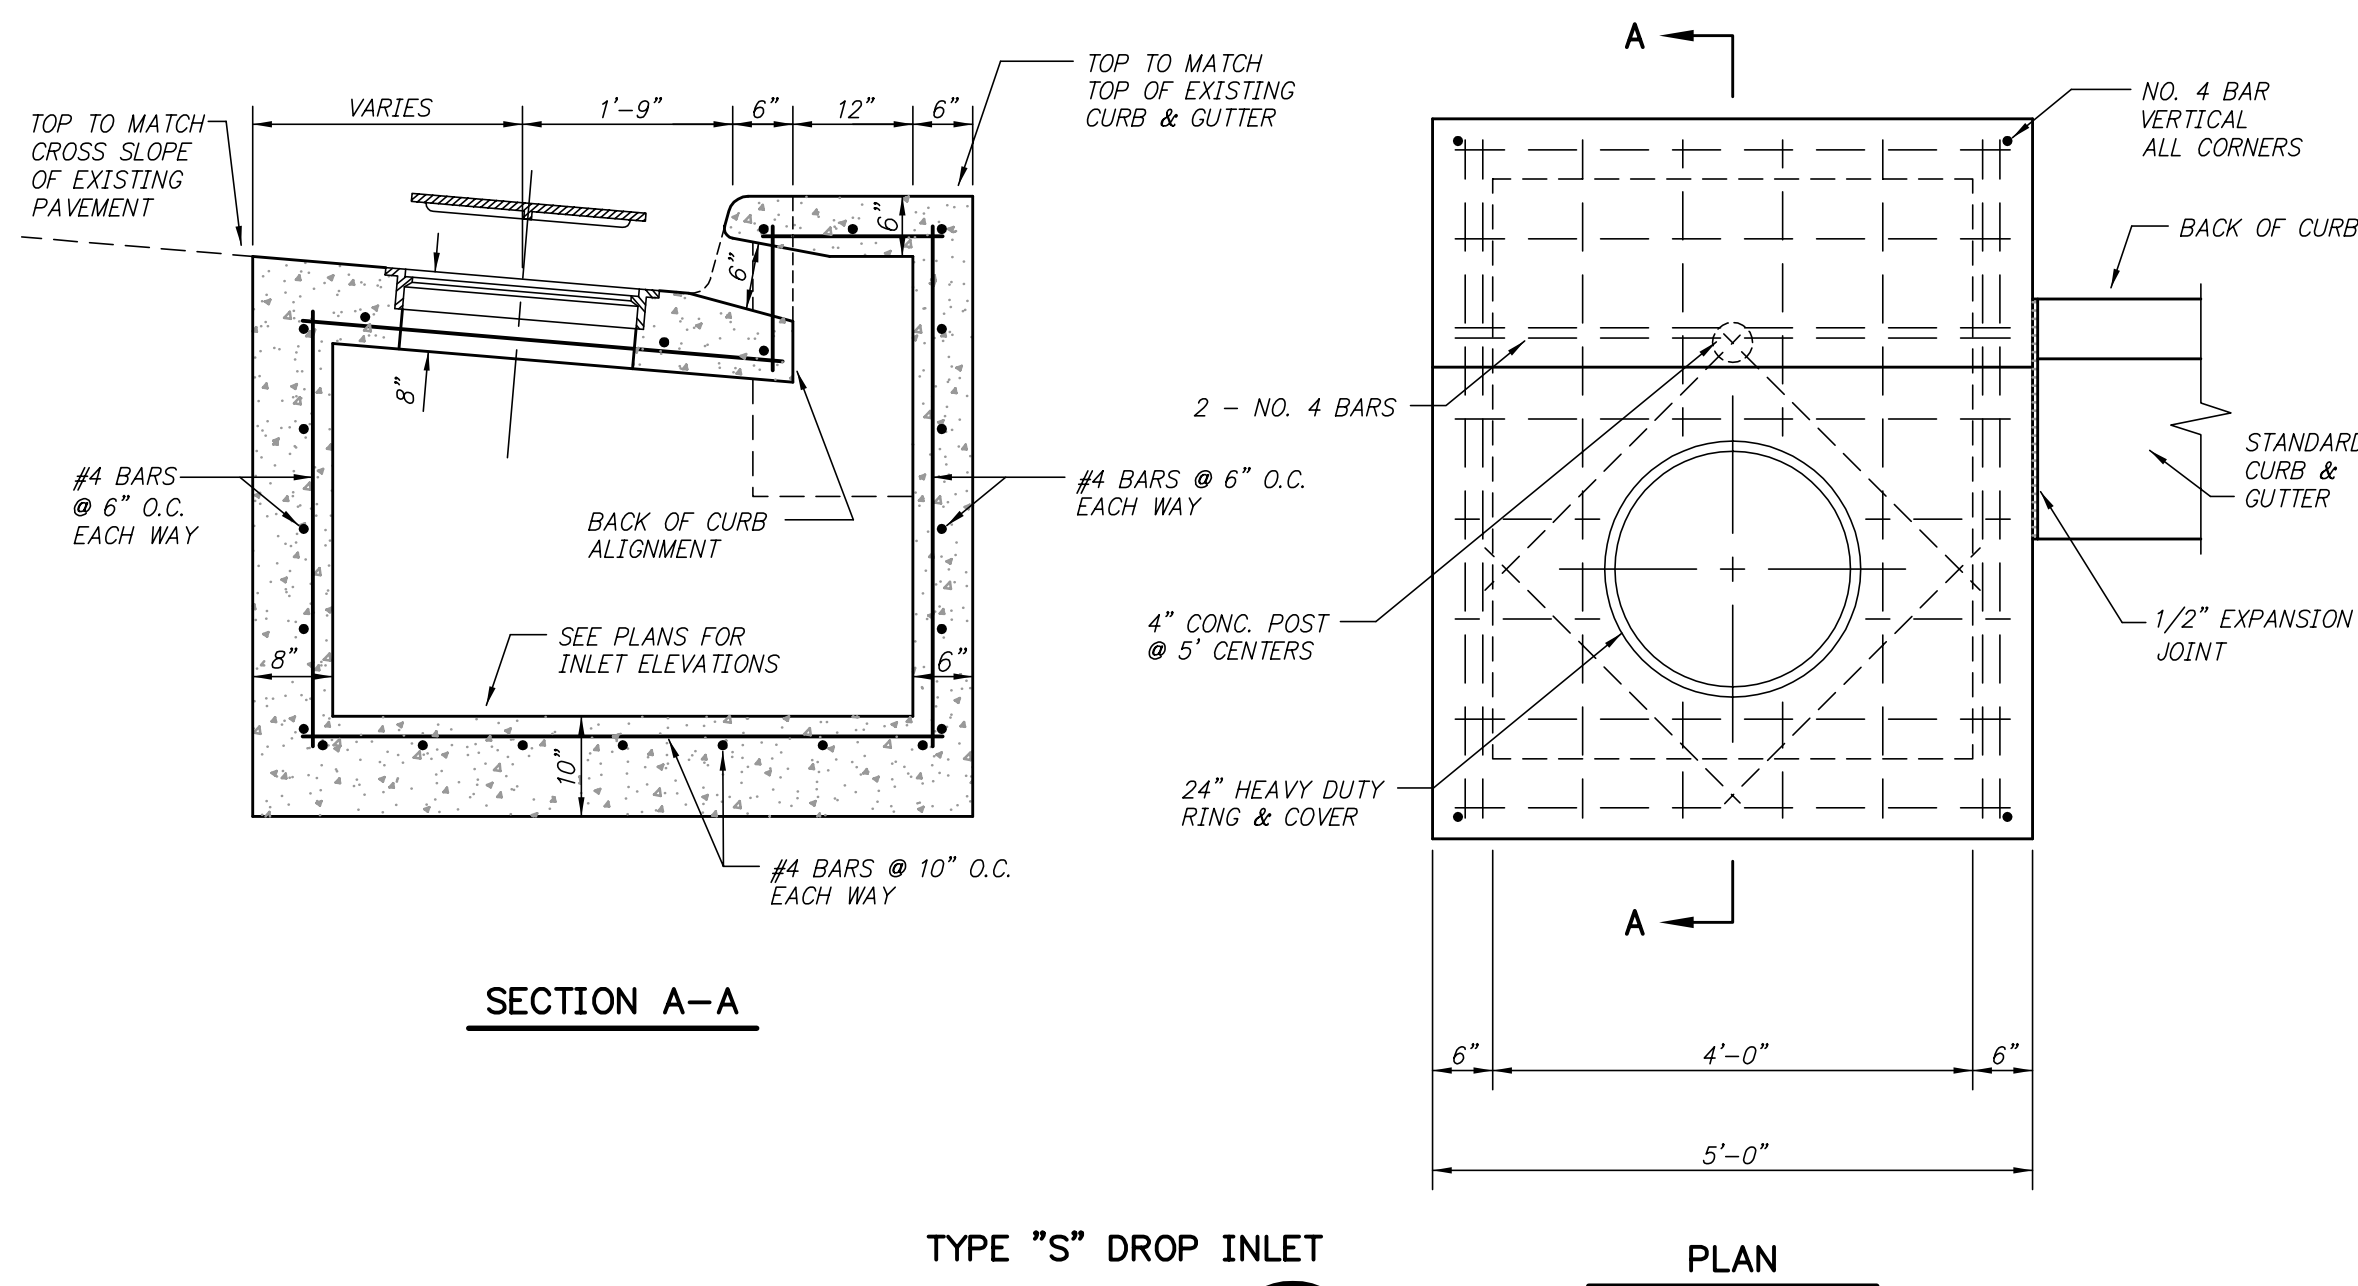

TYPE "S" DROP INLET

DETAIL

N.T.S.

C

REVISIONS	DATE

CITY OF LITTLE ROCK, ARKANSAS

WEST 35TH STREET

CROSS SECTIONS AND DETAILS


DEPARTMENT OF PUBLIC WORKS

CIVIL ENGINEERING

701 W. MARKHAM



LITTLE ROCK, ARKANSAS 72201



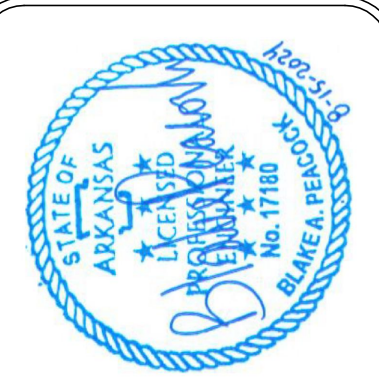

DRAWN BY	BAP
DESIGNED	BAP
CHECKED	JKS
DATE	REVISED 8-15-24
SCALE	AS SHOWN
PROJECT NO.	06-22-DR-213
SHEET NO.	5

Z:\3\2023085 2023 STREET & DRAINAGE + 2022-2025 BAND PROGRAM - CITY OF LITTLE ROCK\06 SCHEM - CITY OF LITTLE ROCK\06 SCHEM - 8/15/2024 2:55 PM JOSH NICHOLS LAYOUT

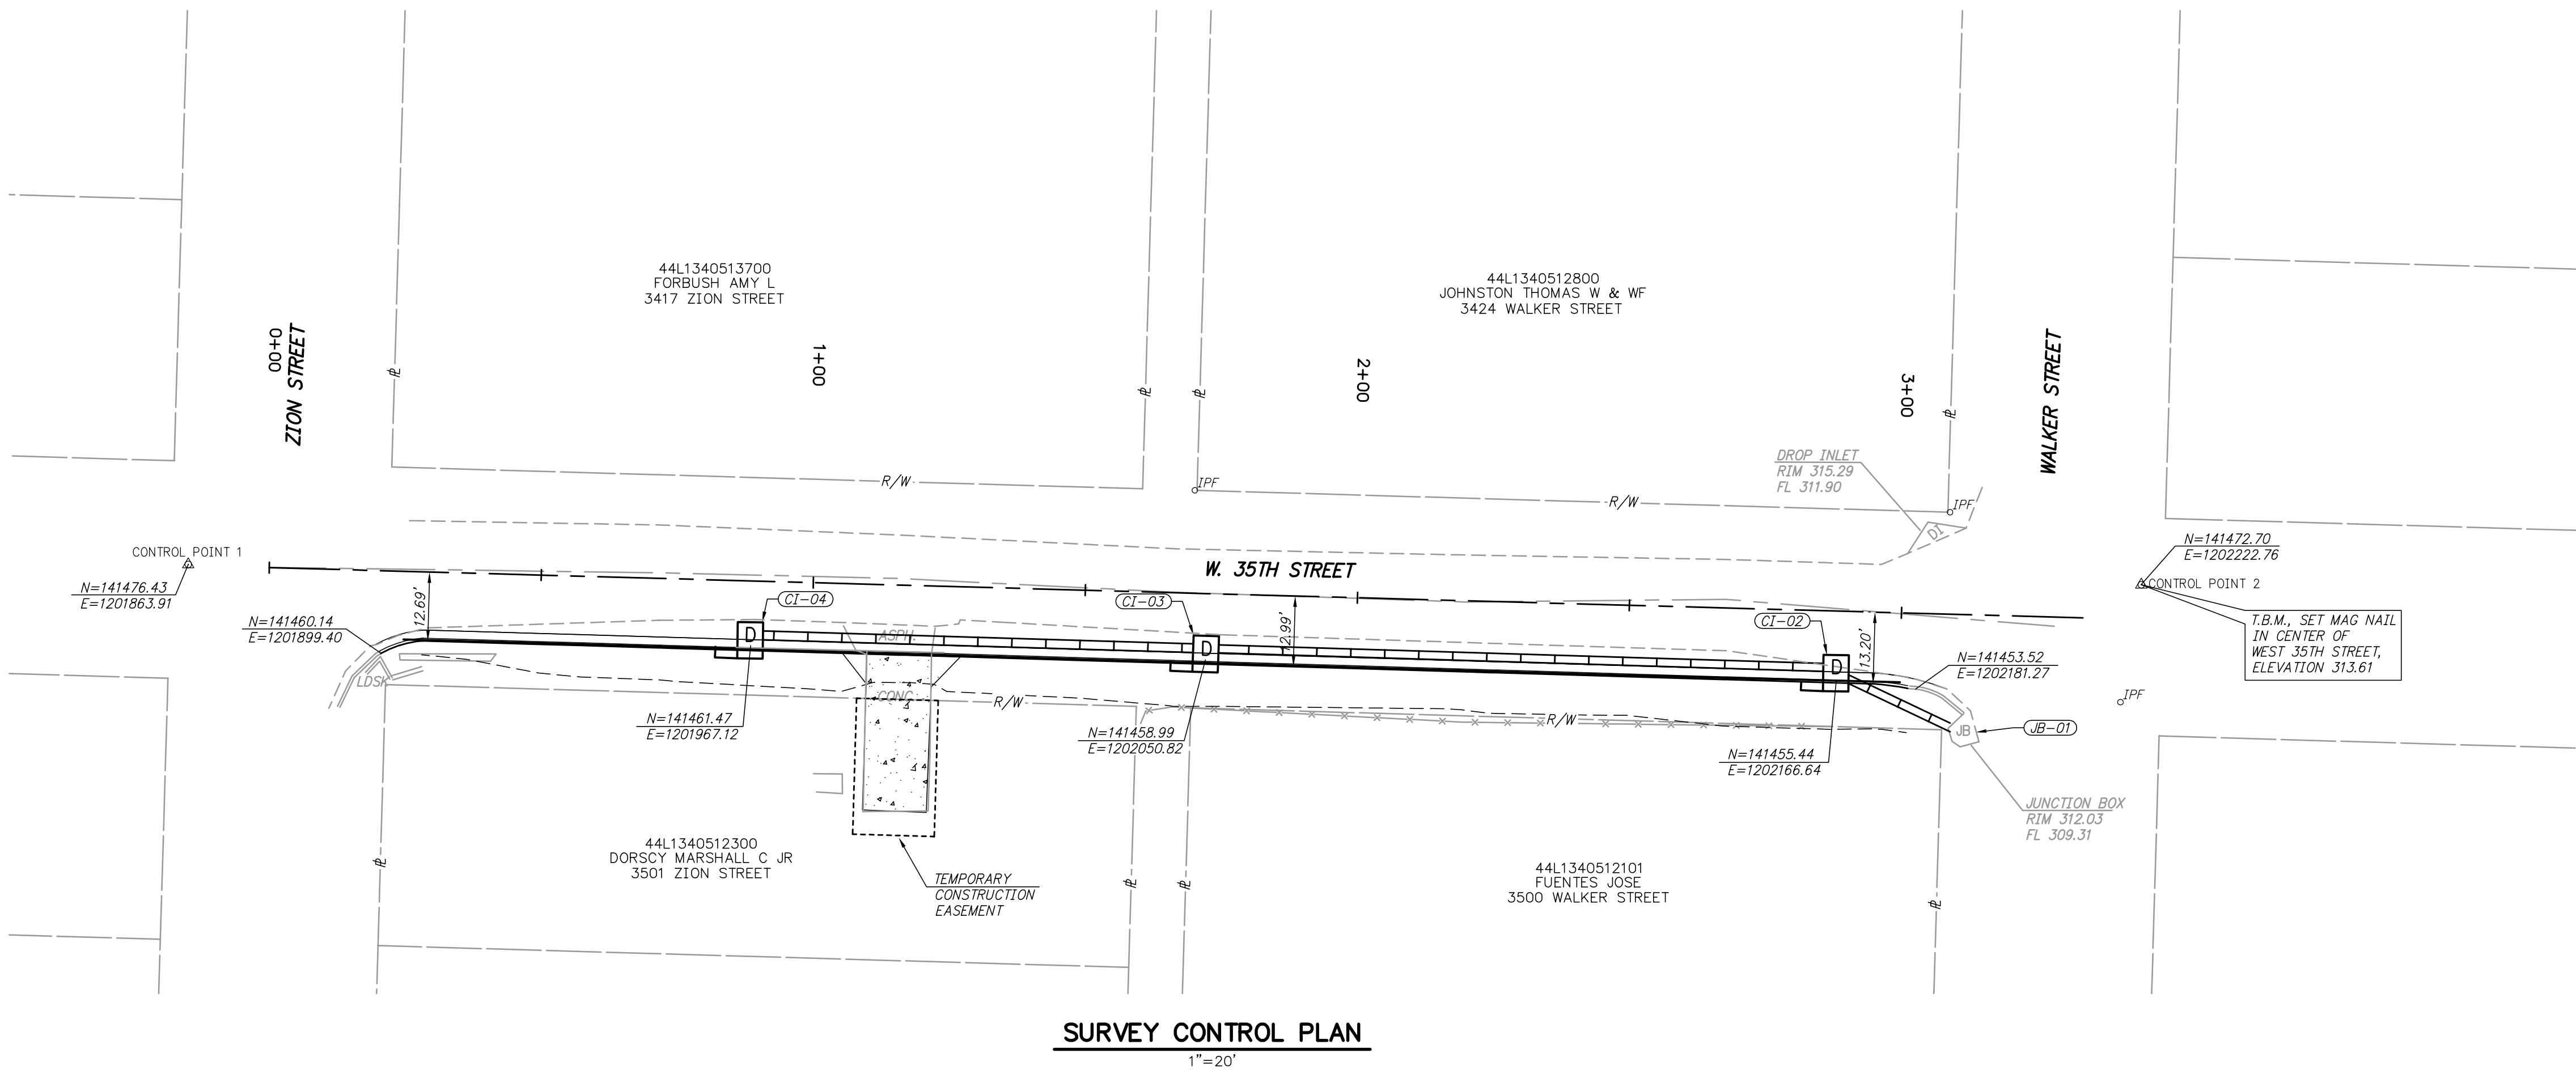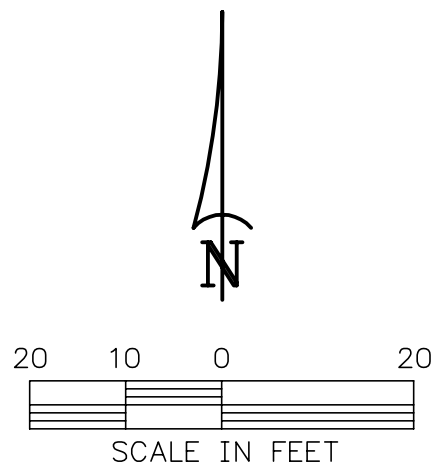


REVISIONS	DATE

CITY OF LITTLE ROCK, ARKANSAS

WEST 35TH STREET

SURVEY CONTROL PLAN

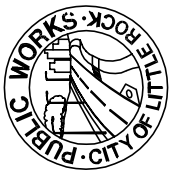

DEPARTMENT OF PUBLIC WORKS

CIVIL ENGINEERING

701 W. MARKHAM

LITTLE ROCK, ARKANSAS 72201



DRAWN BY
BAP
DESIGNED
BAP
CHECKED
JKS
DATE
JULY 2024
SCALE
1" = 20'
PROJECT NO.
06-22-DR-213
SHEET NO.

6