


(HWY. 70) (LITTLE ROCK) (S)

ROOSEVELT RD. - 17TH ST. LITTLE ROCK, ARKANSAS

30% DESIGN PHASE

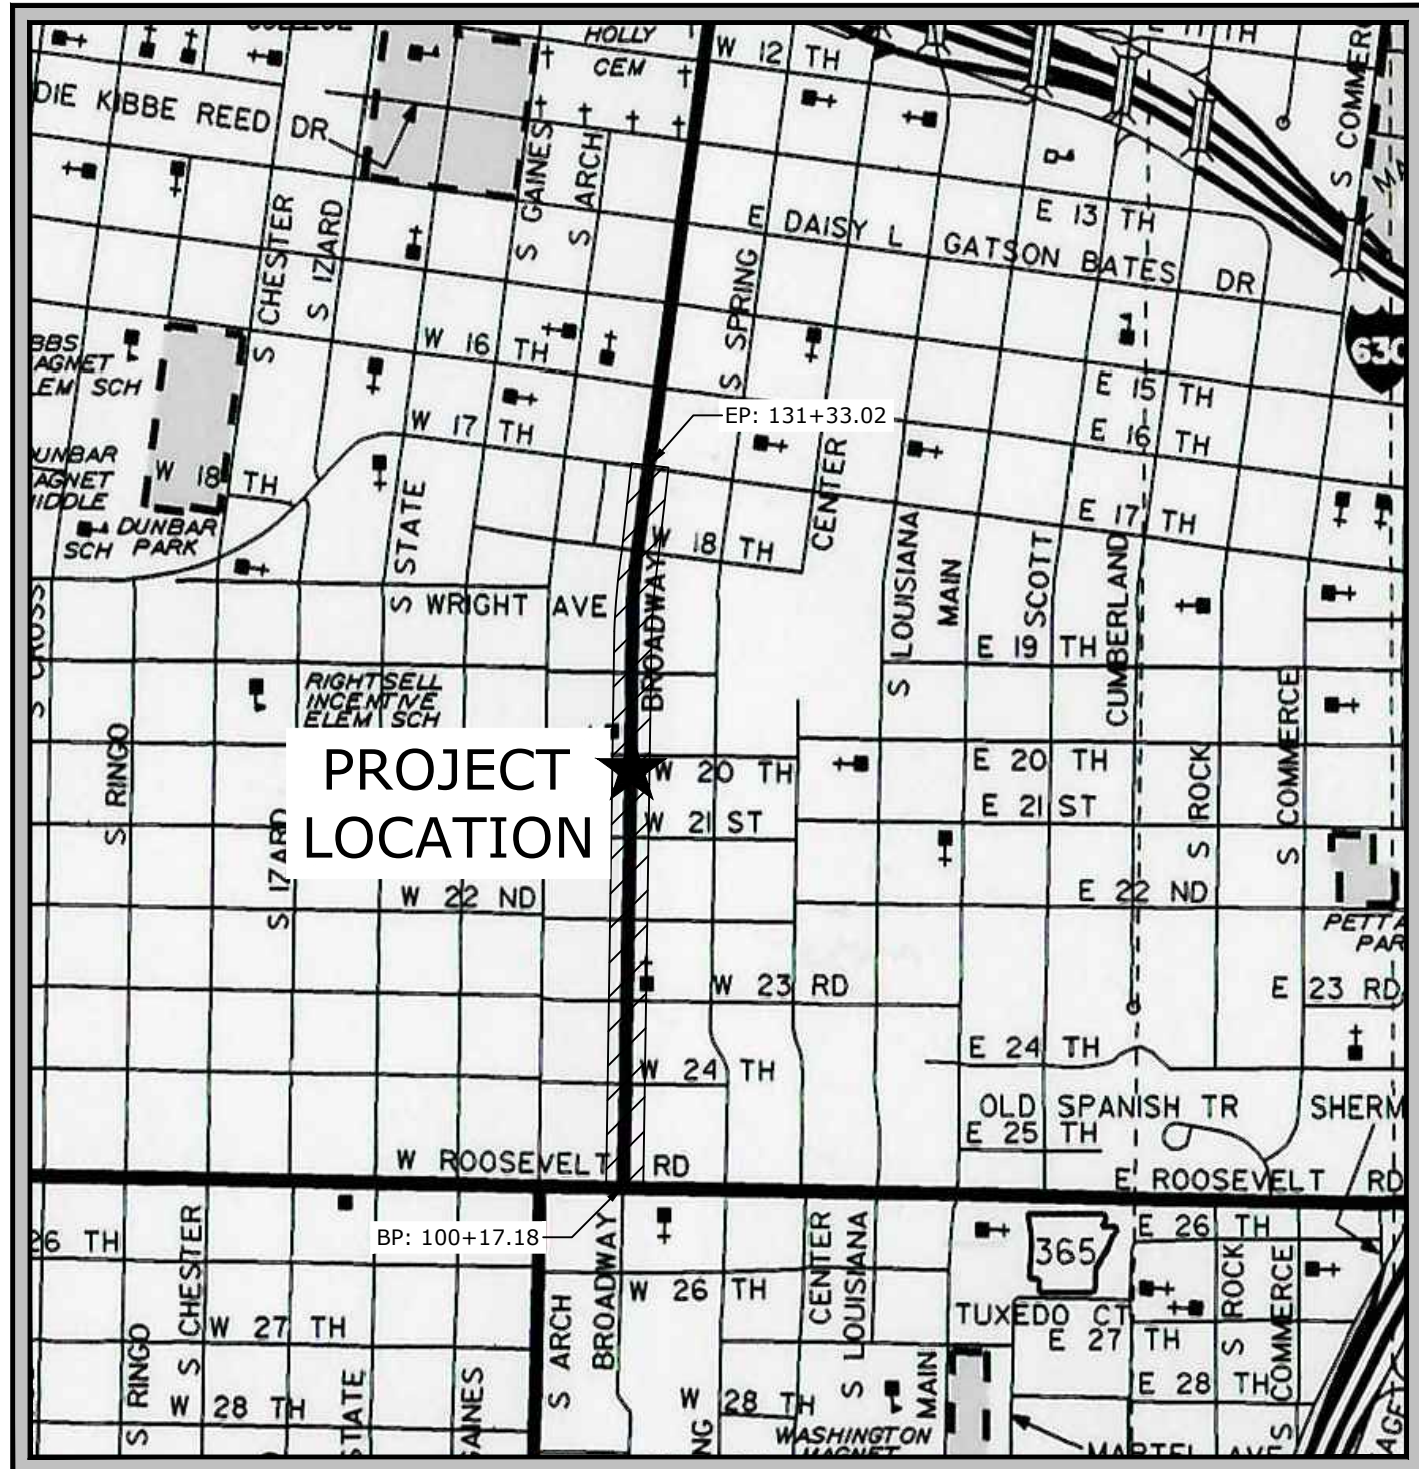


VICINITY MAP

SHEET INDEX	
NUMBER	TITLE
C1	COVER
C2	LEGEND
C3	PROJECT OVERVIEW
C4	TYPICAL SECTIONS OF IMPROVEMENT
C5	PLAN AND PROFILE
C6	PLAN AND PROFILE
C7	PLAN AND PROFILE
C8	PLAN AND PROFILE
C9	PLAN AND PROFILE
C10	PLAN AND PROFILE




REVISIONS		
REV	DATE	DESCRIPTION

April 11, 2025
MCE PROJECT NUMBER 24-5814

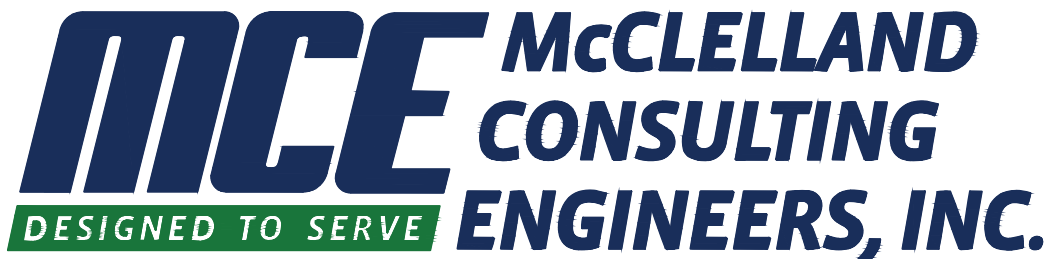

<http://www.mce.us.com>

7302 KANIS ROAD
LITTLE ROCK, ARKANSAS 72204
(501) 371-0272

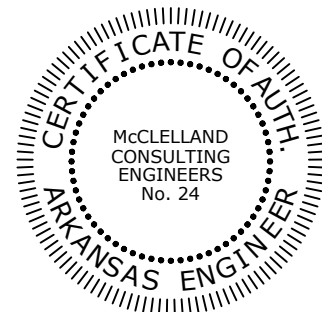

PRELIMINARY
NOT FOR
CONSTRUCTION







ORIGINAL SIGNATURE ON FILE

ROOSEVELT RD. -17TH ST. IMPVTS. (HWY. 70) (LITTLE ROCK) (S) LITTLE ROCK, ARKANSAS MCE #24-5814 4/11/2025 ---

EXISTING LEGEND

---	PROPERTY LINE		POWER POLE
-R/W-	RIGHT OF WAY		GUY WIRE w/ ANCHOR
-SS-	SANITARY SEWER LINE		GAS METER
-W-	WATER LINE		GAS RISER
-GAS-	GAS LINE		STREET LIGHT POLE
-UGT-	UNDERGROUND TELEPHONE		TELEPHONE PEDESTAL
-UGE-	UNDERGROUND ELECTRIC		CABLE TV PEDESTAL
-UGTV-	UNDERGROUND TELEVISION		CABLE VAULT
-UFO-	UNDERGROUND FIBER		ELECTRIC VAULT
-OHE-	OVERHEAD ELECTRIC		FIBER VAULT
-X-X-	FENCE		GAS VAULT
- - -	ROAD CENTERLINE		TELEPHONE VAULT
- - - - ->	DITCH FLOWLINE		WATER VAULT
- - - - -	EASEMENT LINE		SIGN (AS NOTED)
- - - - -	GRAVEL LINE		POST (AS NOTED)
	FIRE HYDRANT		BENCHMARK
	WATER METER		FOUND IRON PIN (AS NOTED)
	WATER VALVE		CONTROL POINT
	WATER FAUCET		RR SPIKE
	SANITARY SEWER MH		BUSH
	CLEAN-OUT		DECIDUOUS TREE
	DRAINAGE MH		CONIFEROUS TREE

      PROPOSED LEGEND

=====	CURB AND GUTTER
- - - - -	EASEMENT
- - - - -	SETBACK
- - - TCE - - -	TEMPORARY CONSTRUCTION EASEMENT
- - - X - - -	FENCE
=====	PAINTED / THERMOPLASTIC STRIPING
	ASPHALT PAVEMENT
	CONCRETE PAVEMENT
	CONCRETE SIDEWALK
	CATCH BASIN
	FLARED END SECTION
	SANITARY SEWER MANHOLE
	PARKING STALL COUNT
	BUILDING CONTROL POINT
	FIRE DEPARTMENT CONNECTION
	FIRE HYDRANT
	POST INDICATOR VALVE
	WATER METER
	POWER POLE/POWER POLE & GUY
	LIGHT POLE
	ELECTRICAL TRANSFORMER
	ELECTRICAL PEDESTAL
	TELEPHONE PEDESTAL
	TRAFFIC SIGNAL PEDESTAL

MCCLELLAND

DESIGNED TO SERVE

CONSULTING, INC.

7302 KANIS ROAD

LITTLE ROCK, ARKANSAS 72204

(501) 371-0272

HTTP://WWW.MCE.US.COM

PRELIMINARY
NOT FOR
CONSTRUCTION

ORIGINAL SIGNATURE ON FILE

ROOSEVELT RD. - 17TH ST. IMPVTS
(HWY. 70) (LITTLE ROCK) (S)
ROOSEVELT RD. - 17TH ST.
LITTLE ROCK, ARKANSAS

811

Know what's below.
Call before you dig.

REVISIONS		DESCRIPTION	
REV	DATE	DESCRIPTION	


LEGEND

DESIGNED BY:	DRAWN BY:
SS	AC
DATE:	REVISION:
4/11/2025	----
SCALE:	JOB NUMBER:
1" = 20'	0618383

C2

©2025

W:\2024\24-5814 Little Rock - Job No. 061838 Roosevelt Rd. -17th Impvts. (Hwy. 70) (Little Rock) (S)\Design Drawings\Sheets\24-5814 DESIGN.dwg, PRINTED ON: April 11, 2025 @ 11:26 AM

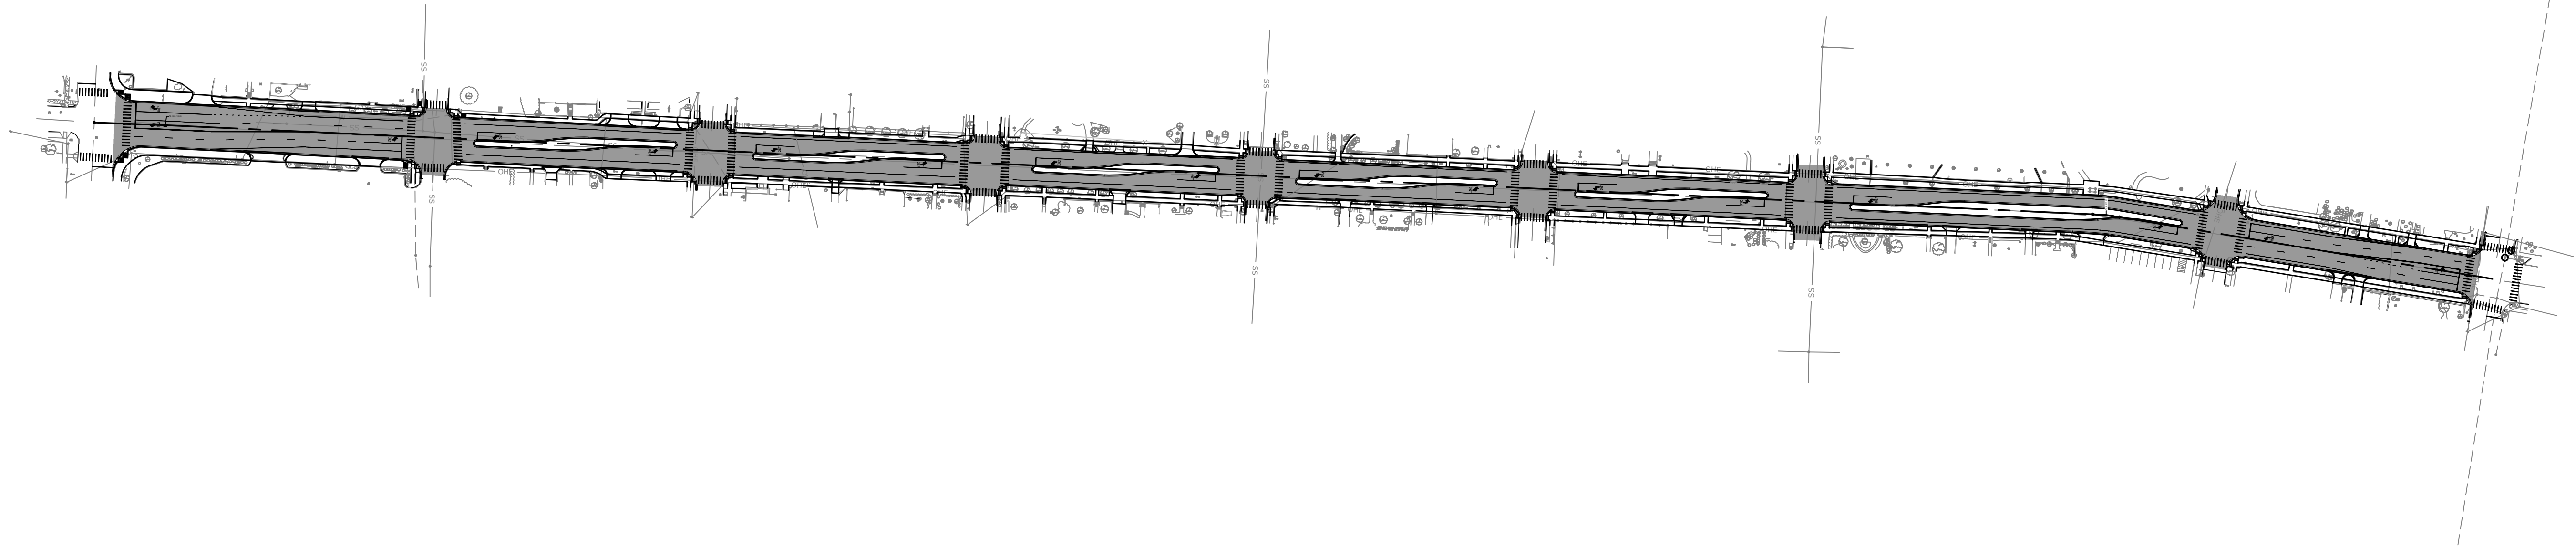

DESIGNED BY:	DRAWN BY:
SS	AC
DATE:	REVISION:
4/11/2025	----
SCALE:	JOB NUMBER:
1"=120'	0618383

PROJECT OVERVIEW

REVISIONS	
REV	DESCRIPTION



Know what's below.
Call before you dig.

ROOSEVELT RD. - 17TH ST. IMPVTS
(HWY. 70) (LITTLE ROCK) (S)
ROOSEVELT RD. - 17TH ST.
LITTLE ROCK, ARKANSAS






ORIGINAL SIGNATURE ON FILE

PRELIMINARY
NOT FOR
CONSTRUCTION



7302 KANIS ROAD
LITTLE ROCK, ARKANSAS 72204
(501) 371-0272
HTTP://WWW.MCE.US.COM

W:\2024\24-5814 Little Rock - Job No. 061838 Roosevelt Rd. - 17th Impvts. (Hwy. 70) (Little Rock) (S)\Design Drawings\Sheets\24-5814 DESIGN.dwg, PRINTED ON: April 11, 2025 @ 11:26 AM

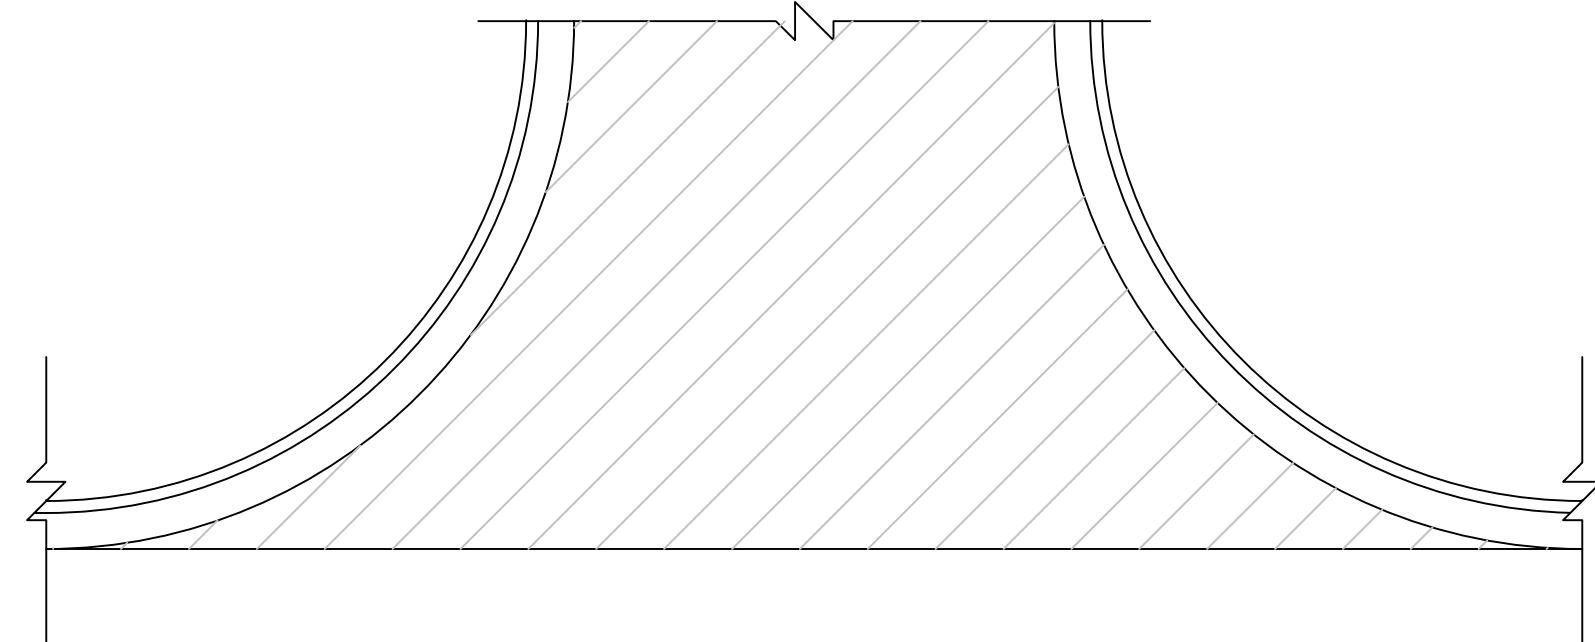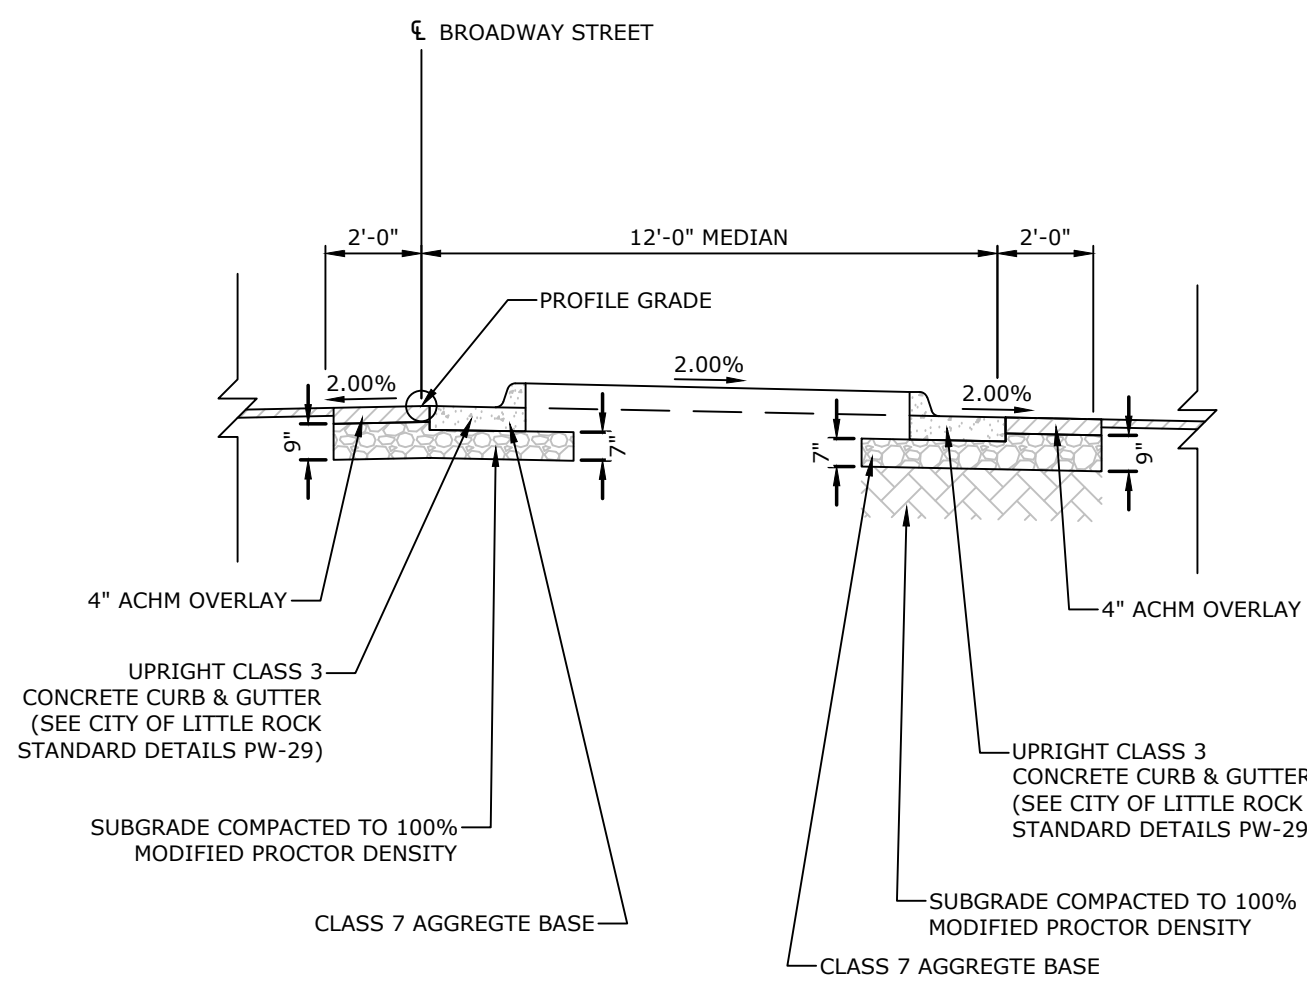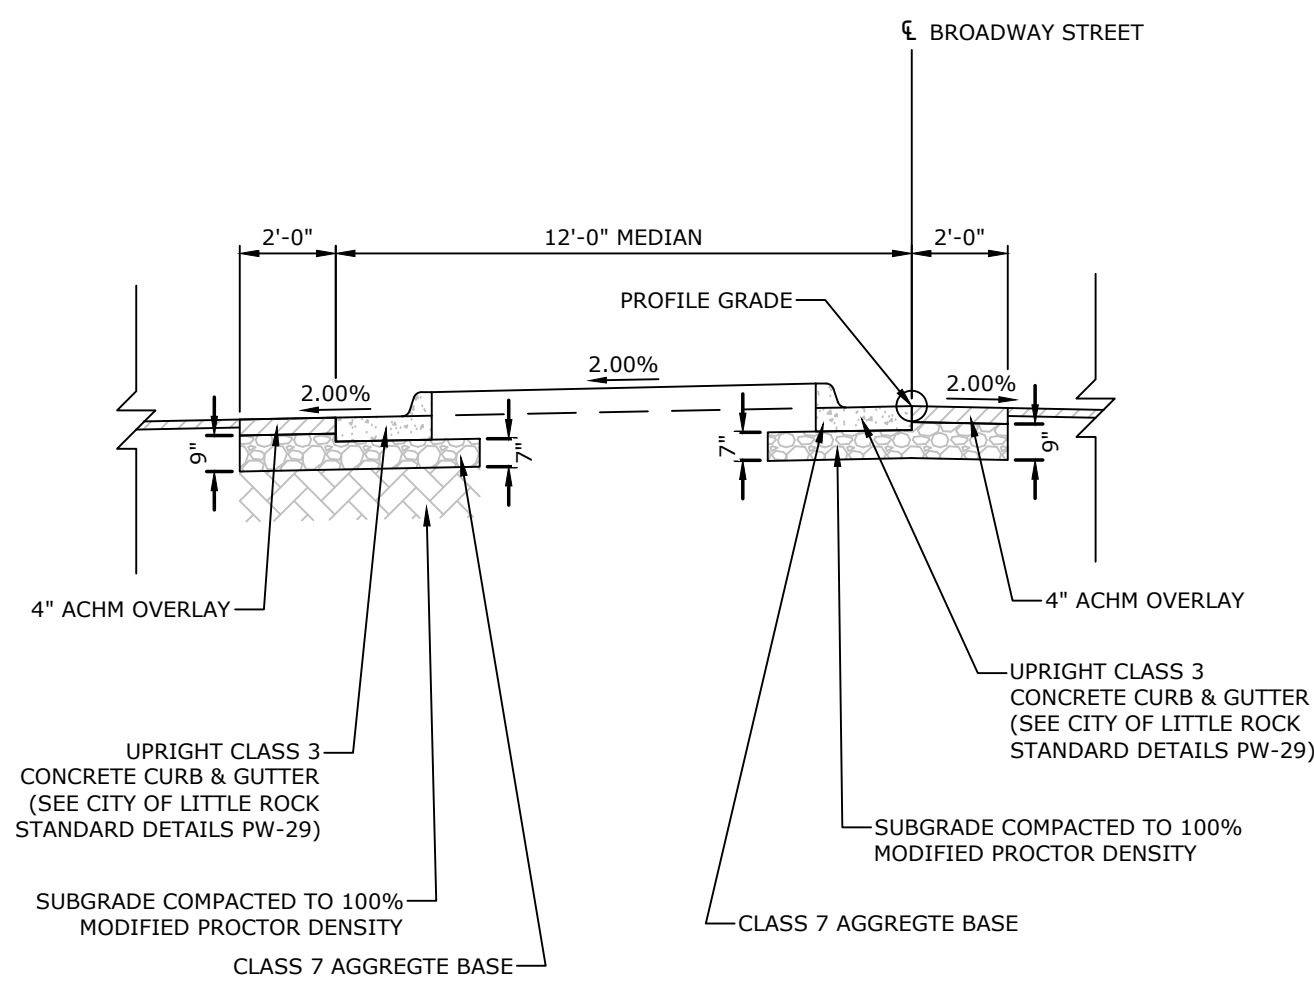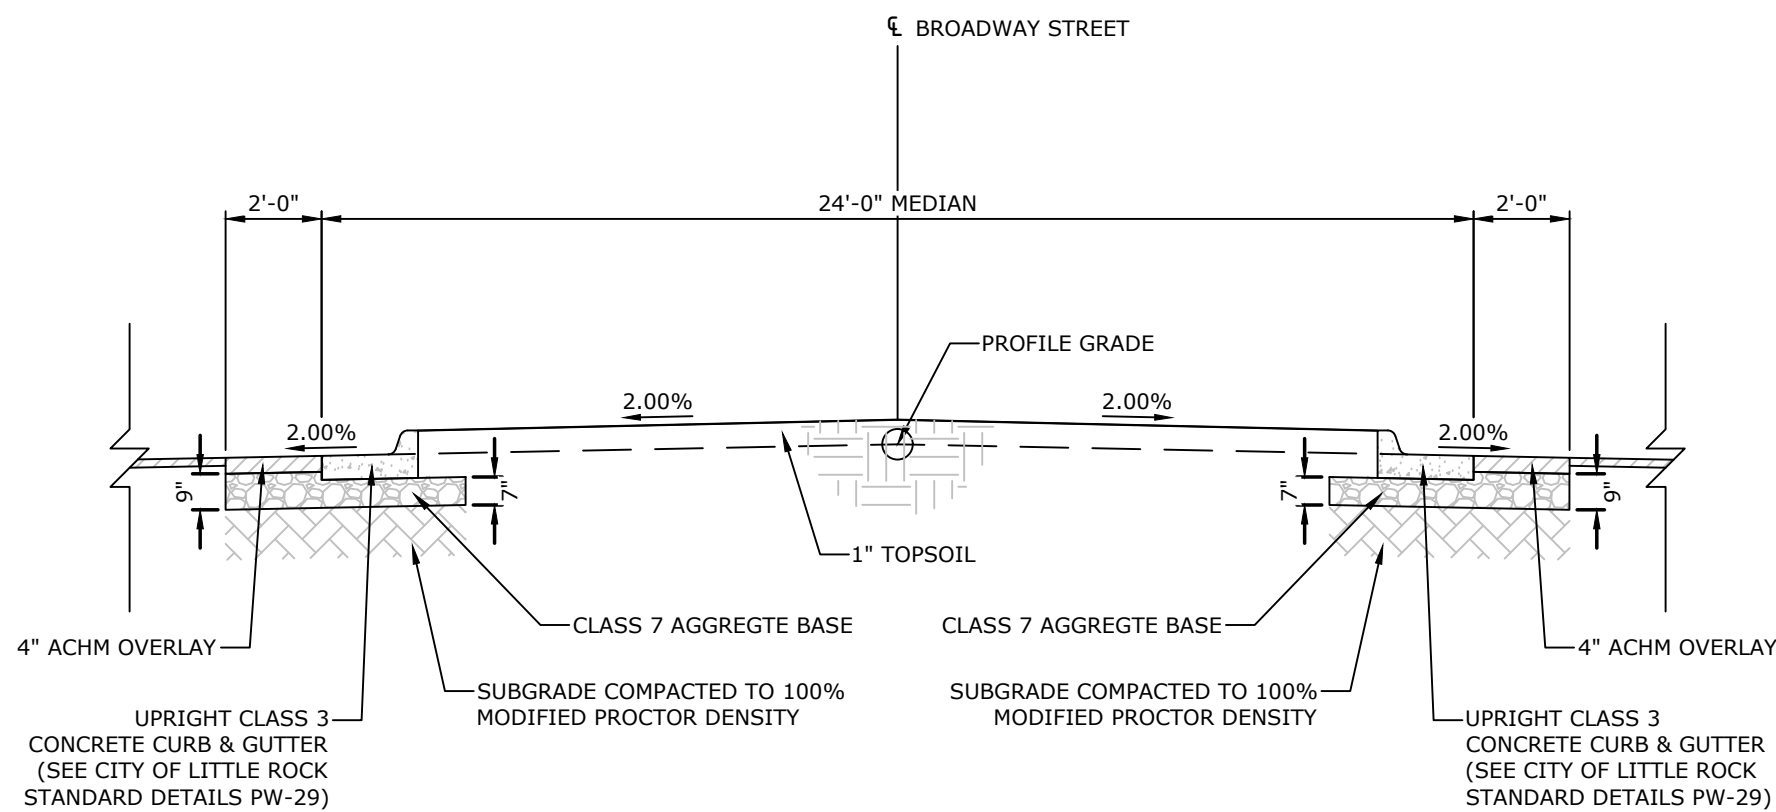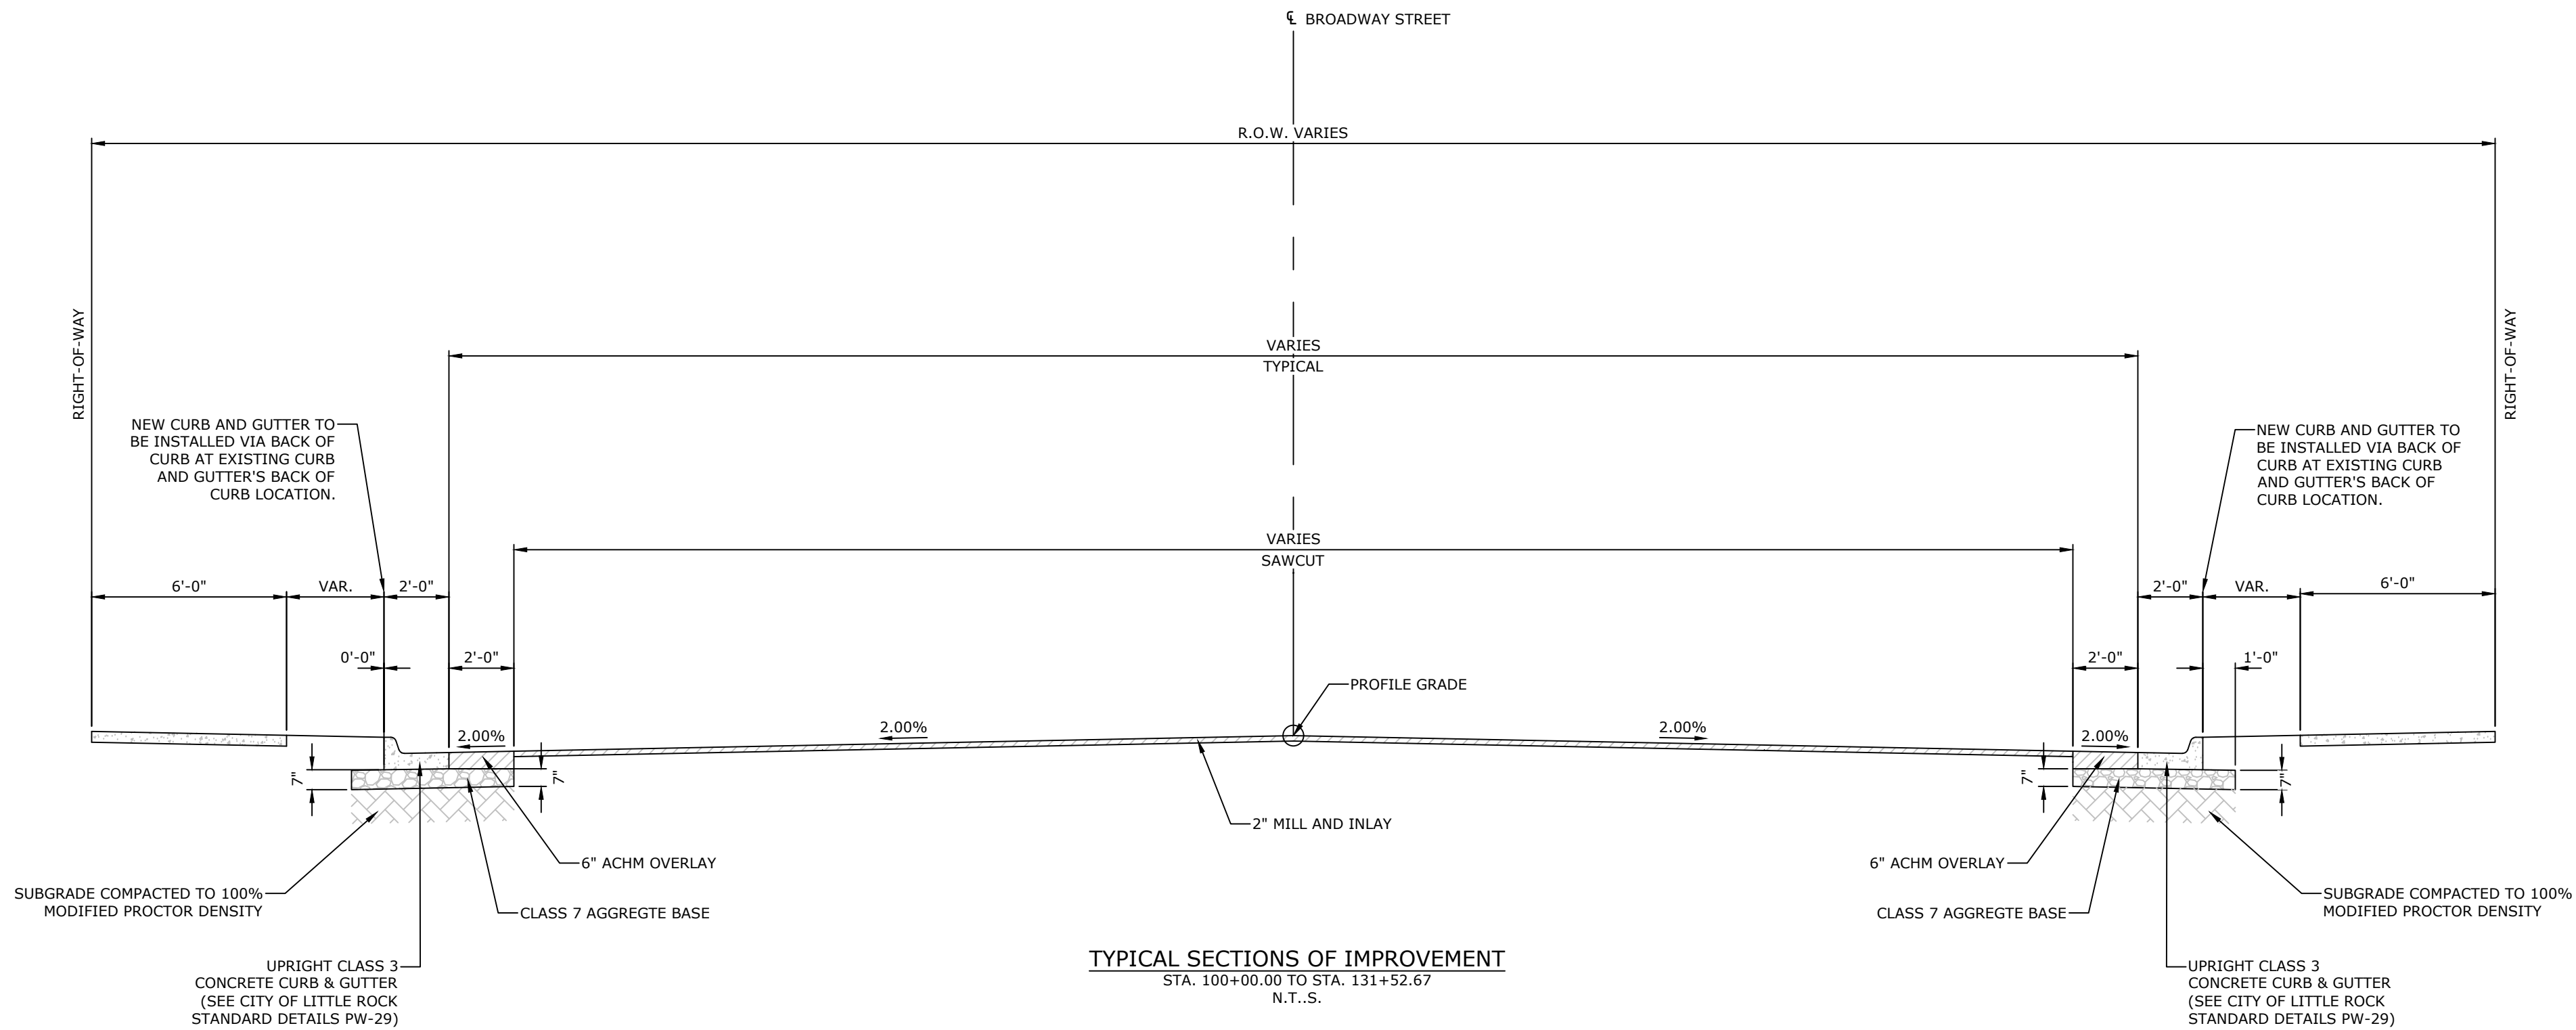

PRELIMINARY
NOT FOR
CONSTRUCTION

ROOSEVELT RD. - 17TH ST. IMPVTS
(HWY. 70) (LITTLE ROCK) (S)
ROOSEVELT RD. - 17TH ST.
LITTLE ROCK, ARKANSAS





REVISIONS		DESCRIPTION
REV	DATE	

TYPICAL
SECTIONS OF
IMPROVEMENT

DESIGNED BY: SS	DRAWN BY: AC
DATE: 4/11/2025	REVISION: ----
SCALE: 1" = 20'	JOB NUMBER: 0618383

W:\2024\24-5814 Little Rock - Job No. 061838 Roosevelt Rd. - 17th Impvts. (Hwy. 70) (Little Rock) (S)\Design Drawings\Sheets\24-5814 DESIGN.dwg, PRINTED ON: April 11, 2025 @ 11:27 AM

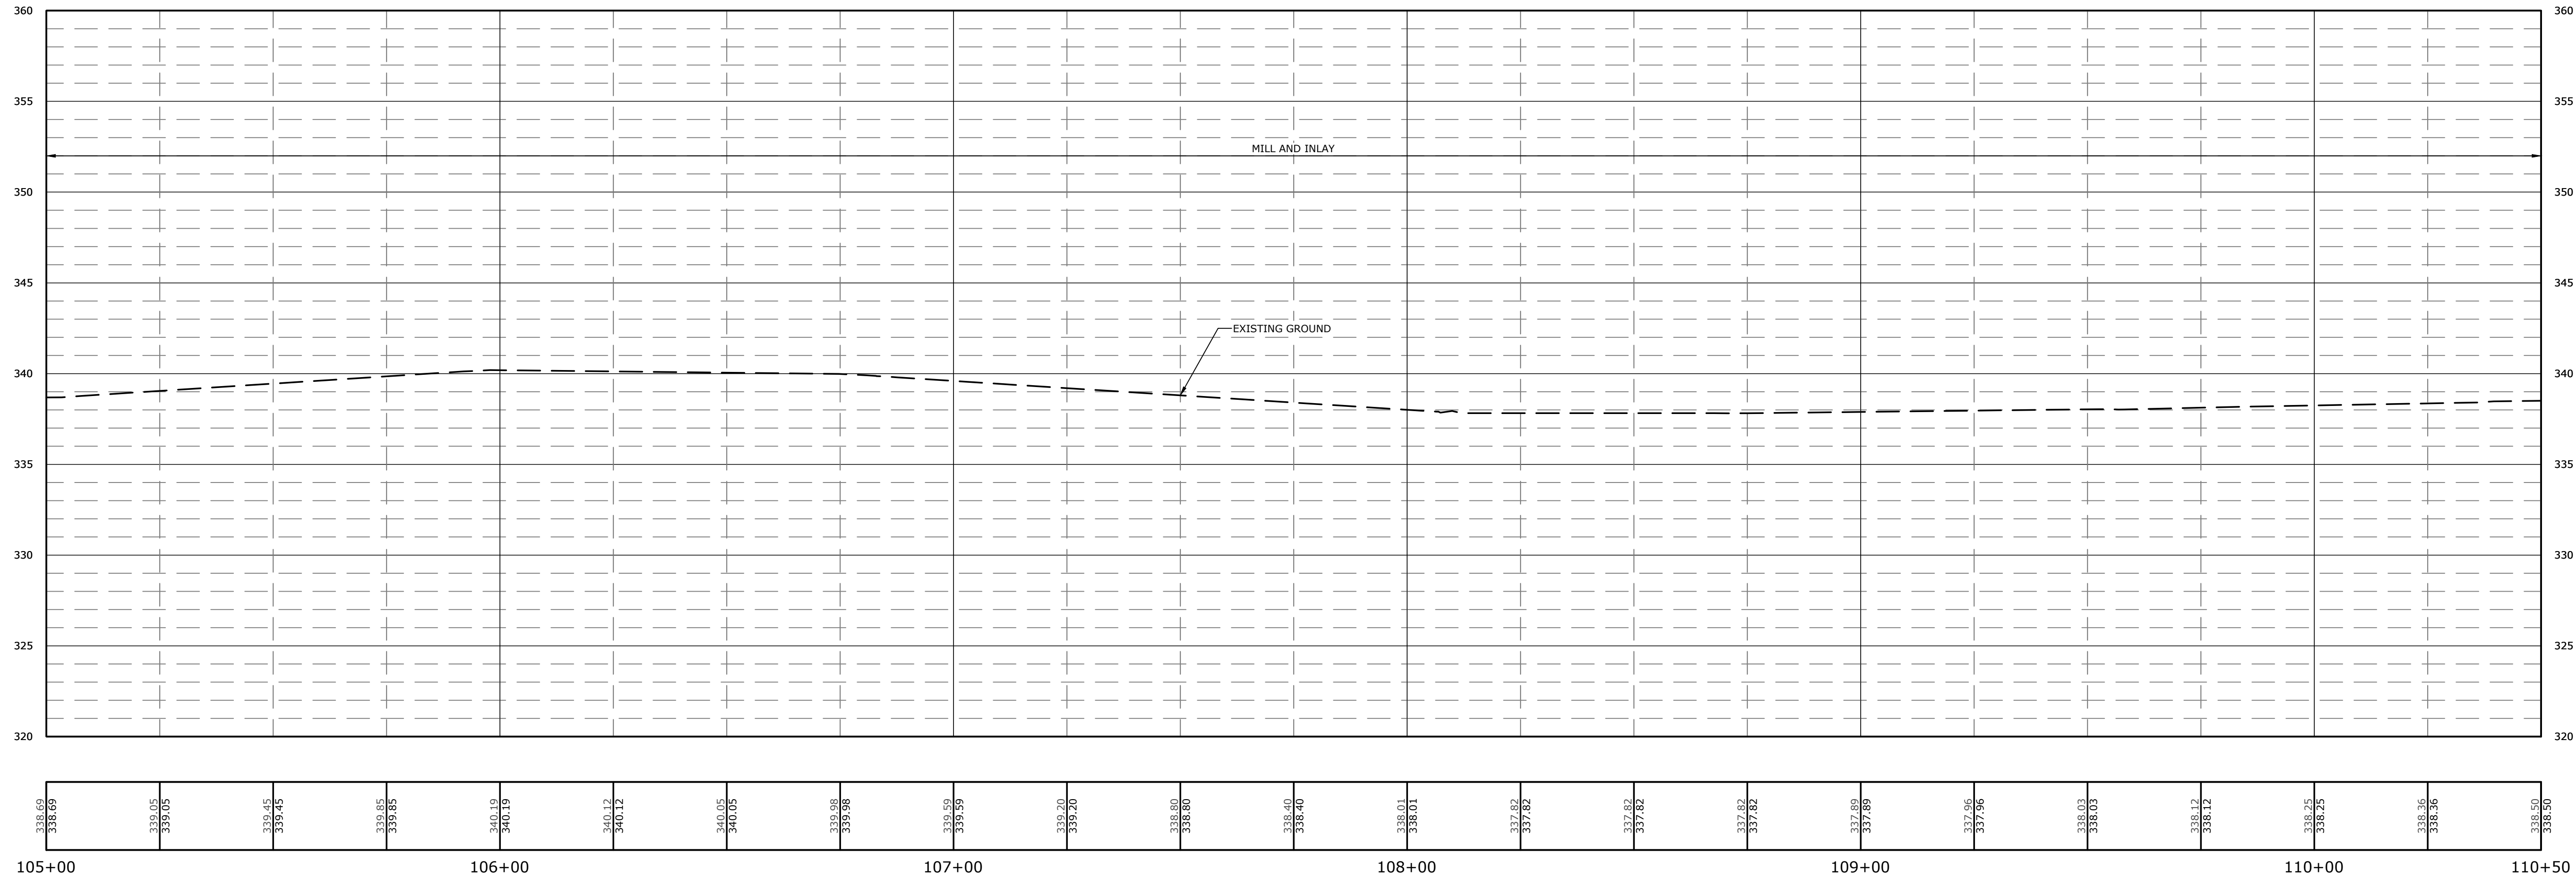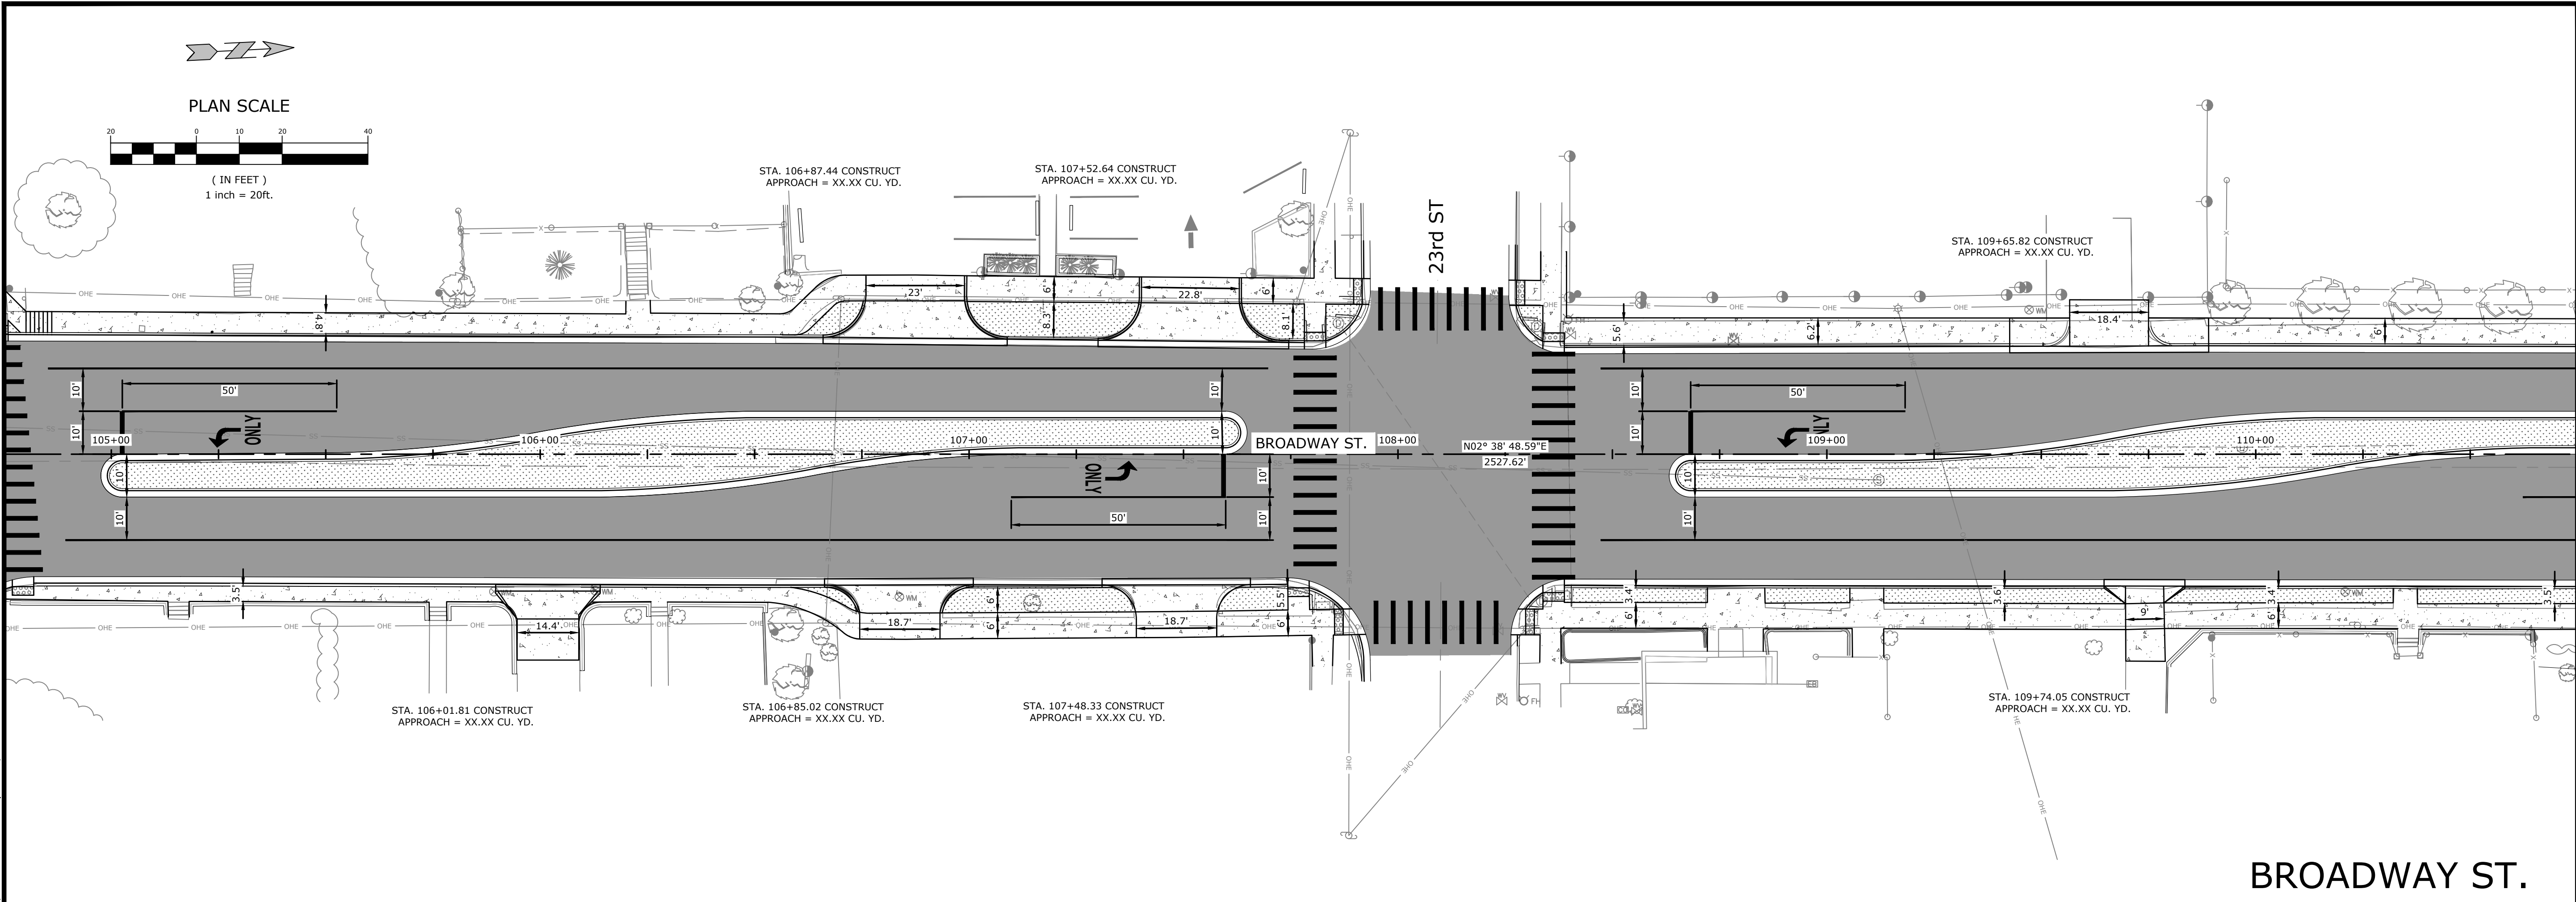

MCE McCLELLAND
DESIGNED TO SERVE
CONSULTING ENGINEERS, INC.

7302 KANIS ROAD
LITTLE ROCK, ARKANSAS 72204
(501) 371-0272
HTTP://WWW.MCE-US.COM

PRELIMINARY
NOT FOR
CONSTRUCTION

ORIGINAL SIGNATURE ON FILE

ROOSEVELT RD. - 17TH ST. IMPVTS
(HWY. 70) (LITTLE ROCK) (S)
ROOSEVELT RD. - 17TH ST.
LITTLE ROCK, ARKANSAS

©2025

811
Know what's below.
Call before you dig.


REV	DATE	DESCRIPTION

PLAN AND
PROFILE

DESIGNED BY: SS	DRAWN BY: AC
DATE: 4/11/2025	REVISION: ----
SCALE: 1" = 20'	JOB NUMBER: 0618383

C6

W:\2024\24-5814 Little Rock - Job No. 061838 Roosevelt Rd. - 17th Impvts. (Hwy. 70) (Little Rock) (S)\Design Drawings\Sheets\24-5814 DESIGN.dwg, PRINTED ON: April 11, 2025 @ 11:27 AM

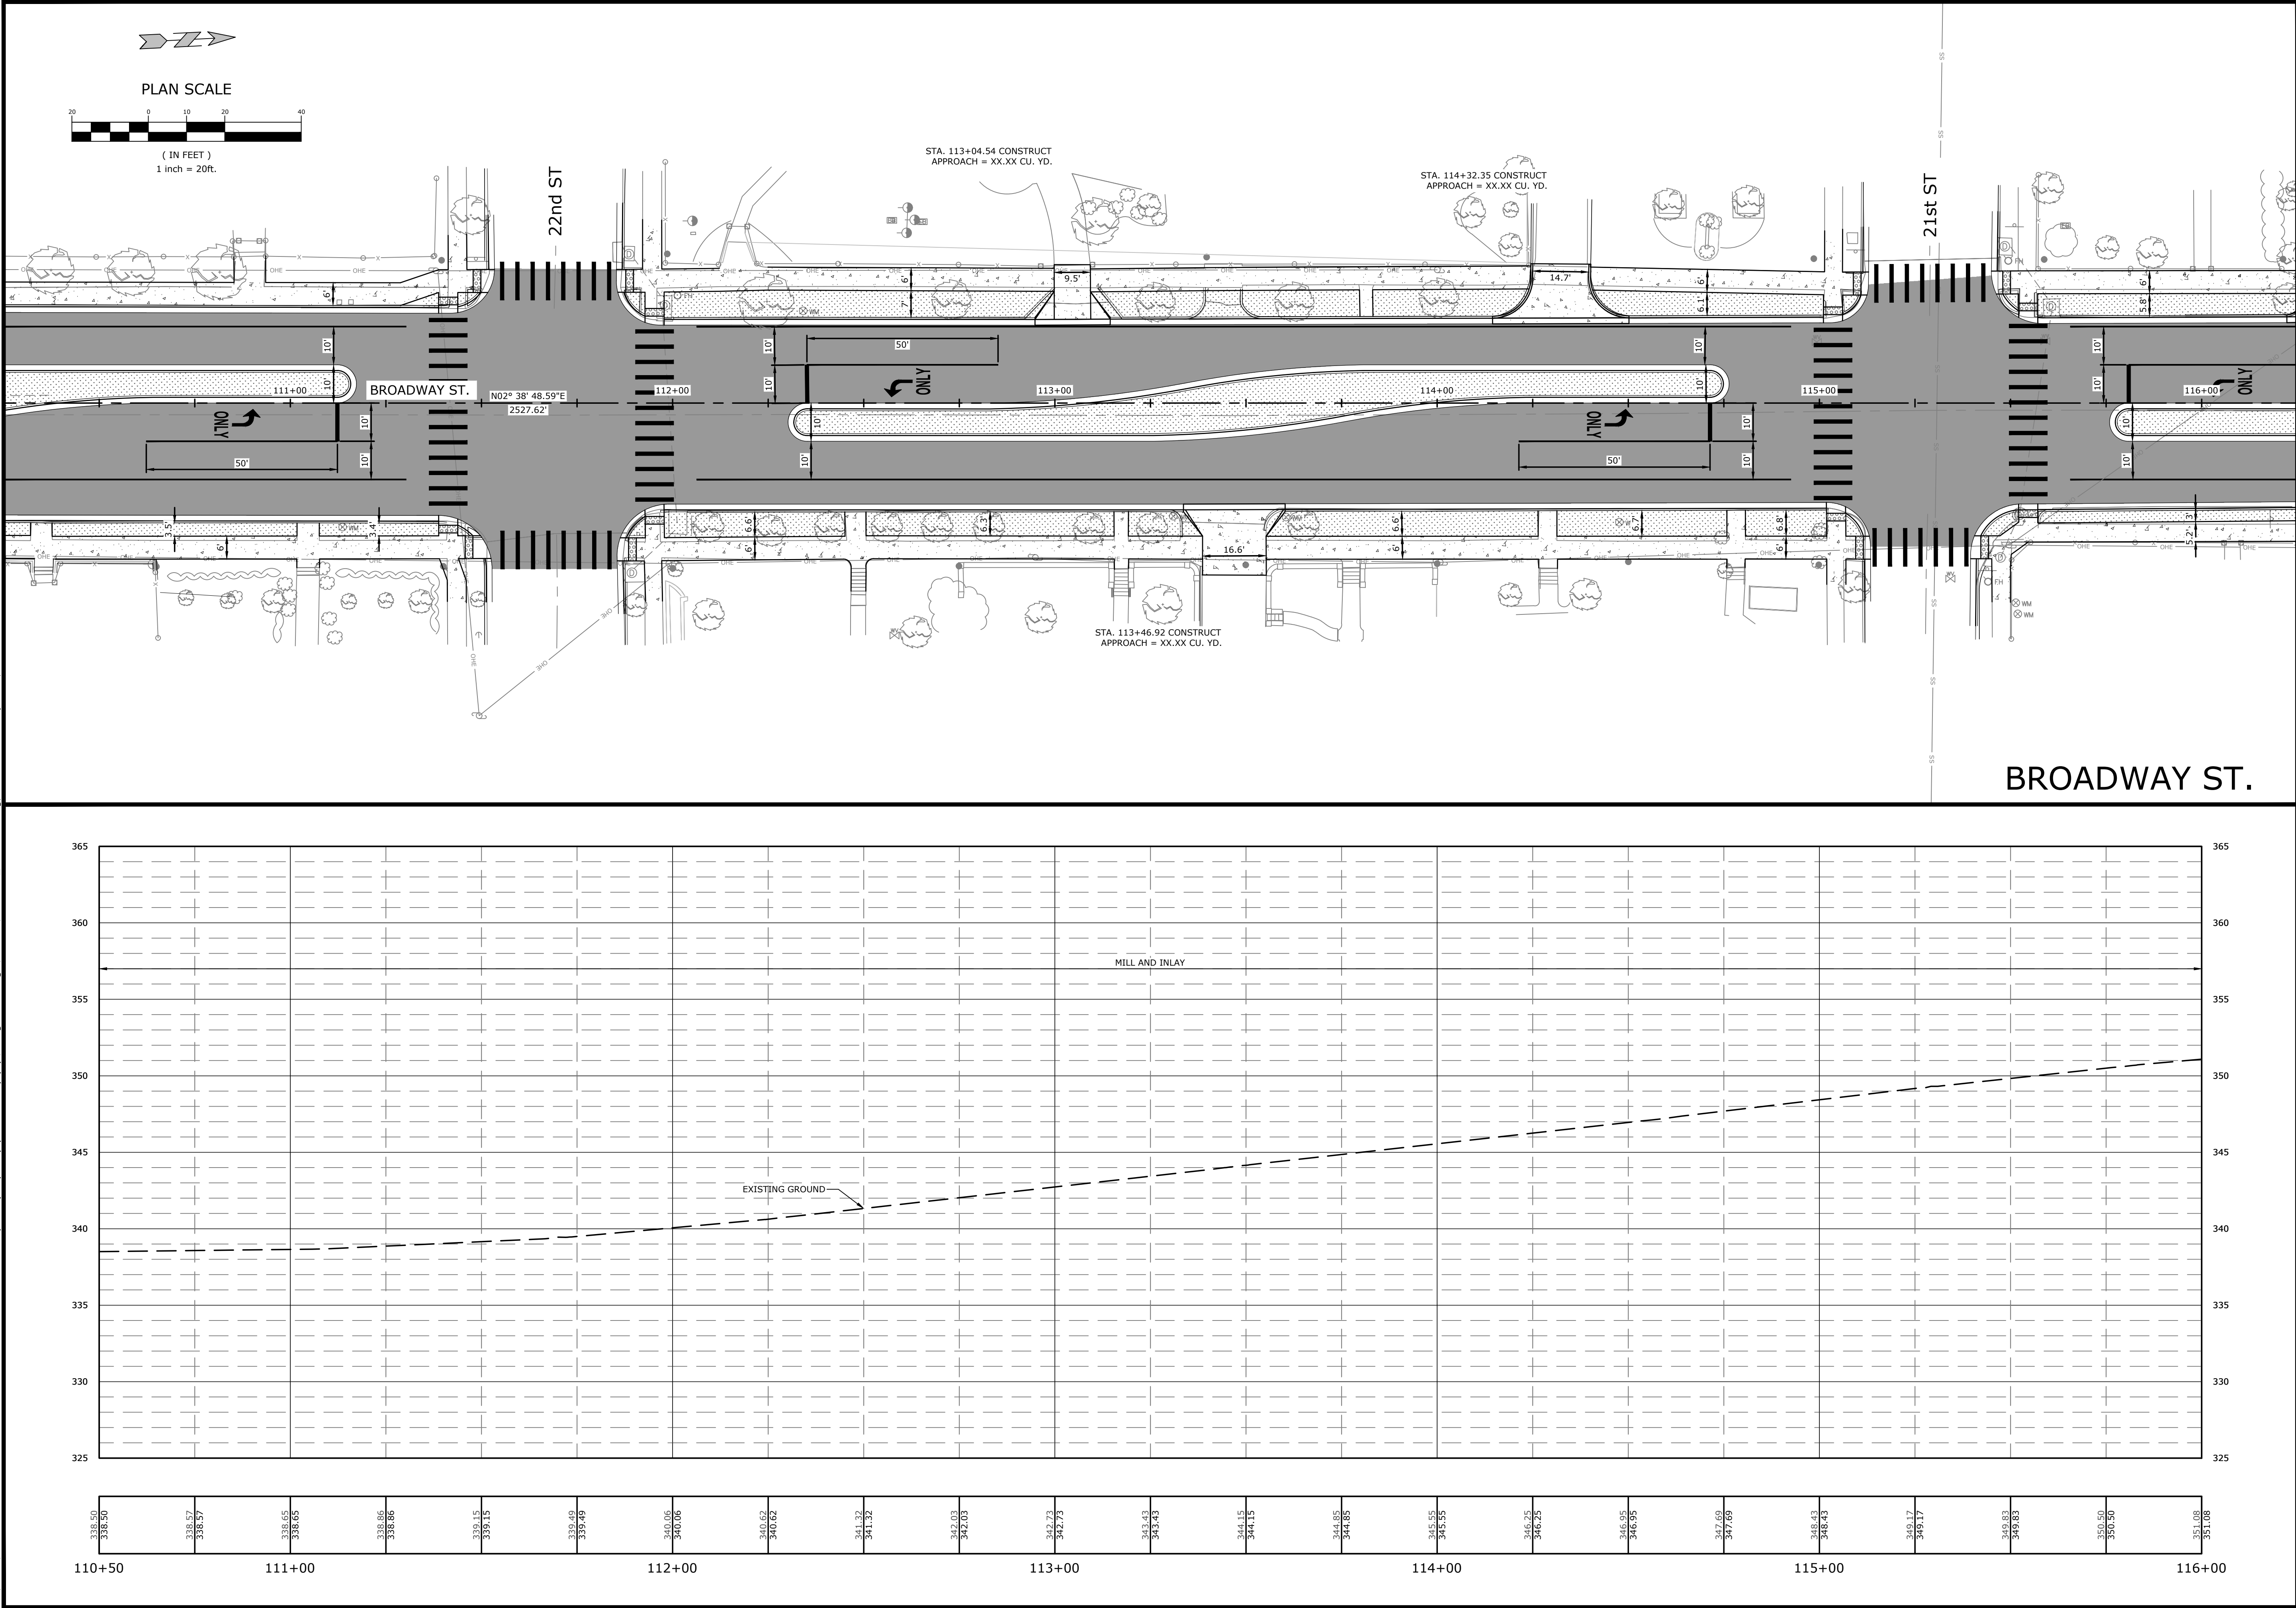

MCE McClelland Consulting Engineers, Inc.
DESIGNED TO SERVE ENGINEERS, INC.
7302 KANIS ROAD
LITTLE ROCK, ARKANSAS 72204
(501) 371-0272
HTTP://WWW.MCE-US.COM

PRELIMINARY
NOT FOR
CONSTRUCTION

ORIGINAL SIGNATURE ON FILE

811
Know what's below.
Call before you dig.

REVISIONS	
REV	DESCRIPTION

DESIGNED BY: SS
DATE: 4/11/2025
SCALE: 1" = 20'



DRAWN BY: AC
REVISION: ----
JOB NUMBER: 0618383

C7

PLAN AND PROFILE

**ROOSEVELT RD. - 17TH ST. IMPVTS
(HWY. 70) (LITTLE ROCK) (S)
ROOSEVELT RD. - 17TH ST.
LITTLE ROCK, ARKANSAS**

W:\2024\24-5814 Little Rock - Job No. 061838 Roosevelt Rd. - 17th Impvts. (Hwy. 70) (Little Rock) (S)\Design Drawings\Sheets\24-5814 DESIGN.dwg, PRINTED ON: April 11, 2025 @ 11:27 AM

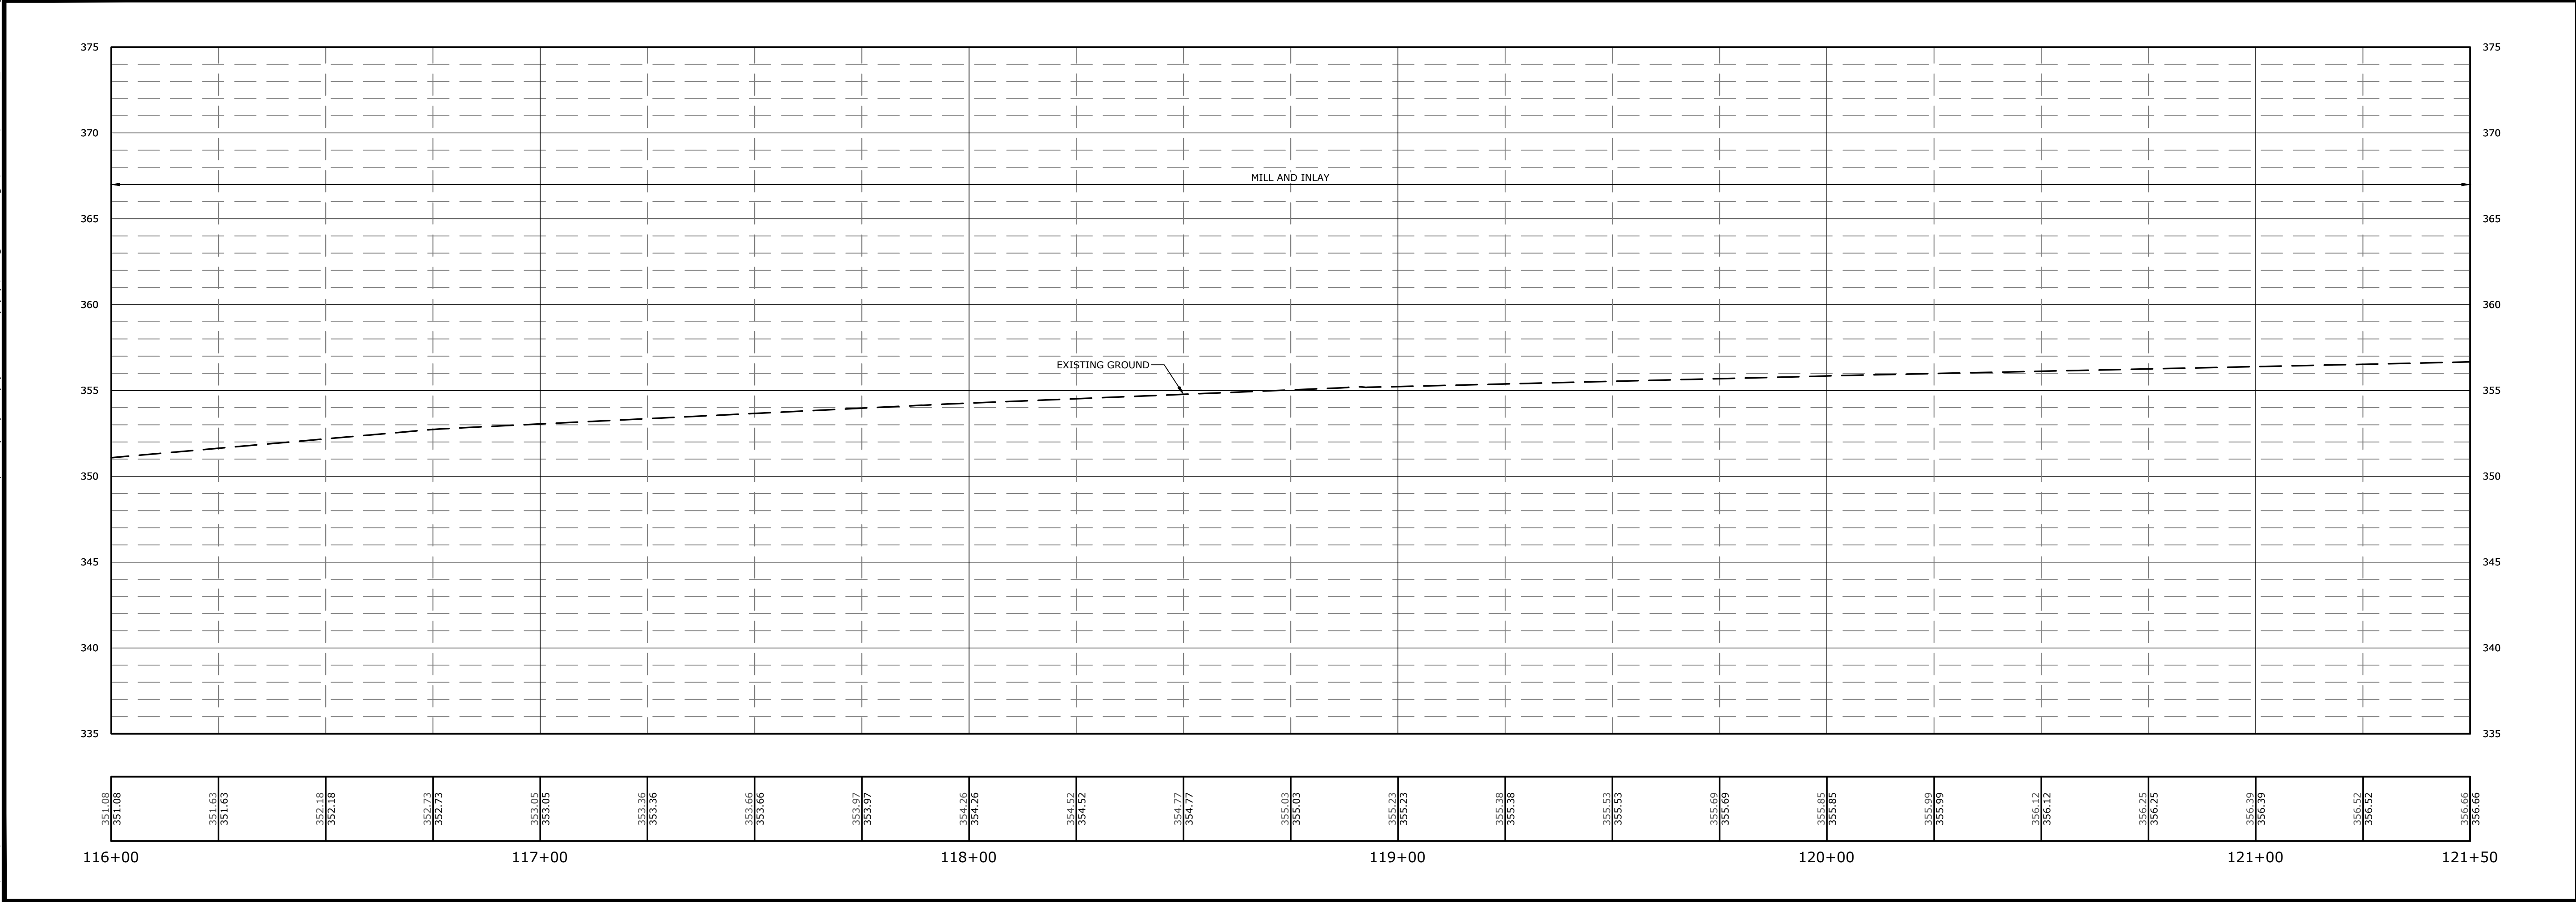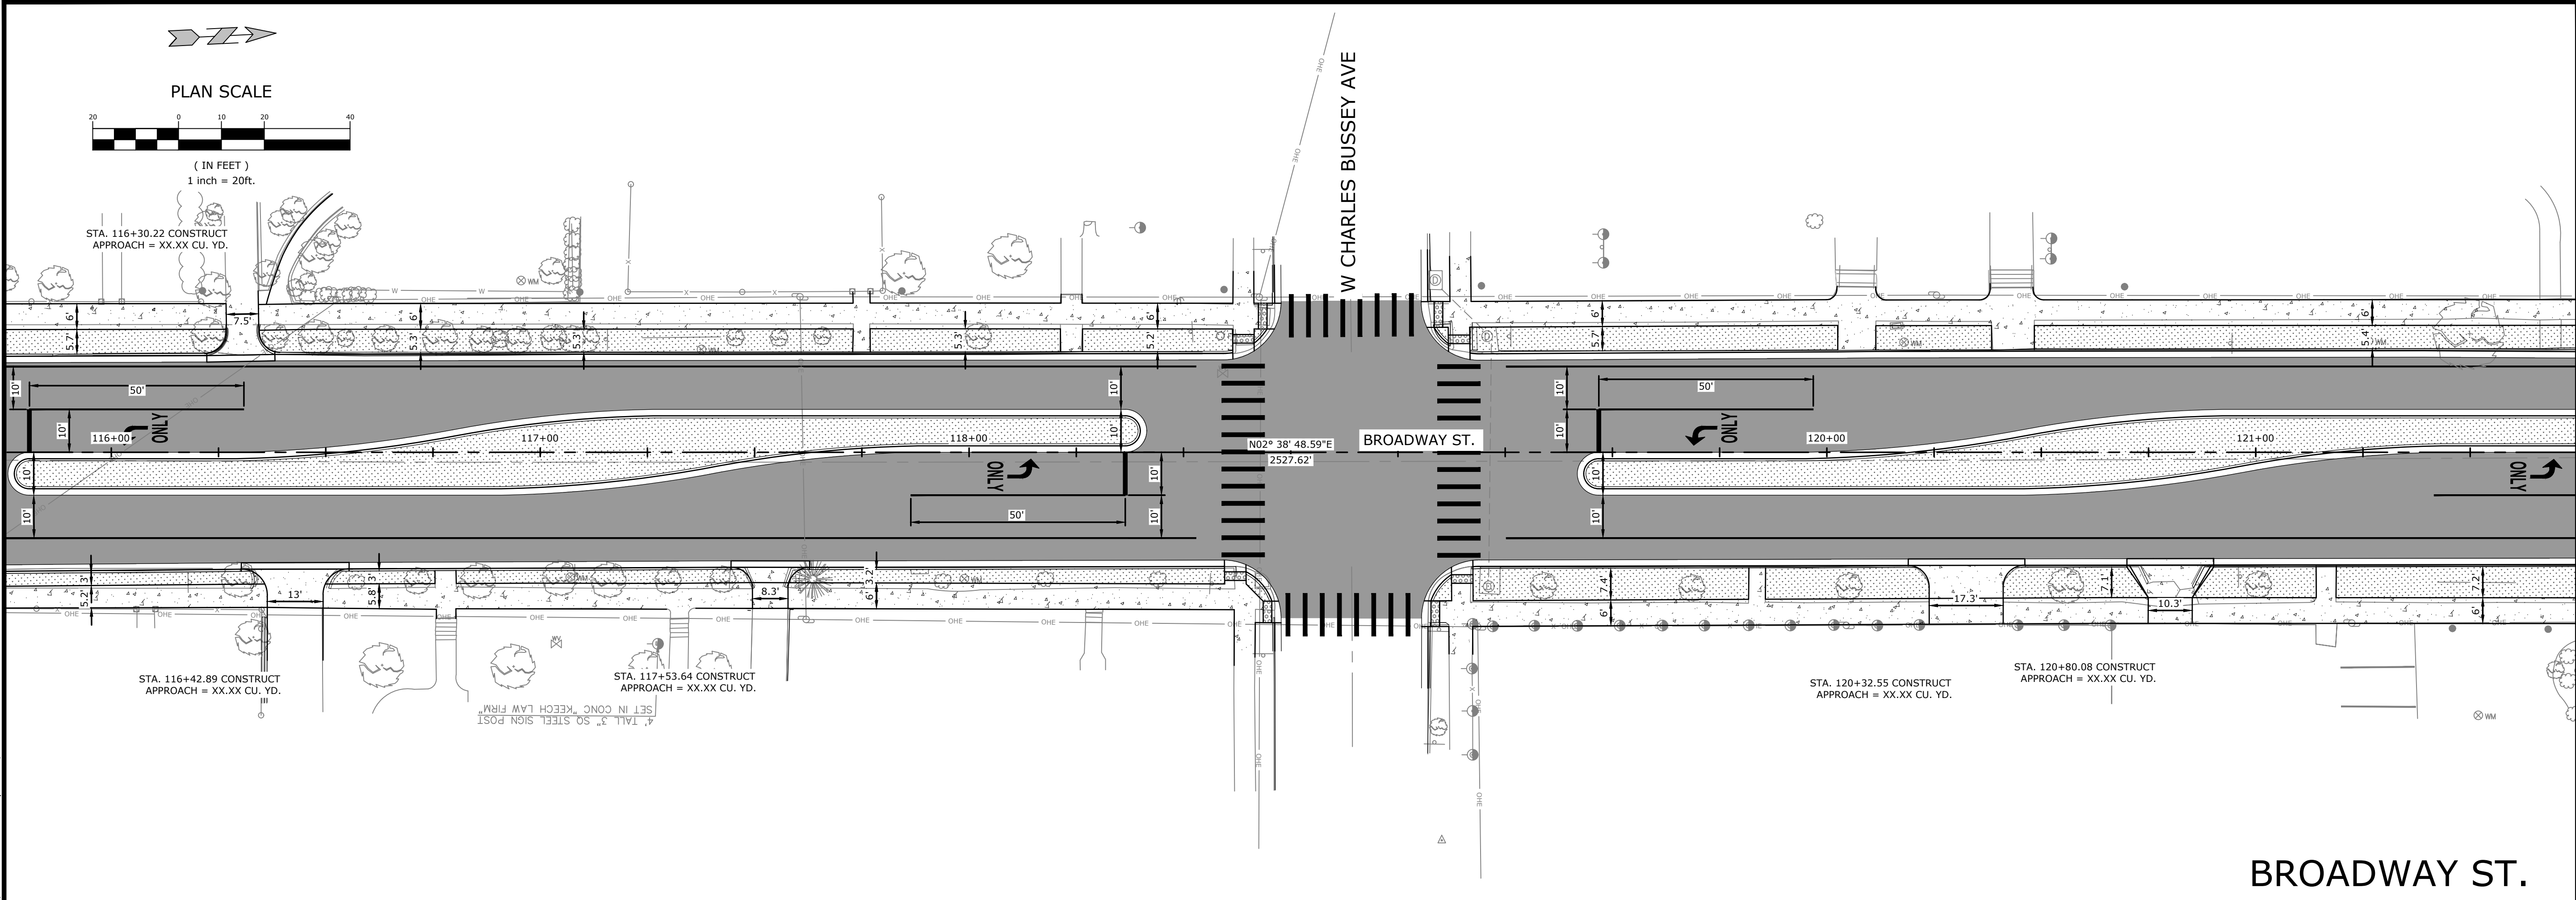



7302 KANIS ROAD
LITTLE ROCK, ARKANSAS 72204
(501) 371-0272
HTTP://WWW.MCE.US.COM

PRELIMINARY
NOT FOR
CONSTRUCTION

ORIGINAL SIGNATURE ON FILE

ROOSEVELT RD. - 17TH ST. IMPVTS
(HWY. 70) (LITTLE ROCK) (S)
ROOSEVELT RD. - 17TH ST.
LITTLE ROCK, ARKANSAS



Know what's below.
Call before you dig.



REVISIONS	
REV	DESCRIPTION

PLAN AND
PROFILE

DESIGNED BY: SS	DRAWN BY: AC
DATE: 4/11/2025	REVISION: ----
SCALE: 1" = 20'	JOB NUMBER: 0618383

C8

W:\2024\24-5814 Little Rock - Job No. 061838 Roosevelt Rd. - 17th Impvts. (Hwy. 70) (Little Rock) (S)\Design Drawings\Sheets\24-5814_DESIGN.dwg, PRINTED ON: April 11, 2025 @ 11:27 AM

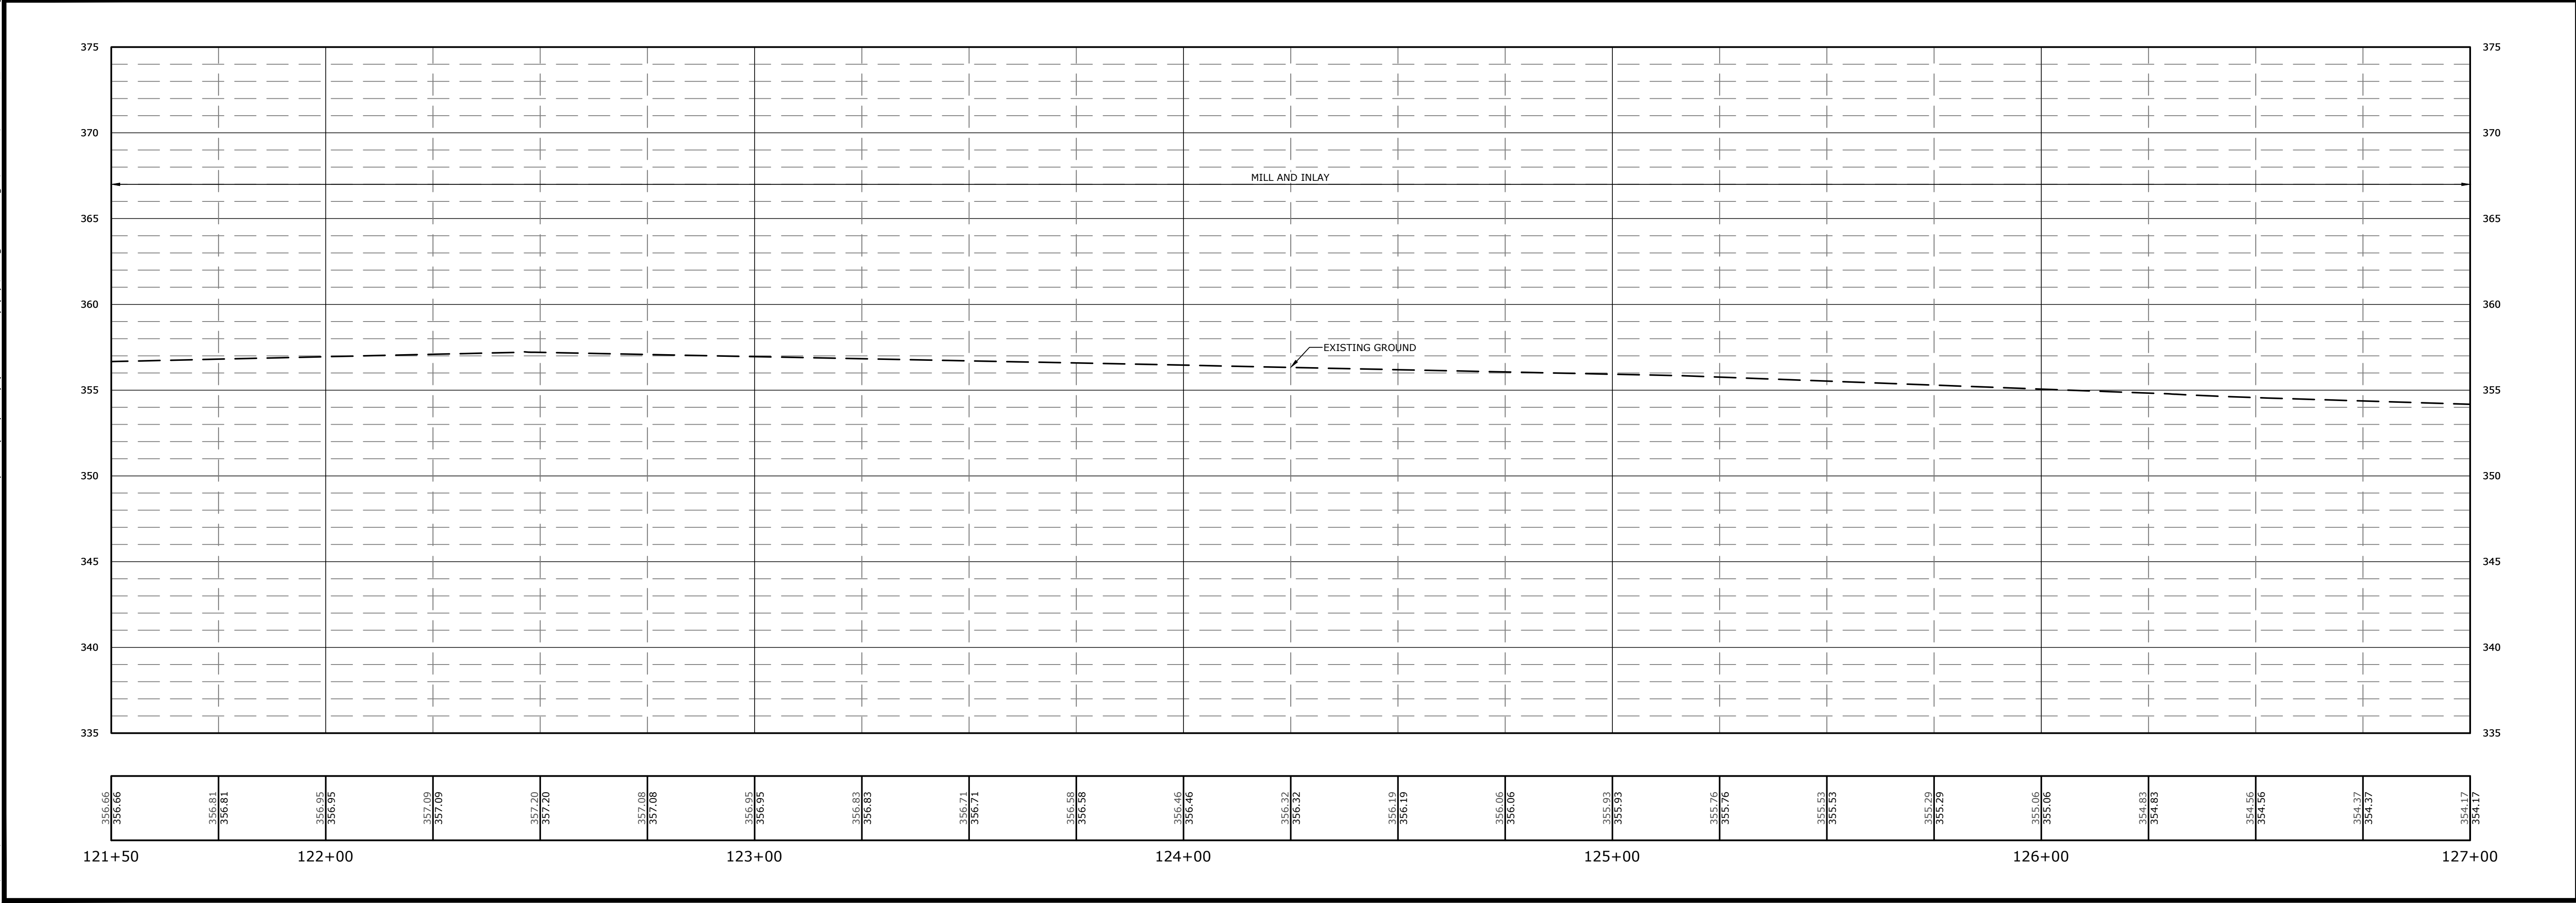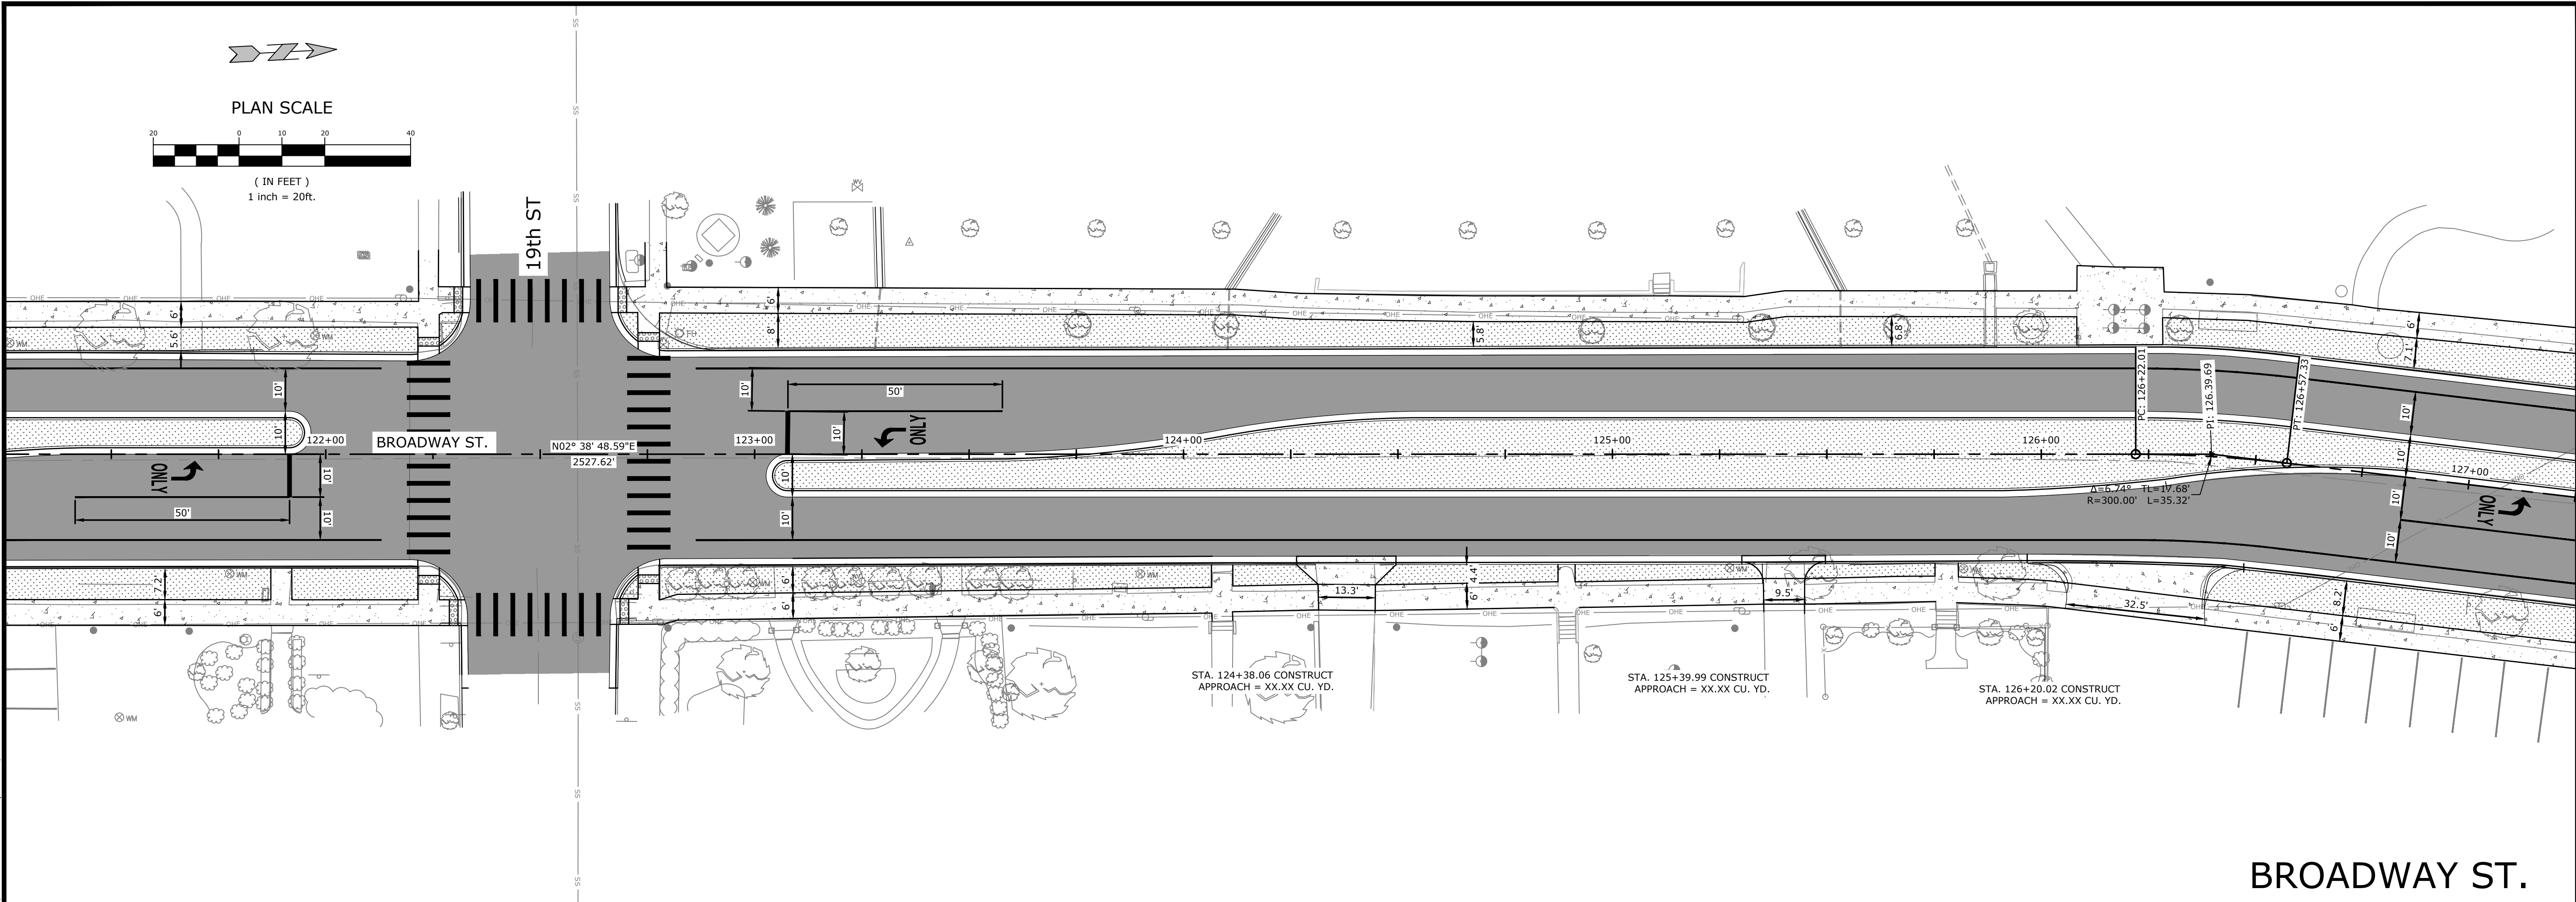



7302 KANIS ROAD
LITTLE ROCK, ARKANSAS 72204
(501) 371-0272
HTTP://WWW.MCE.US.COM

PRELIMINARY
NOT FOR
CONSTRUCTION

ORIGINAL SIGNATURE ON FILE

ROOSEVELT RD. - 17TH ST. IMPVTS
(HWY. 70) (LITTLE ROCK) (S)
ROOSEVELT RD. - 17TH ST.
LITTLE ROCK, ARKANSAS



Know what's below.
Call before you dig.


REVISIONS	
REV	DESCRIPTION

PLAN AND
PROFILE

DESIGNED BY: SS	DRAWN BY: AC
DATE: 4/11/2025	REVISION: ----
SCALE: 1" = 20'	JOB NUMBER: 0618383

C9

W:\2024\24-5814 Little Rock - Job No. 061838 Roosevelt Rd. - 17th Impvts. (Hwy. 70) (Little Rock) (S)\Design Drawings\Sheets\24-5814 DESIGN.dwg, PRINTED ON: April 11, 2025 @ 11:28 AM

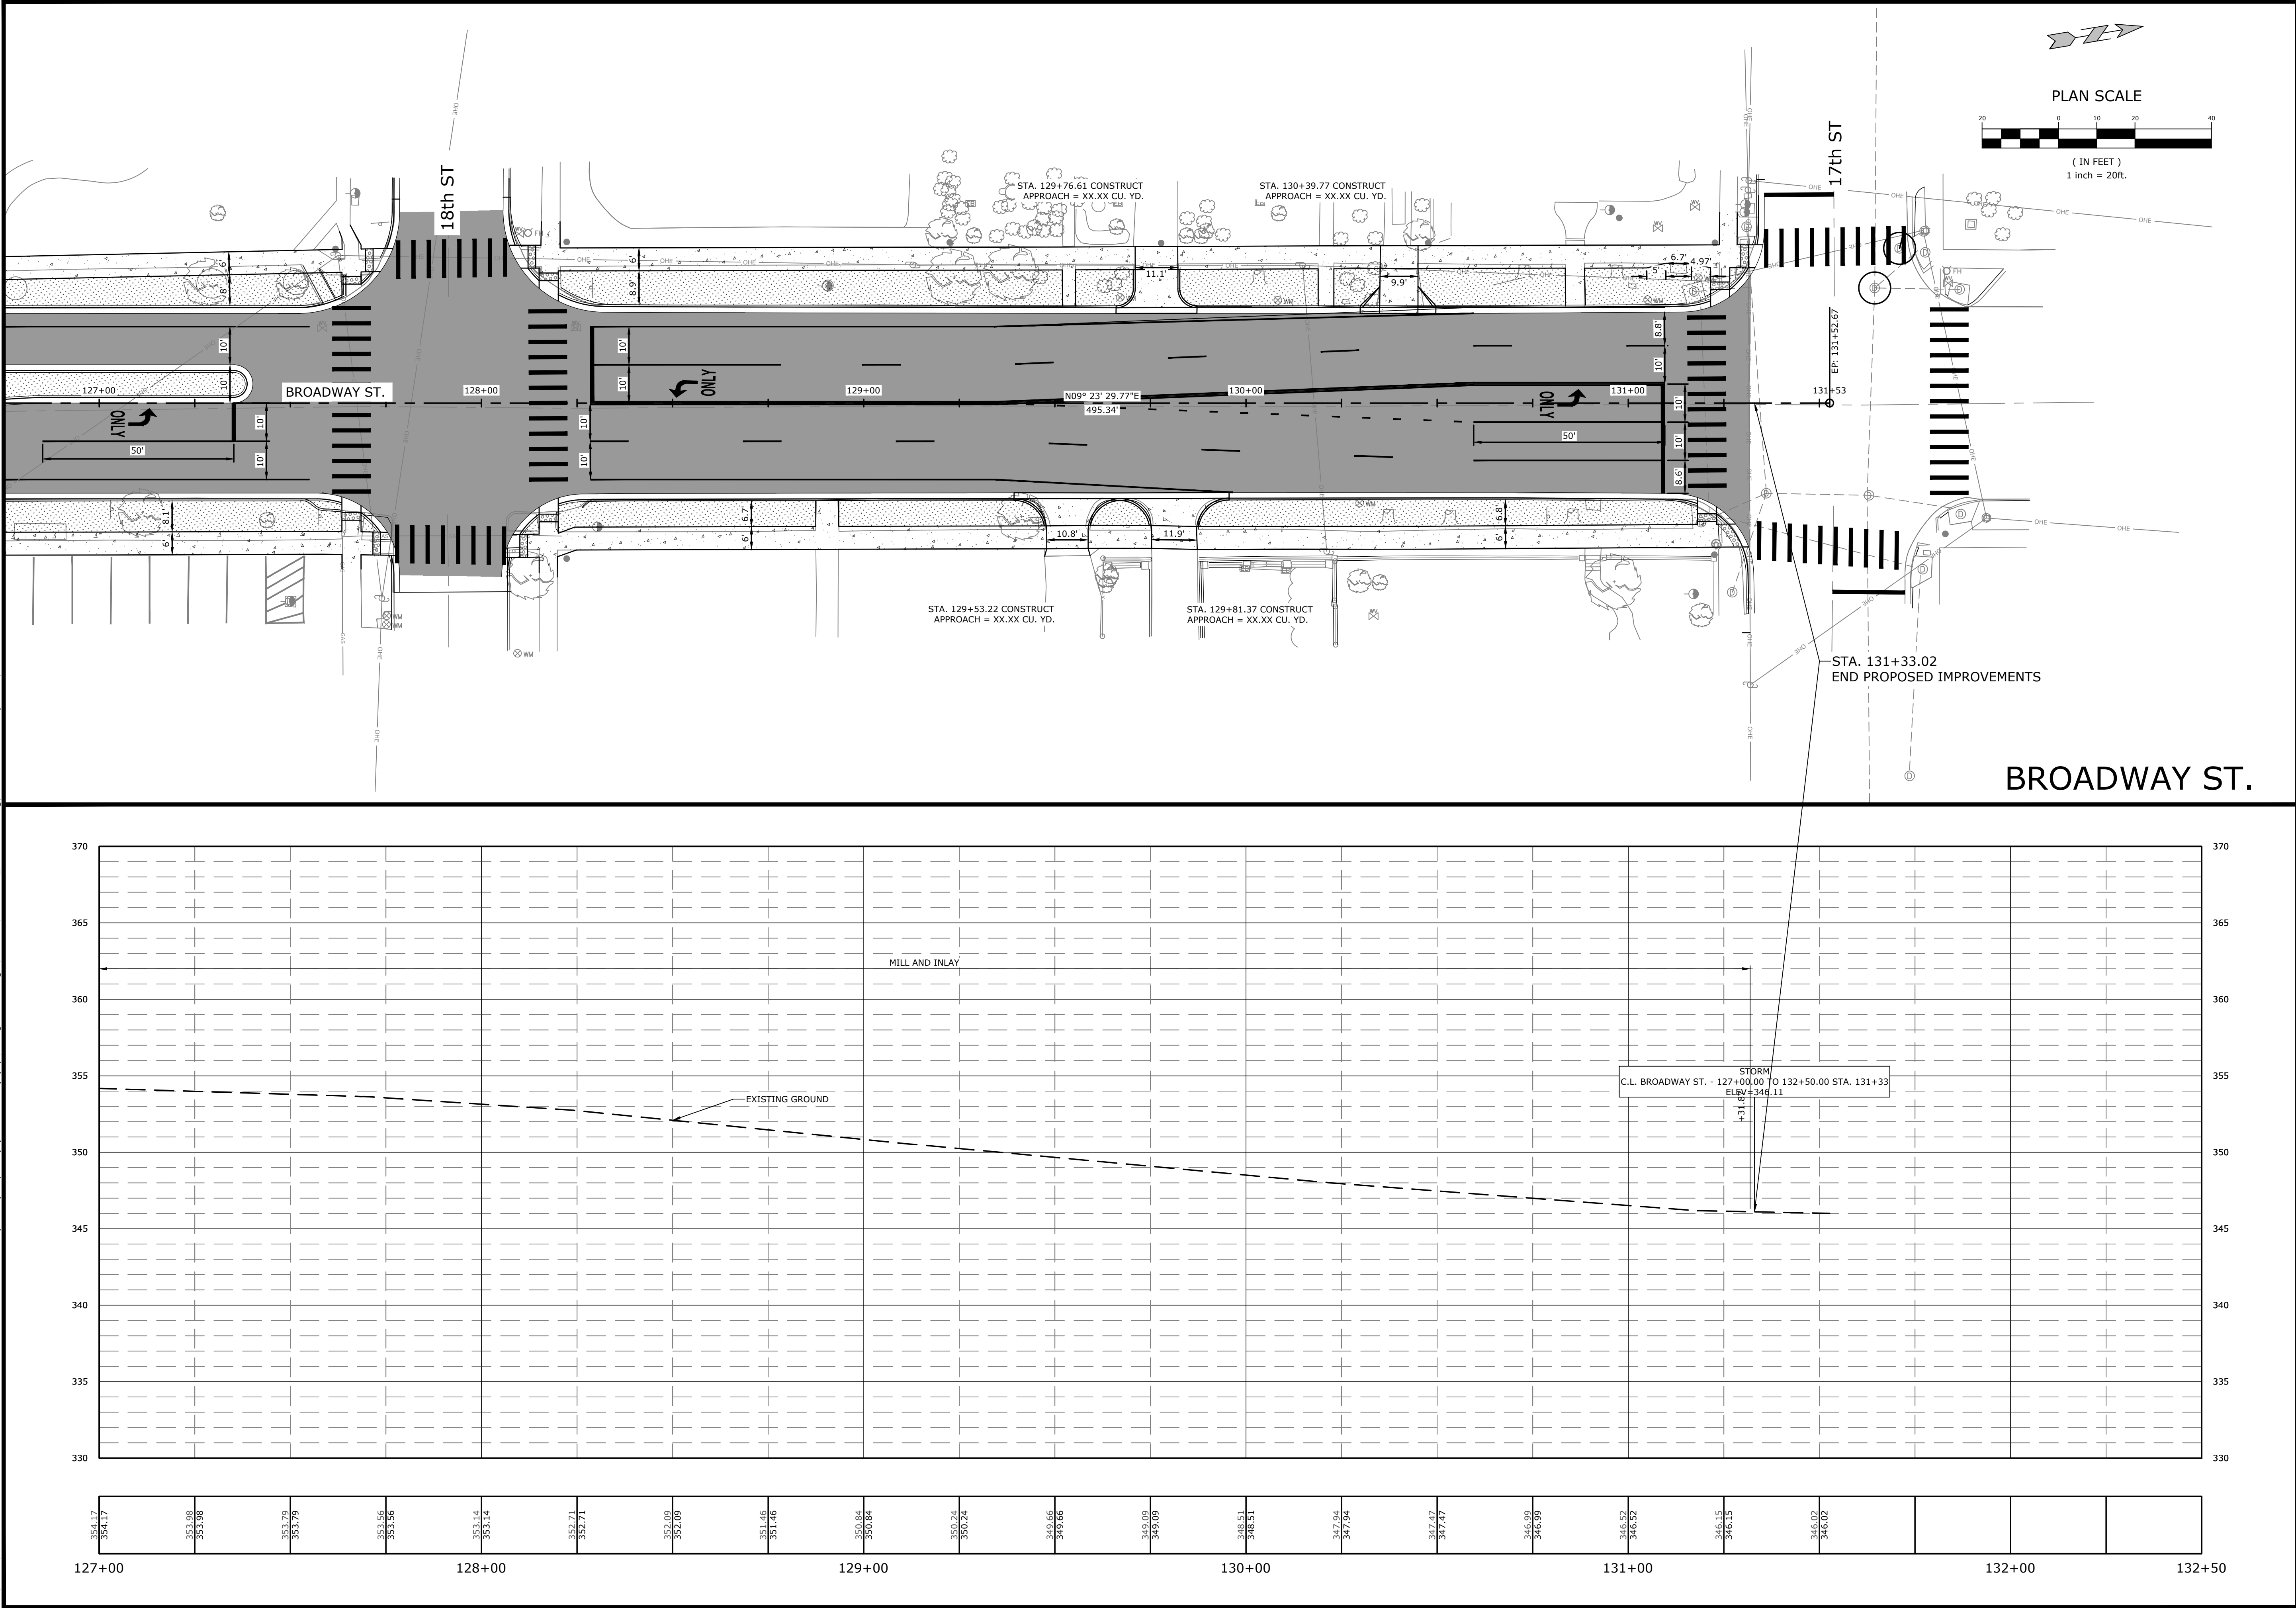

MCE McCLELLAND CONSULTING, INC.
DESIGNED TO SERVE ENGINEERS, INC.

7302 KANIS ROAD
LITTLE ROCK, ARKANSAS 72204
(501) 371-0272
HTTP://WWW.MCE-US.COM

PRELIMINARY
NOT FOR
CONSTRUCTION

ORIGINAL SIGNATURE ON FILE

ROOSEVELT RD. - 17TH ST. IMPVTS
(HWY. 70) (LITTLE ROCK) (S)
ROOSEVELT RD. - 17TH ST.
LITTLE ROCK, ARKANSAS

811
Know what's below.
Call before you dig.

REV	DATE	DESCRIPTION

PLAN AND PROFILE

DESIGNED BY: SS	DRAWN BY: AC
DATE: 4/11/2025	REVISION: ----
SCALE: 1" = 20'	JOB NUMBER: 0618383

C10